

LEGEND

- ASME SECTION XI CLASS 1 PIPING (RED)
 - - - ASME SECTION XI CLASS 2 PIPING (BLUE)
 - - - - ASME SECTION XI CLASS 3 PIPING (GREEN)
 — — — — REFERENCE & CONTINUITY
 — D — D — HVAC DUCT

ISIM2- REFERENCE TO THE PIPING ISOMETRIC DRAWING FOR DETAILS ON THE PIPING CONFIGURATION, AND THE LOCATION AND IDENTIFICATION OF WELDS AND SUPPORTS.

☐ RESERVED FOR SPECIAL ISI REQUIREMENTS. (MAY BE)
ACCOMPANIED BY SPECIFIC NOTES.


➡ REFERENCE TO THE ISI ITEM NUMBER DESIGNATION USED IN THE FIRST 10 YEAR INSERVICE INSPECTION INTERVAL.

ASME SECTION XI CLASS CHANGE

 ISI PROGRAM BOUNDARY

NOTES:

1. DELETED
2. FOR IS1 BOUNDARY DIAGRAM INDEX SHEET AND GENERAL NOTES, SEE IS102-001.
3. FOR PIPING SYMBOLS AND P & ID INDEX, SEE DRAWING M-001.
4. UNLESS OTHERWISE NOTED, ALL VENT CONNECTIONS ARE ¾" AND DRAIN CONNECTIONS ARE 1". LINE IDENTIFICATION IS THE SAME AS THE HEADER.

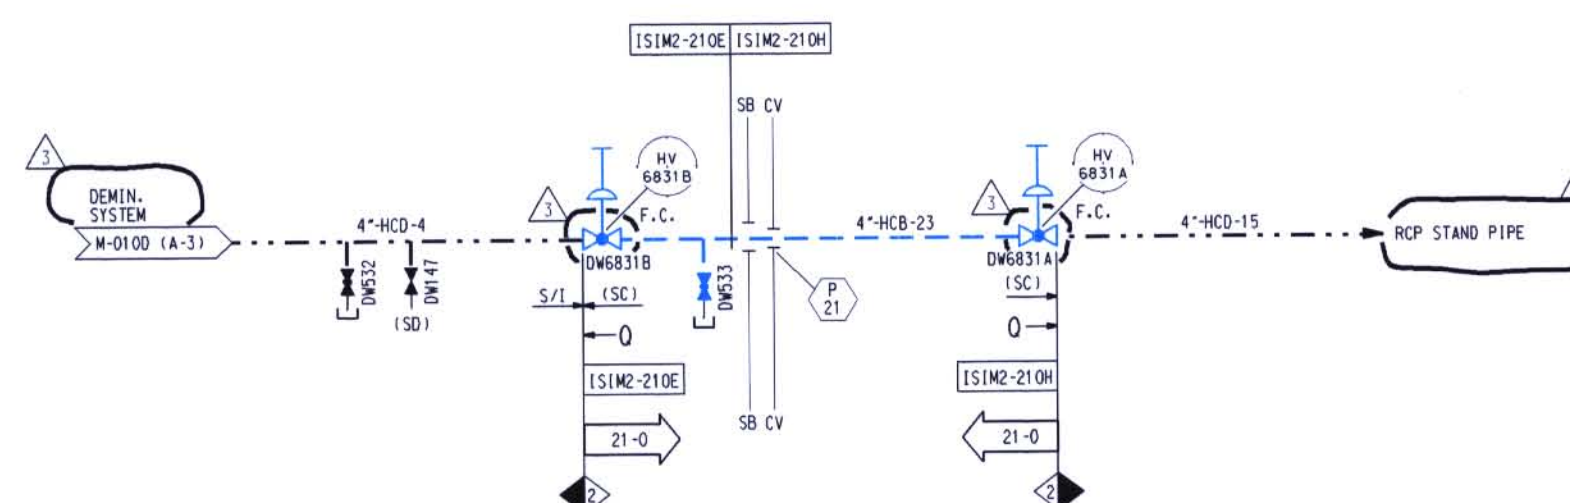

D-007

<div><div><div></div><div></div><div></div><div></div></div><div><div></div><div></div><div></div><div></div></div></div>		INC. DCN ISID2-010C-3 PER DOR 01-1685 B GEN. UPDATE CORRECT REV. 1 & 2 REVISION DESCRIPTION TO INC. DCN (NOT ISID DCN)										<div><div></div><div></div><div></div><div></div></div>	
<div><div><div></div><div></div><div></div><div></div></div><div><div></div><div></div><div></div><div></div></div></div>		INC. DCN ISID2-010C-2 PER DOR 00-1766										<div><div></div><div></div><div></div><div></div></div> SWB	
<div><div><div></div><div></div><div></div><div></div></div><div><div></div><div></div><div></div><div></div></div></div>		INC. DCN ISID2-010C-1 FOR DOR 01-2011										<div><div></div><div></div><div></div><div></div></div> INITIAL ON FILE	
<div><div><div></div><div></div><div></div><div></div></div><div><div></div><div></div><div></div><div></div></div></div>		ISSUED FOR SECOND 10 YEAR ISI PROGRAM										<div><div></div><div></div><div></div><div></div></div> CB MTF JBG JOE WGP ECE	
<div><div><div></div><div></div><div></div><div></div></div><div><div></div><div></div><div></div><div></div></div></div>		REVISIONS										<div><div></div><div></div><div></div><div></div></div>	
<div><div><div></div><div></div><div></div><div></div></div><div><div></div><div></div><div></div><div></div></div></div>		DATE										<div><div></div><div></div><div></div><div></div></div> BY CHK ENGR. DESG. ENGR. ECE	
<div><div><div></div><div></div><div></div><div></div></div><div><div></div><div></div><div></div><div></div></div></div>		SCALE N.T.S.										<div><div></div><div></div><div></div><div></div></div> DATE	
<div><div><div></div><div></div><div></div><div></div></div><div><div></div><div></div><div></div><div></div></div></div>		DESIGNED										<div><div></div><div></div><div></div><div></div></div> DRWN CB	
<div><div><div></div><div></div><div></div><div></div></div><div><div></div><div></div><div></div><div></div></div></div>		MAKE-UP WATER TREATMENT SYSTEM										<div><div></div><div></div><div></div><div></div></div>	
<div><div><div></div><div></div><div></div><div></div></div><div><div></div><div></div><div></div><div></div></div></div>		INSERVICE INSPECTION DIAGRAM										<div><div></div><div></div><div></div><div></div></div>	
<div><div><div></div><div></div><div></div><div></div></div><div><div></div><div></div><div></div><div></div></div></div>		MAKE-UP WATER TREATMENT SYSTEM										<div><div></div><div></div><div></div><div></div></div>	
<div><div><div></div><div></div><div></div><div></div></div><div><div></div><div></div><div></div><div></div></div></div>		DRAWING NO.										<div><div></div><div></div><div></div><div></div></div> REV.	
<div><div><div></div><div></div><div></div><div></div></div><div><div></div><div></div><div></div><div></div></div></div>		ISID2-010C										<div><div></div><div></div><div></div><div></div></div> 3	