

 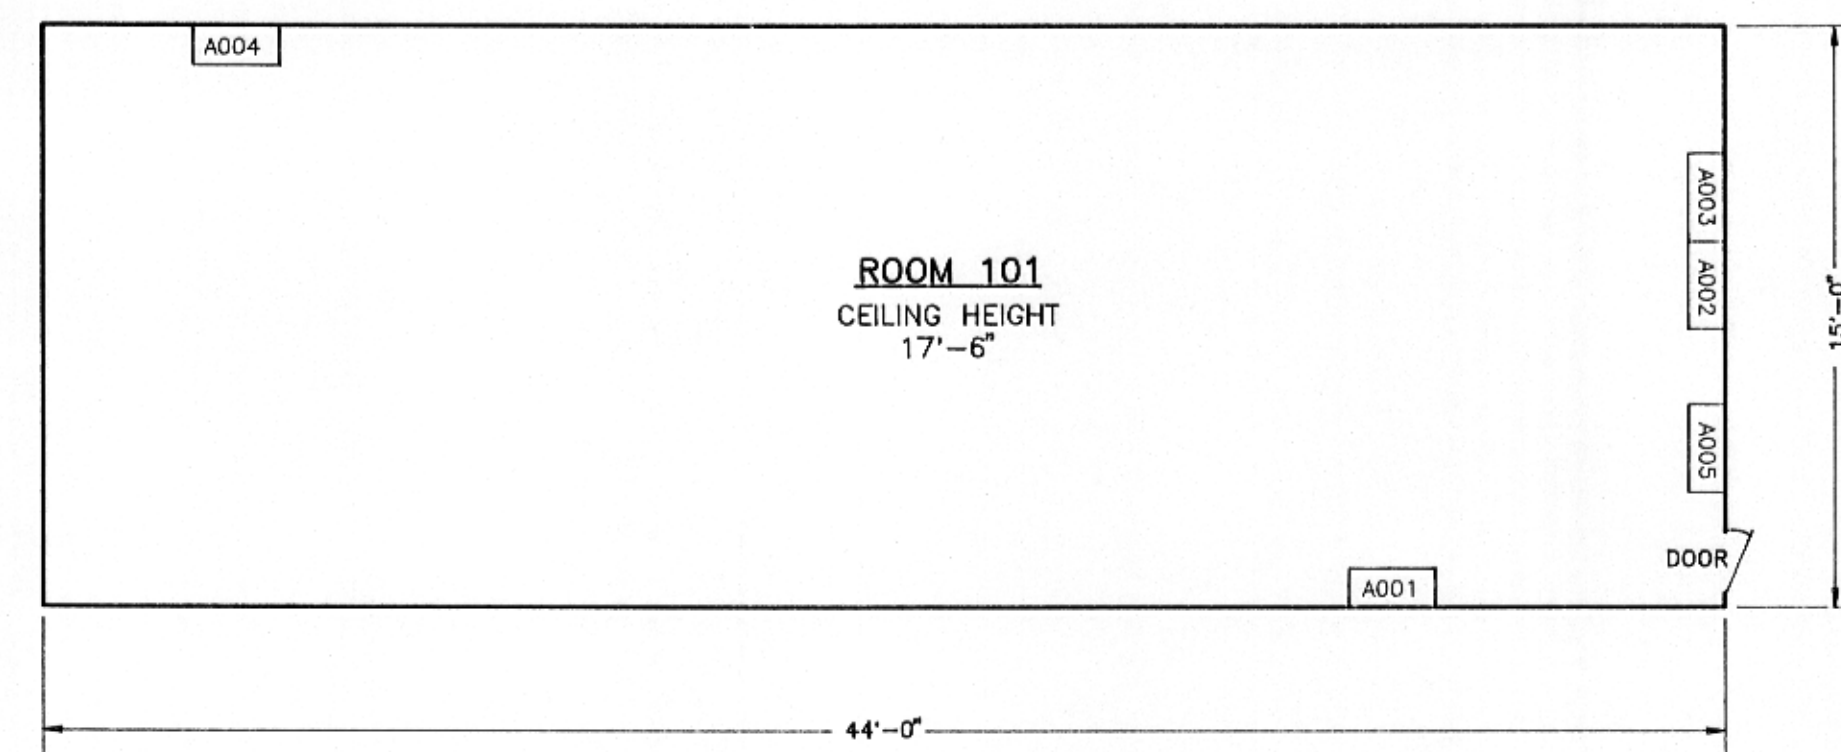



BUILDING 11
SODIUM REDUCTION BUILDING

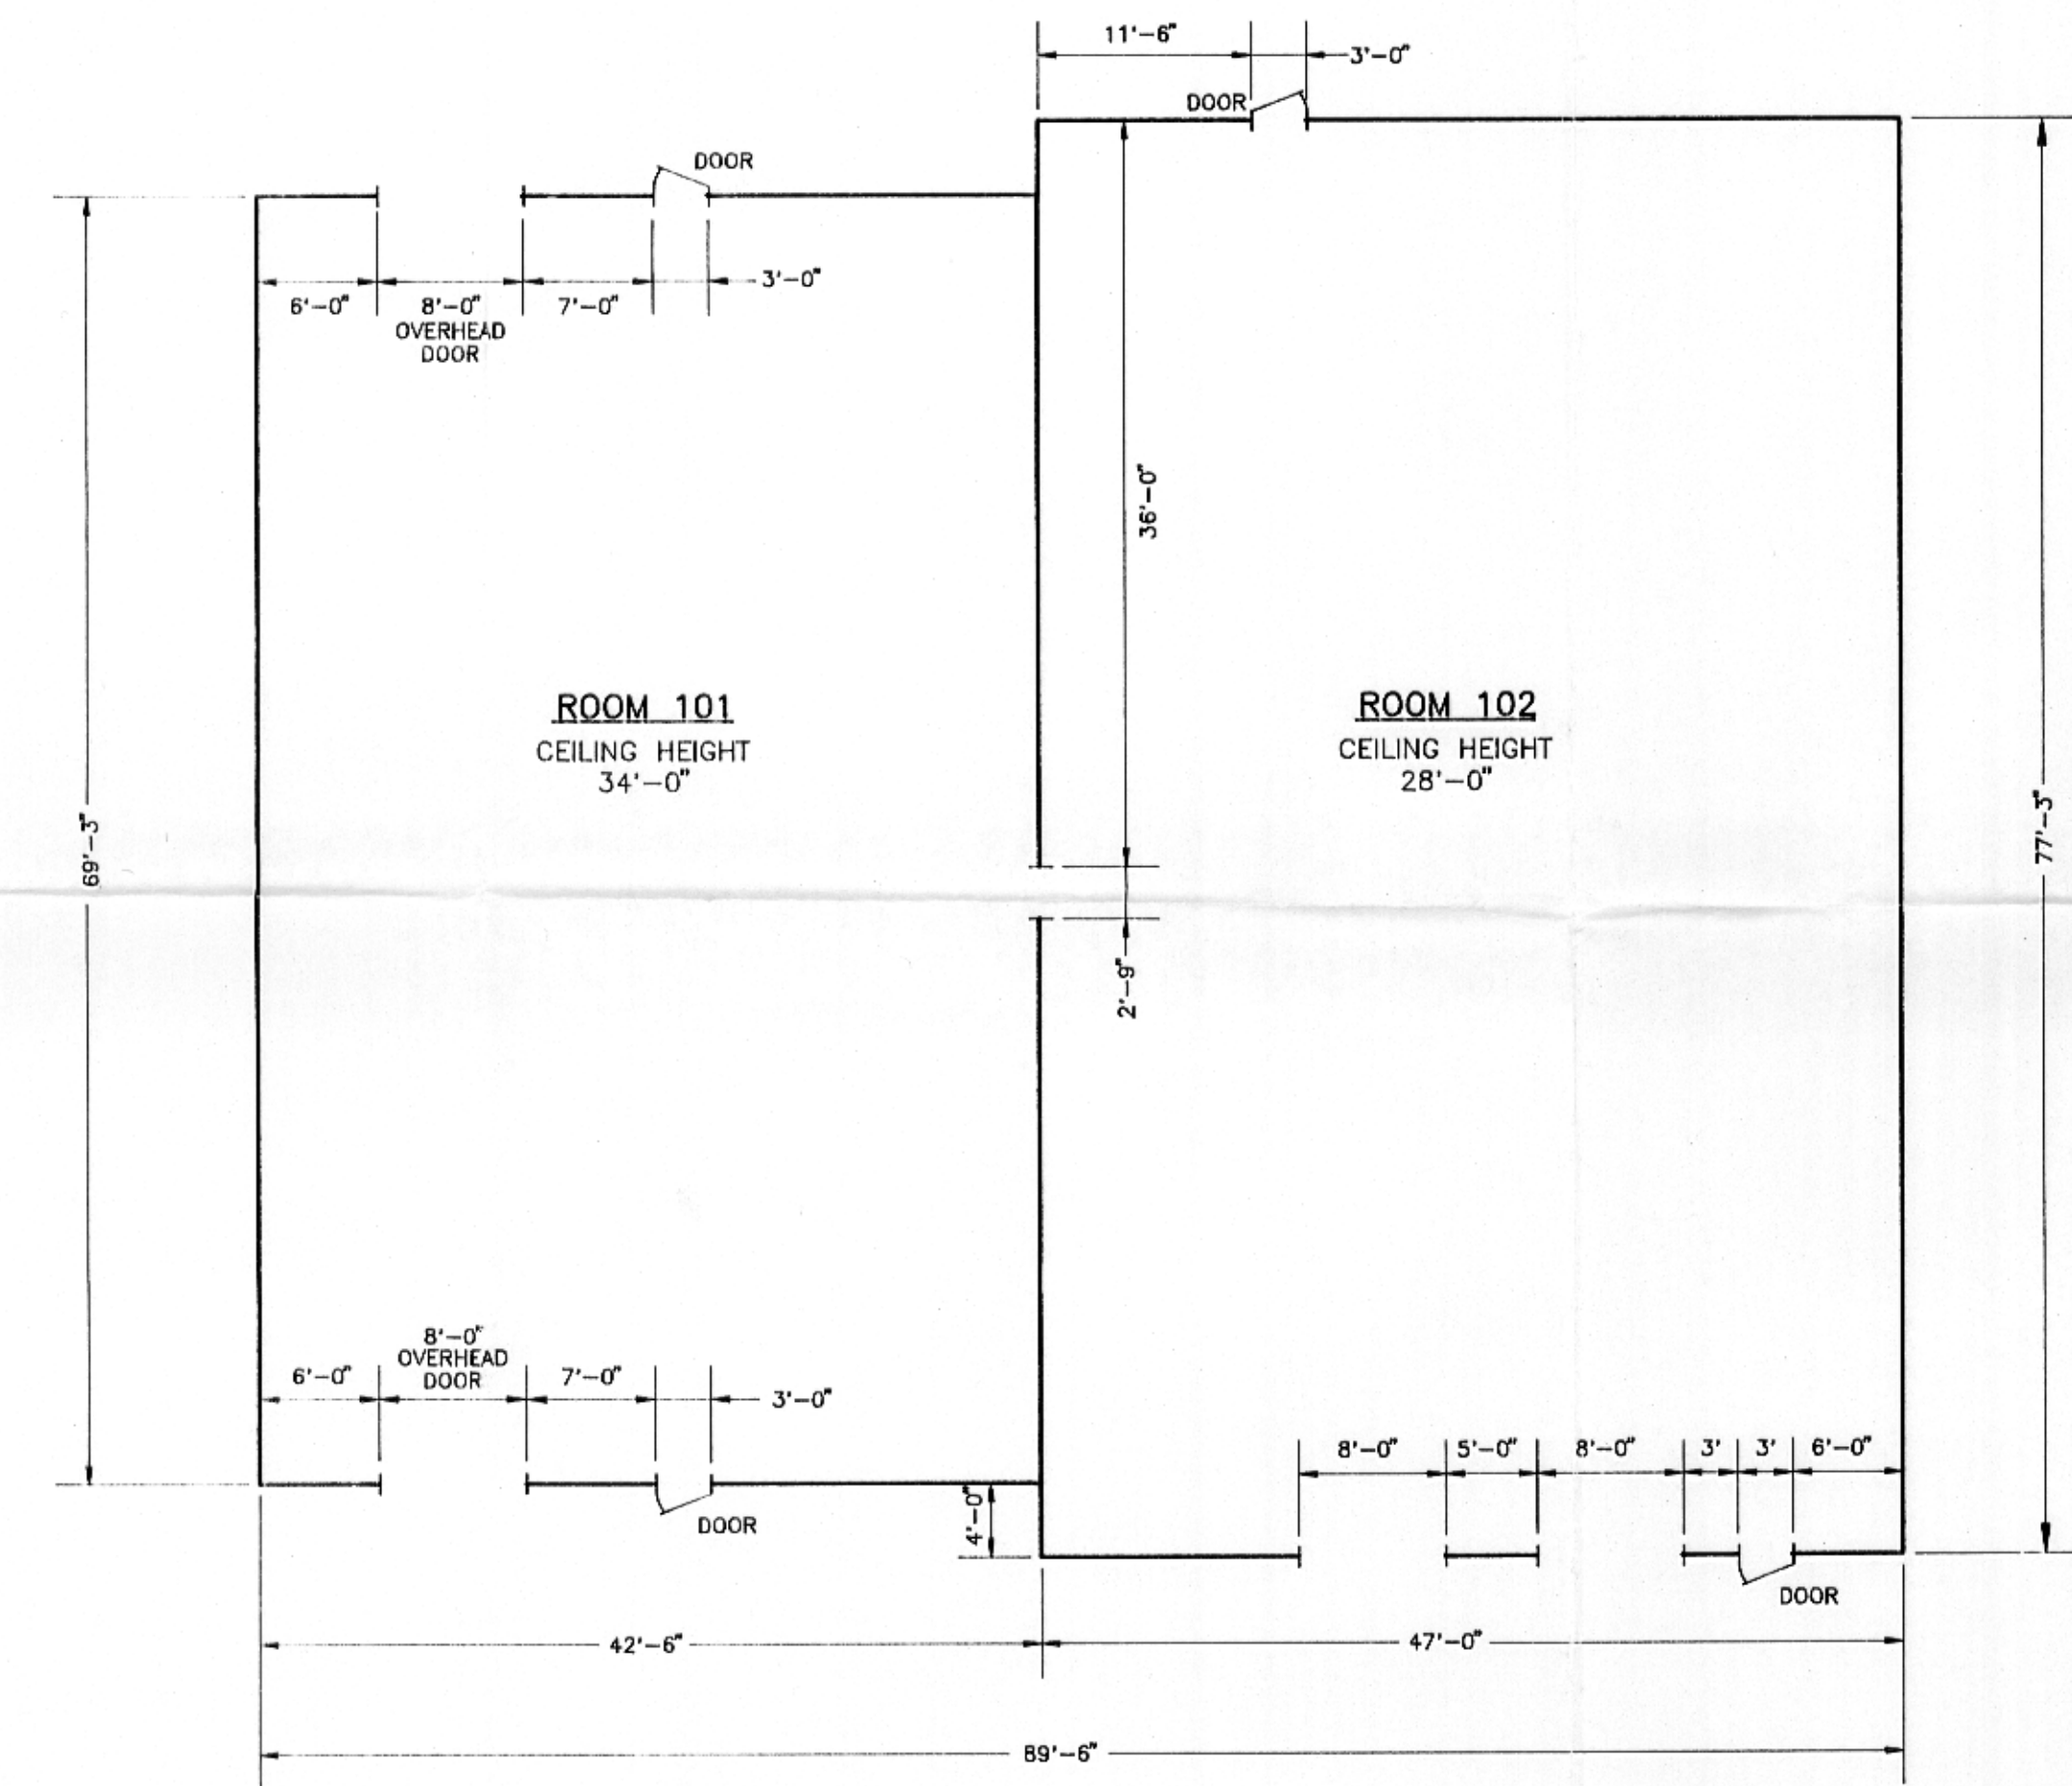

BUILDING 12
LITTLE BERTHA



 BUILDING 13
CHEM "C" BUILDING



ANSTEC
APERTURE
CARD

REVISION	DATE	DESCRIPTION
<p>FIGURE D-3 BUILDINGS 11,12 AND 13 FLOOR PLANS FANSTEEL, INC. MUSKOGEE, OKLAHOMA</p>		
<p>PREPARED FOR KIRKPATRICK & LOCKHART PITTSBURGH, PENNSYLVANIA</p>		
APPROVED	DATE	
CHECKED	DATE	
DRAWN	DATE	
DRAWING NUMBER		
0111-528		



Earth Sciences Consultants, Inc.

9402030173 D-03