



LINES

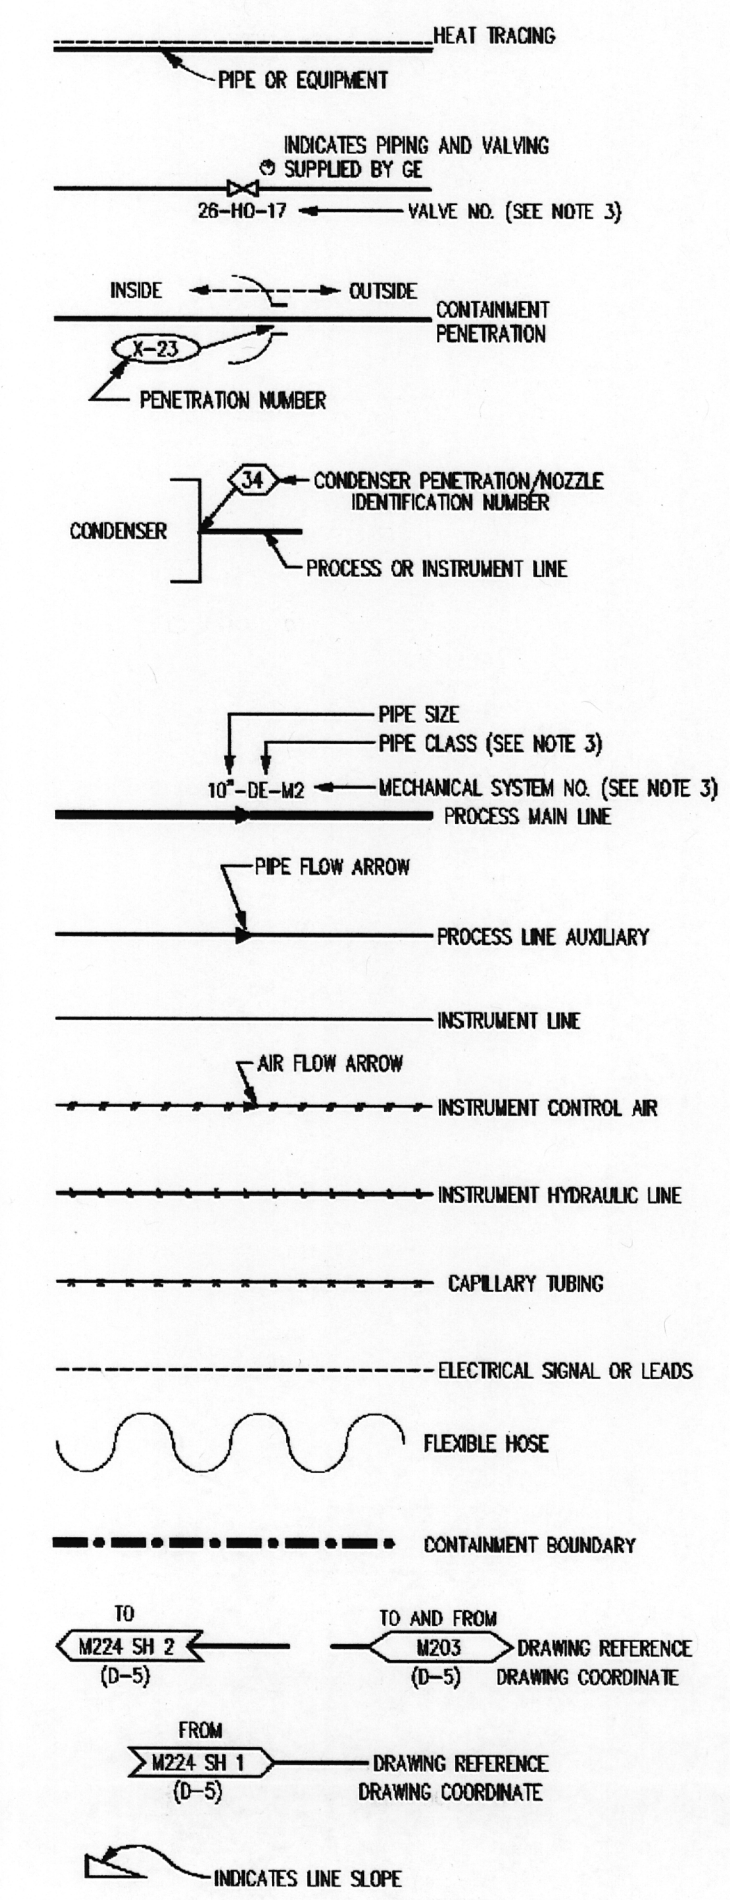

MISCELLANEOUS PIPE BOUNDARIES

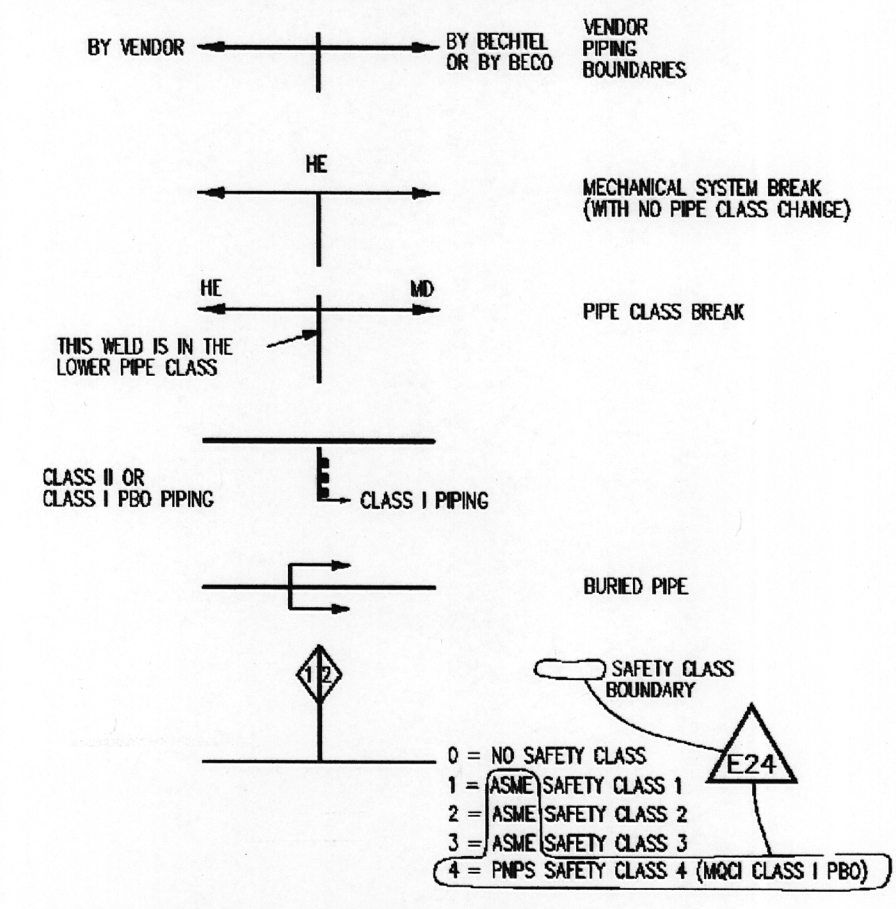


LOCAL VENT, DRAIN & TEST CONN \*\*


	VENT	DRAIN	TEST CONN
VALVE ONLY			
VALVE W/NOZZLE			
VALVE W/PIPE CAP			
VALVE CLAND LEAK-OFF**			
VALVE BODY DRAIN**			
VALVES (MANUAL)			
VALVE(S) WITH OPERATOR			

\*\* NOTES:  
1. CORRECT VALVE SYMBOL USED AS SPECIFIED.  
2. CONNECTIONS ARE SAME PIPE CLASS AS MAIN  
LINE EXCEPT WHERE NOTED.


SYMBOLS

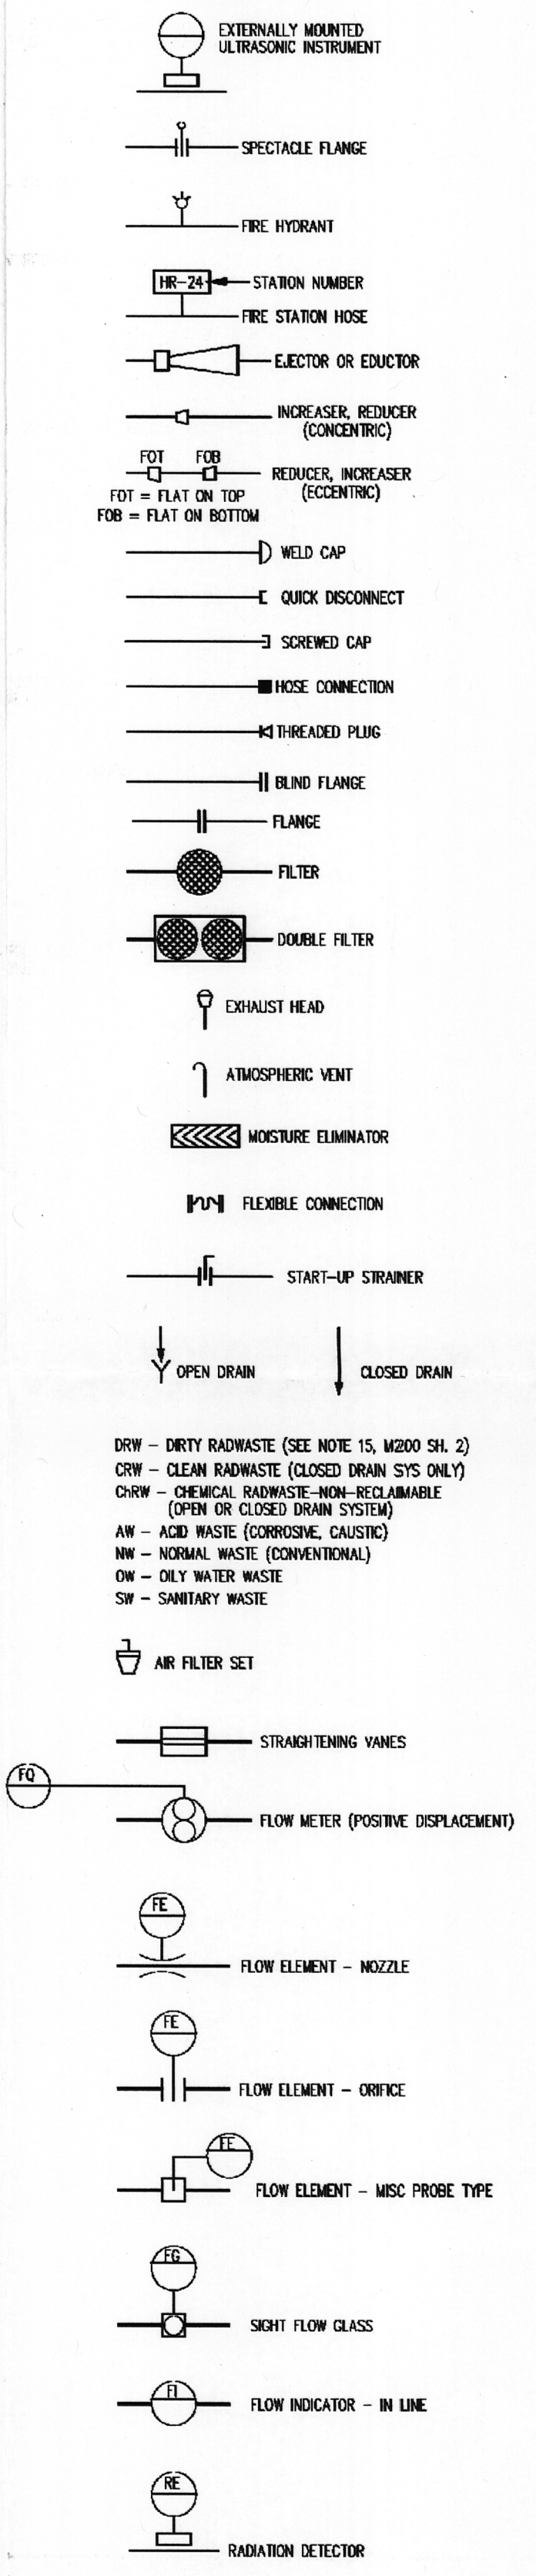


VALVES

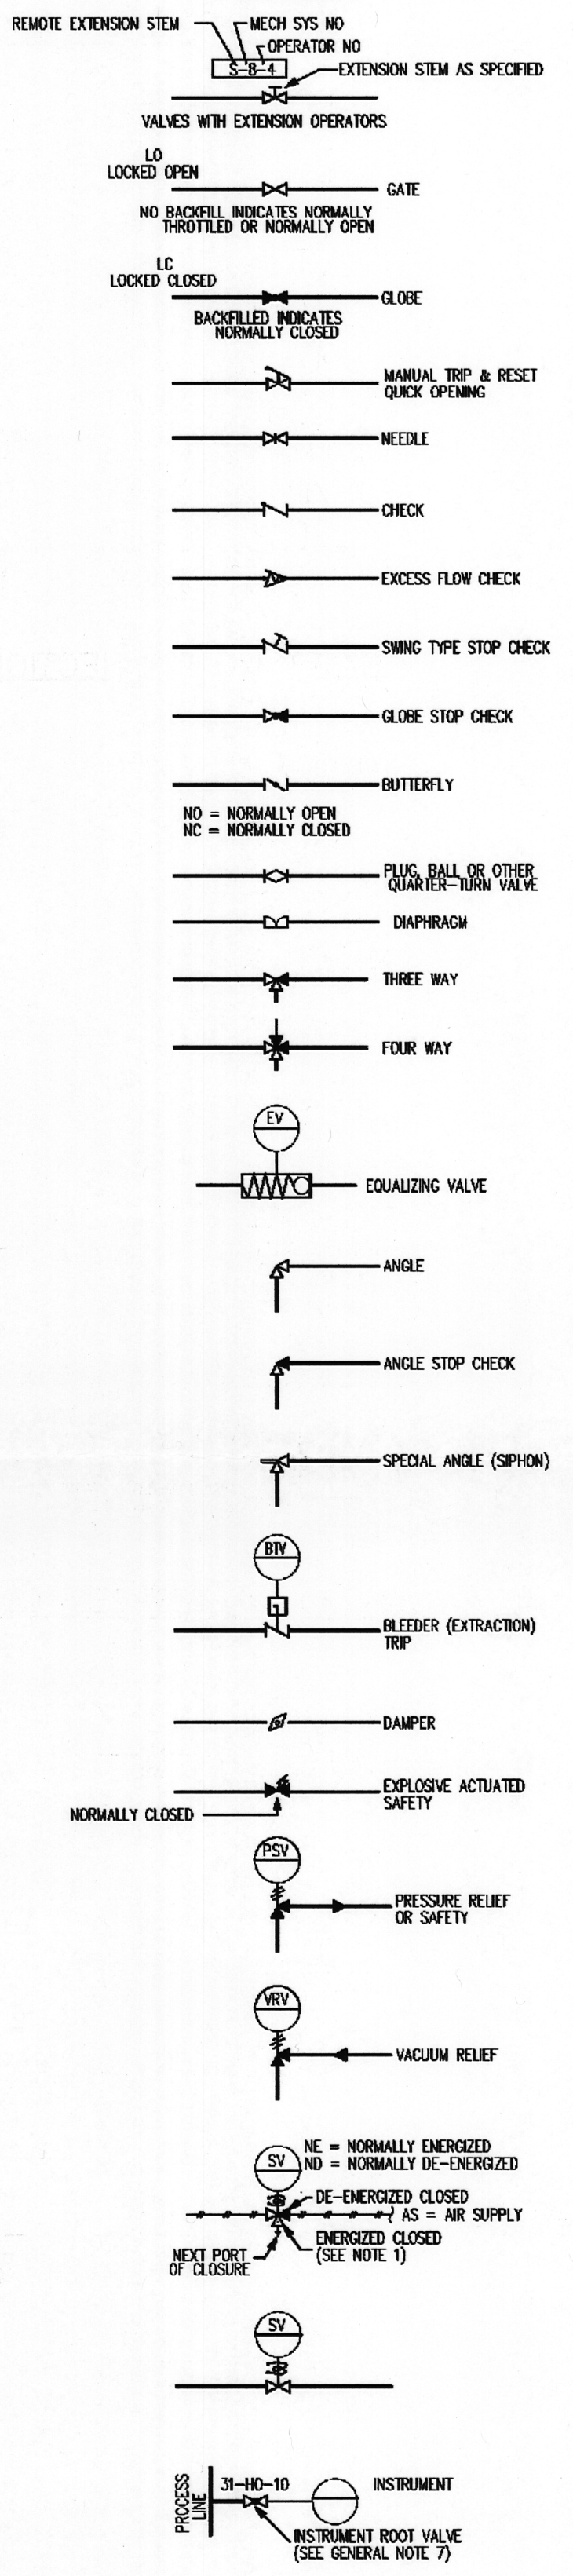


MECHANICAL AUXILIARIES

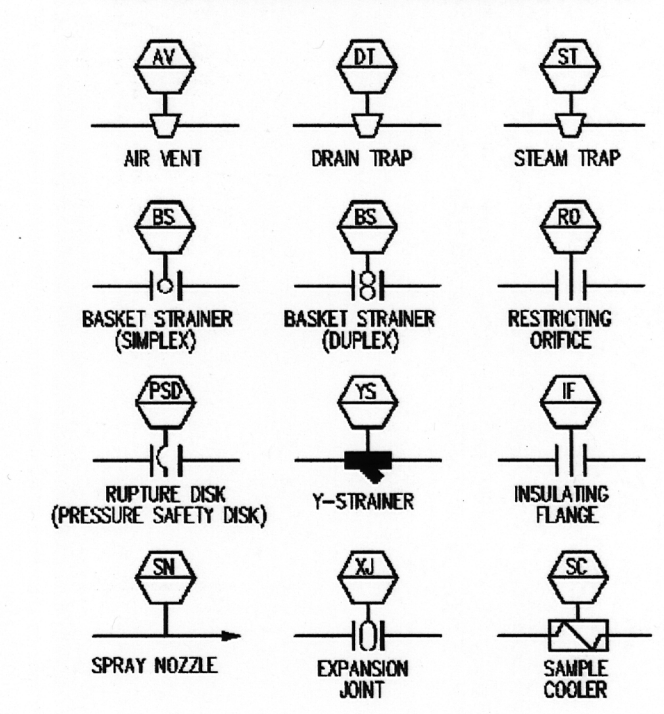


SAMPLING CONNECTIONS

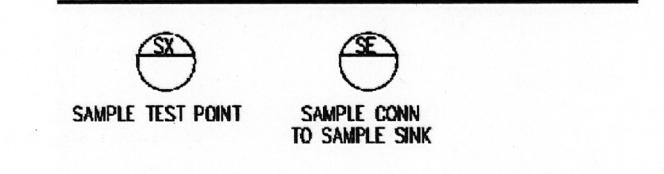


CONTROL VALVES

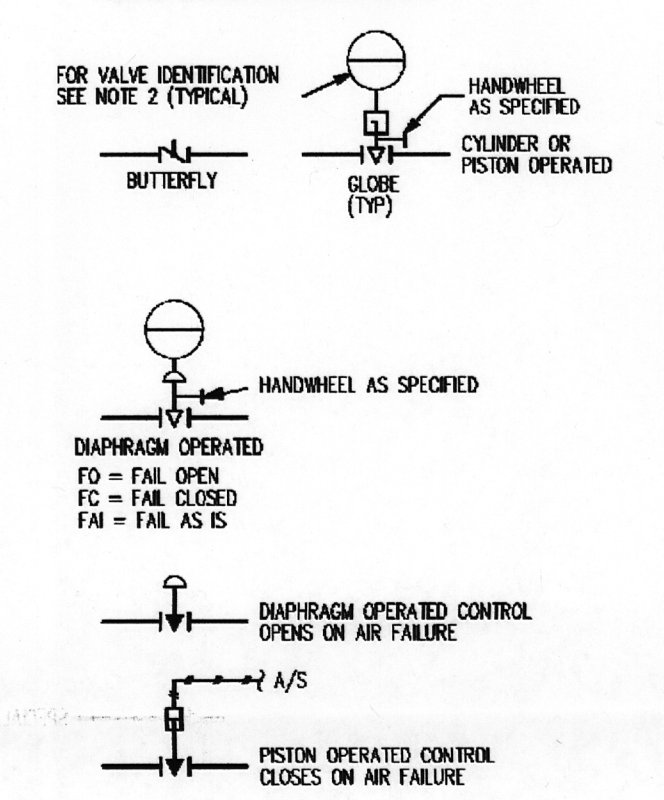


CONTROL VALVES-SELF CONTAINED

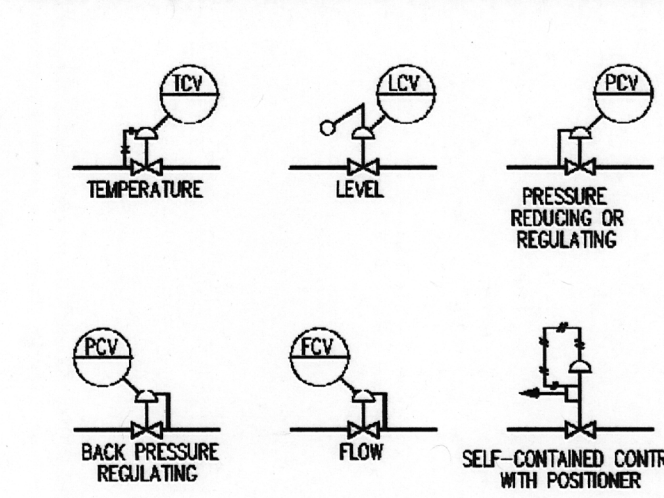

ACTUATORS

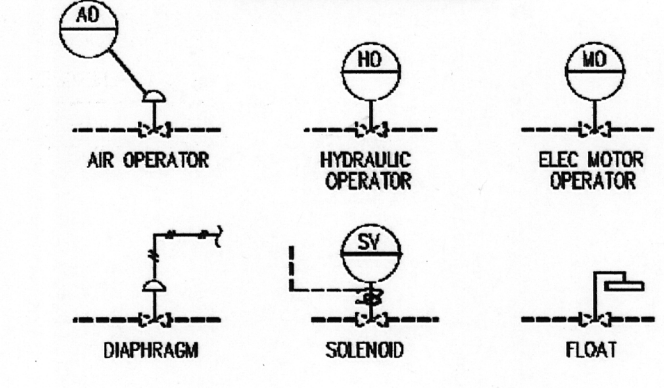

INSTRUMENTATION SYMBOLS

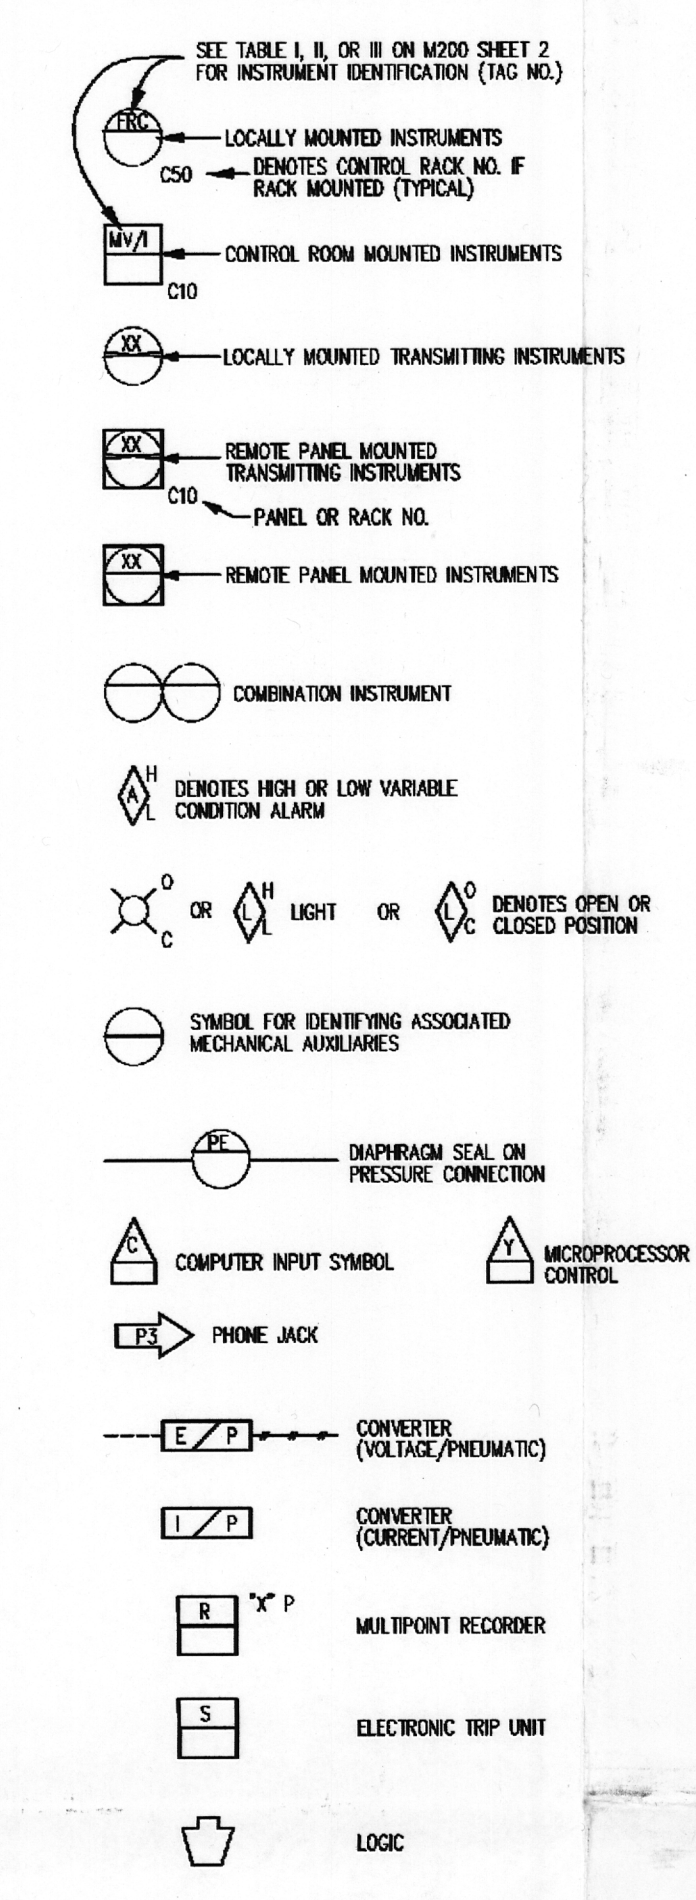

FOR NOTES & TABLES  
SEE SHEET 2

NO.	DATE	DESCRIPTION	BY	ENG	CHK	APP
REVISIONS						
LRA-M-200-SH-01-0						
CIB FILE LRA-M-200-SH-01-E24.DGN						
DRAWING FILE M200SH1-CALS_E24.CAL						
SCALE: 1/2"						
DESIGNED: RECHTEL						
DRAWN: RECHTEL						
Entergy						
Entergy Nuclear Generation Company PILGRIM STATION PLYMOUTH, MA						
P & ID LEGEND						
DRAWING NO. M200 SH 1						
REV E24						
Non Q						
41100-1903 FSAR FIGURE 1.3-2 SH 1 (REV 15)						

0	3-4-05					
NO.	DATE	DESCRIPTION	BY	ENG	CHK	APP
REVISIONS						
LRA-M-200-SH-01-0						
CIB FILE LRA-M-200-SH-01-E24.DGN						
DRAWING FILE M200SH1-CALS_E24.CAL						