



GENERAL NOTES:

1. THIS PLAN AND THE INFORMATION HEREON IS THE SOLE PROPERTY OF SVE ASSOCIATES AND IS PREPARED FOR THE SOLE BENEFIT OF ENTERGY NUCLEAR VERMONT, LLC. THIS PLAN AND ITS INFORMATION MAY NOT BE USED OR RELIED UPON BY ANY THIRD PARTY EXCEPT WITH THE WRITTEN PERMISSION OF SVE ASSOCIATES.
2. THIS PLAN SHALL BE USED FOR REPLACEMENT SEWAGE DISPOSAL SYSTEM INSTALLATION ONLY AND SHALL NOT BE USED FOR FILING IN LAND RECORDS OR CONVEYANCE. PROPERTY BOUNDARY INFORMATION, IF SHOWN, IS FOR SEWAGE DISPOSAL SYSTEM DESIGN, PERMITTING AND INSTALLATION ONLY.
3. THE CONTRACTOR SHALL INSURE THAT ALL MATERIALS AND METHODS OF CONSTRUCTION ARE IN ACCORDANCE WITH THE RULES AND REGULATIONS OF ENTERGY NUCLEAR VERMONT, LLC.
4. THIS DESIGN WAS PREPARED TO PROVIDE TREATMENT FOR DOMESTIC SANITARY WASTE ONLY. THE SYSTEM IS NOT DESIGNED FOR TOXIC OR HAZARDOUS WASTE AND THESE SUBSTANCES ARE NOT TO BE DISPOSED OF IN THIS SYSTEM.
5. THE SEWAGE DISPOSAL SYSTEM SHALL BE LAID OUT AND STAKED PRIOR TO CONSTRUCTION. ALL ITEMS SHALL BE CHECKED FOR CONFORMANCE WITH THE APPROVED PLANS. THE CONTRACTOR SHALL NOTIFY THE ENGINEER IF DISCREPANCIES ARE FOUND. THE SEWAGE DISPOSAL SYSTEM DESIGN/PLANS SHALL NOT BE MODIFIED NOR SHALL THE SPECIFIED MATERIALS OR EQUIPMENT BE SUBSTITUTED WITHOUT THE PRIOR NOTIFICATION AND CONSENT OF THE ENGINEER.
6. UNDERGROUND UTILITIES, STRUCTURES AND FACILITIES HAVE BEEN PLOTTED FROM DATA OBTAINED FROM ENTERGY NUCLEAR VERMONT, LLC; HOWEVER, THEIR LOCATIONS MUST BE CONSIDERED APPROXIMATE ONLY.
7. THE CONTRACTOR SHALL NOTIFY THE ENGINEER IN SUFFICIENT TIME TO ARRANGE FOR A REVIEW OF CONSTRUCTION OF THE SYSTEM. THE REVIEW SHALL BE ACCOMPLISHED PRIOR TO THE PLACEMENT OF ANY COVER FILL OVER ANY PORTION OF THE SYSTEM. THE CONTRACTOR SHALL COMPLETE ANY CORRECTIVE ACTIONS TO THE SYSTEM AS DIRECTED BY THE ENGINEER BEFORE THE SYSTEM WILL BE CONSIDERED COMPLETE. COPIES OF ALL REQUIRED MATERIAL CERTIFICATIONS AND AS-BUILT INFORMATION SHALL BE PROVIDED TO THE ENGINEER AT THE TIME OF THE REVIEW. THE CONTRACTOR SHALL PROVIDE THE OWNER WITH AN AS-BUILT PLAN OF THE SYSTEM, A COPY OF ALL CONSTRUCTION CERTIFICATIONS AND ANY GENERAL INFORMATION ABOUT THE SYSTEM, ITS OPERATION AND THE OWNER'S RESPONSIBILITY.


8. PROJECT WORK TO INCLUDE BUT NOT BE LIMITED TO THE FOLLOWING:
 - A. INSTALLATION OF SOUTH SEWAGE DISPOSAL REPLACEMENT FIELD (ALSO REFERRED TO AS NORTHWEST LEACHFIELD) AND FORCE MAIN.
 - B. CONNECTION OF FORCE MAIN FROM POWER UPRATE BUILDING TO SOUTH SEWAGE DISPOSAL SYSTEM PUMP STATION.
 - C. REPLACEMENT OF SOUTH SEWAGE DISPOSAL SYSTEM PUMPS, CONTROLS, SLIDE RAIS AND RELATED SUPPORT BRACKETS.
 - D. MODIFICATIONS TO FORCE MAIN PIPING SUCH THAT THE EXISTING SOUTH SEWAGE DISPOSAL AREA AND THE REPLACEMENT FIELD MAY BE OPERATED INDEPENDENTLY OR SIMULTANEOUSLY DURING PLANT REFUELING OUTAGES. DURING SIMULTANEOUS OPERATION, EACH PUMP SHALL DOSE ONLY ONE FIELD. PUMP ALTERNATION AND RUN TIMES DURING OUTAGES SHALL BE TRACKED BY CYCLE COUNTERS AND RUN TIME METERS ON NEW PUMP PANEL.
 - E. INSTALLATION OF EFFLUENT FILTER IN SOUTH SEWAGE DISPOSAL SYSTEM SEPTIC TANK.
 - F. REPLACEMENT OF ANY FIXTURES CONNECTED TO THIS SYSTEM THAT ARE NOT LOW-FLOW FIXTURES.
9. ALL ELECTRICAL WORK SHALL BE COMPLETED BY A LICENSED ELECTRICIAN IN ACCORDANCE WITH THE NATIONAL ELECTRICAL CODE.
10. BEFORE ANY EXCAVATION, CONTRACTOR SHALL CONTACT DIG-SAFE AT 1-800-225-4977 TO LOCATE UNDERGROUND UTILITIES.

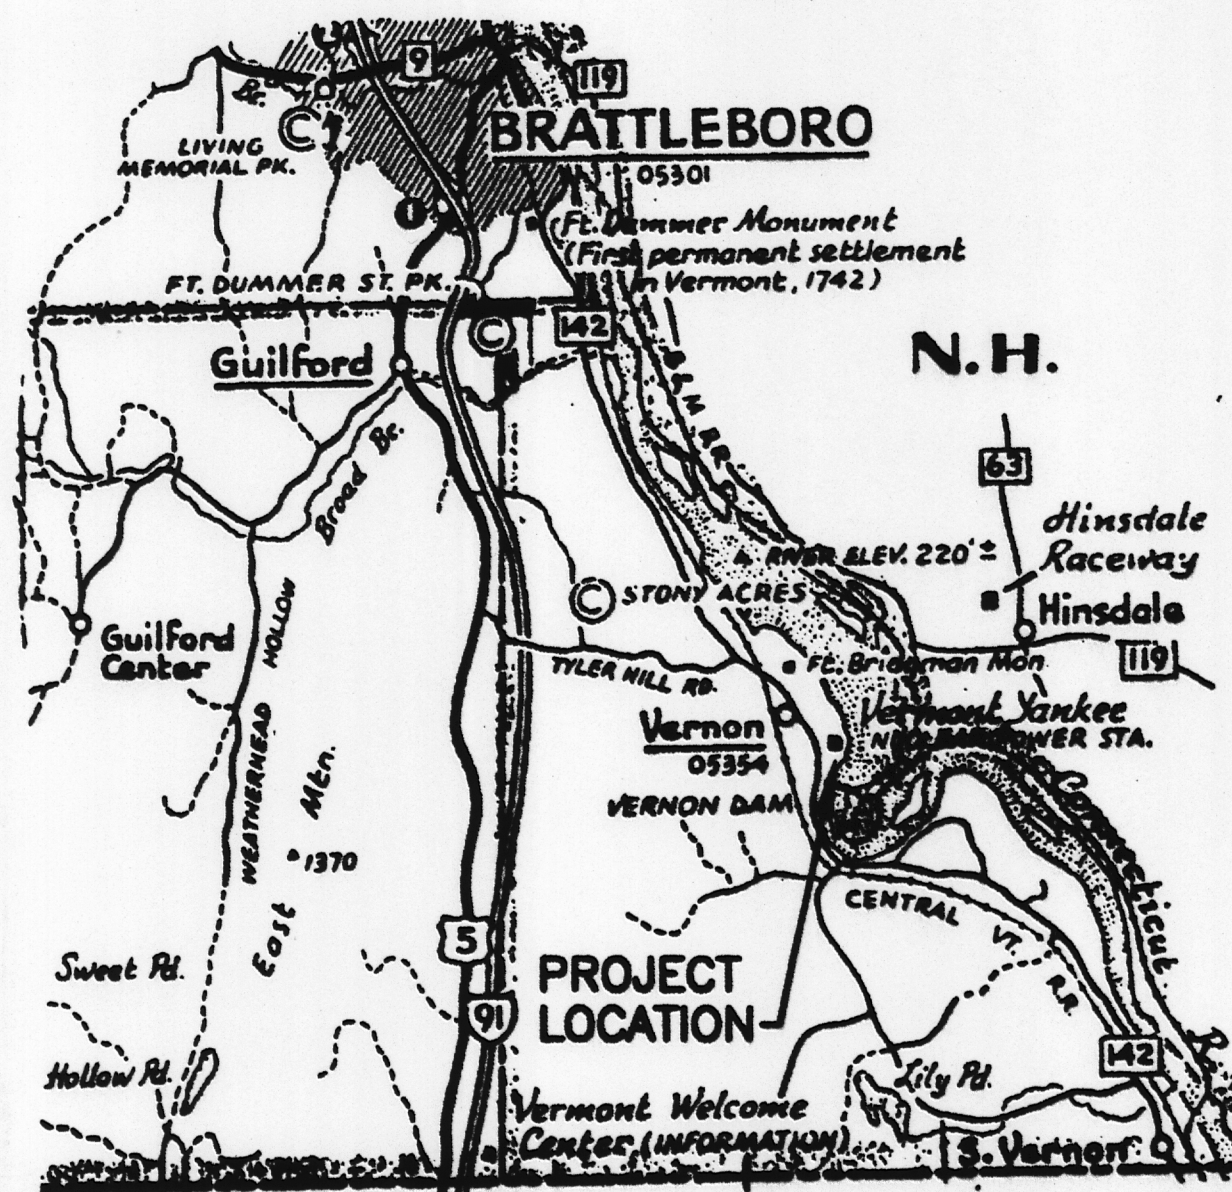

LOCATION MAP
NOT TO SCALE

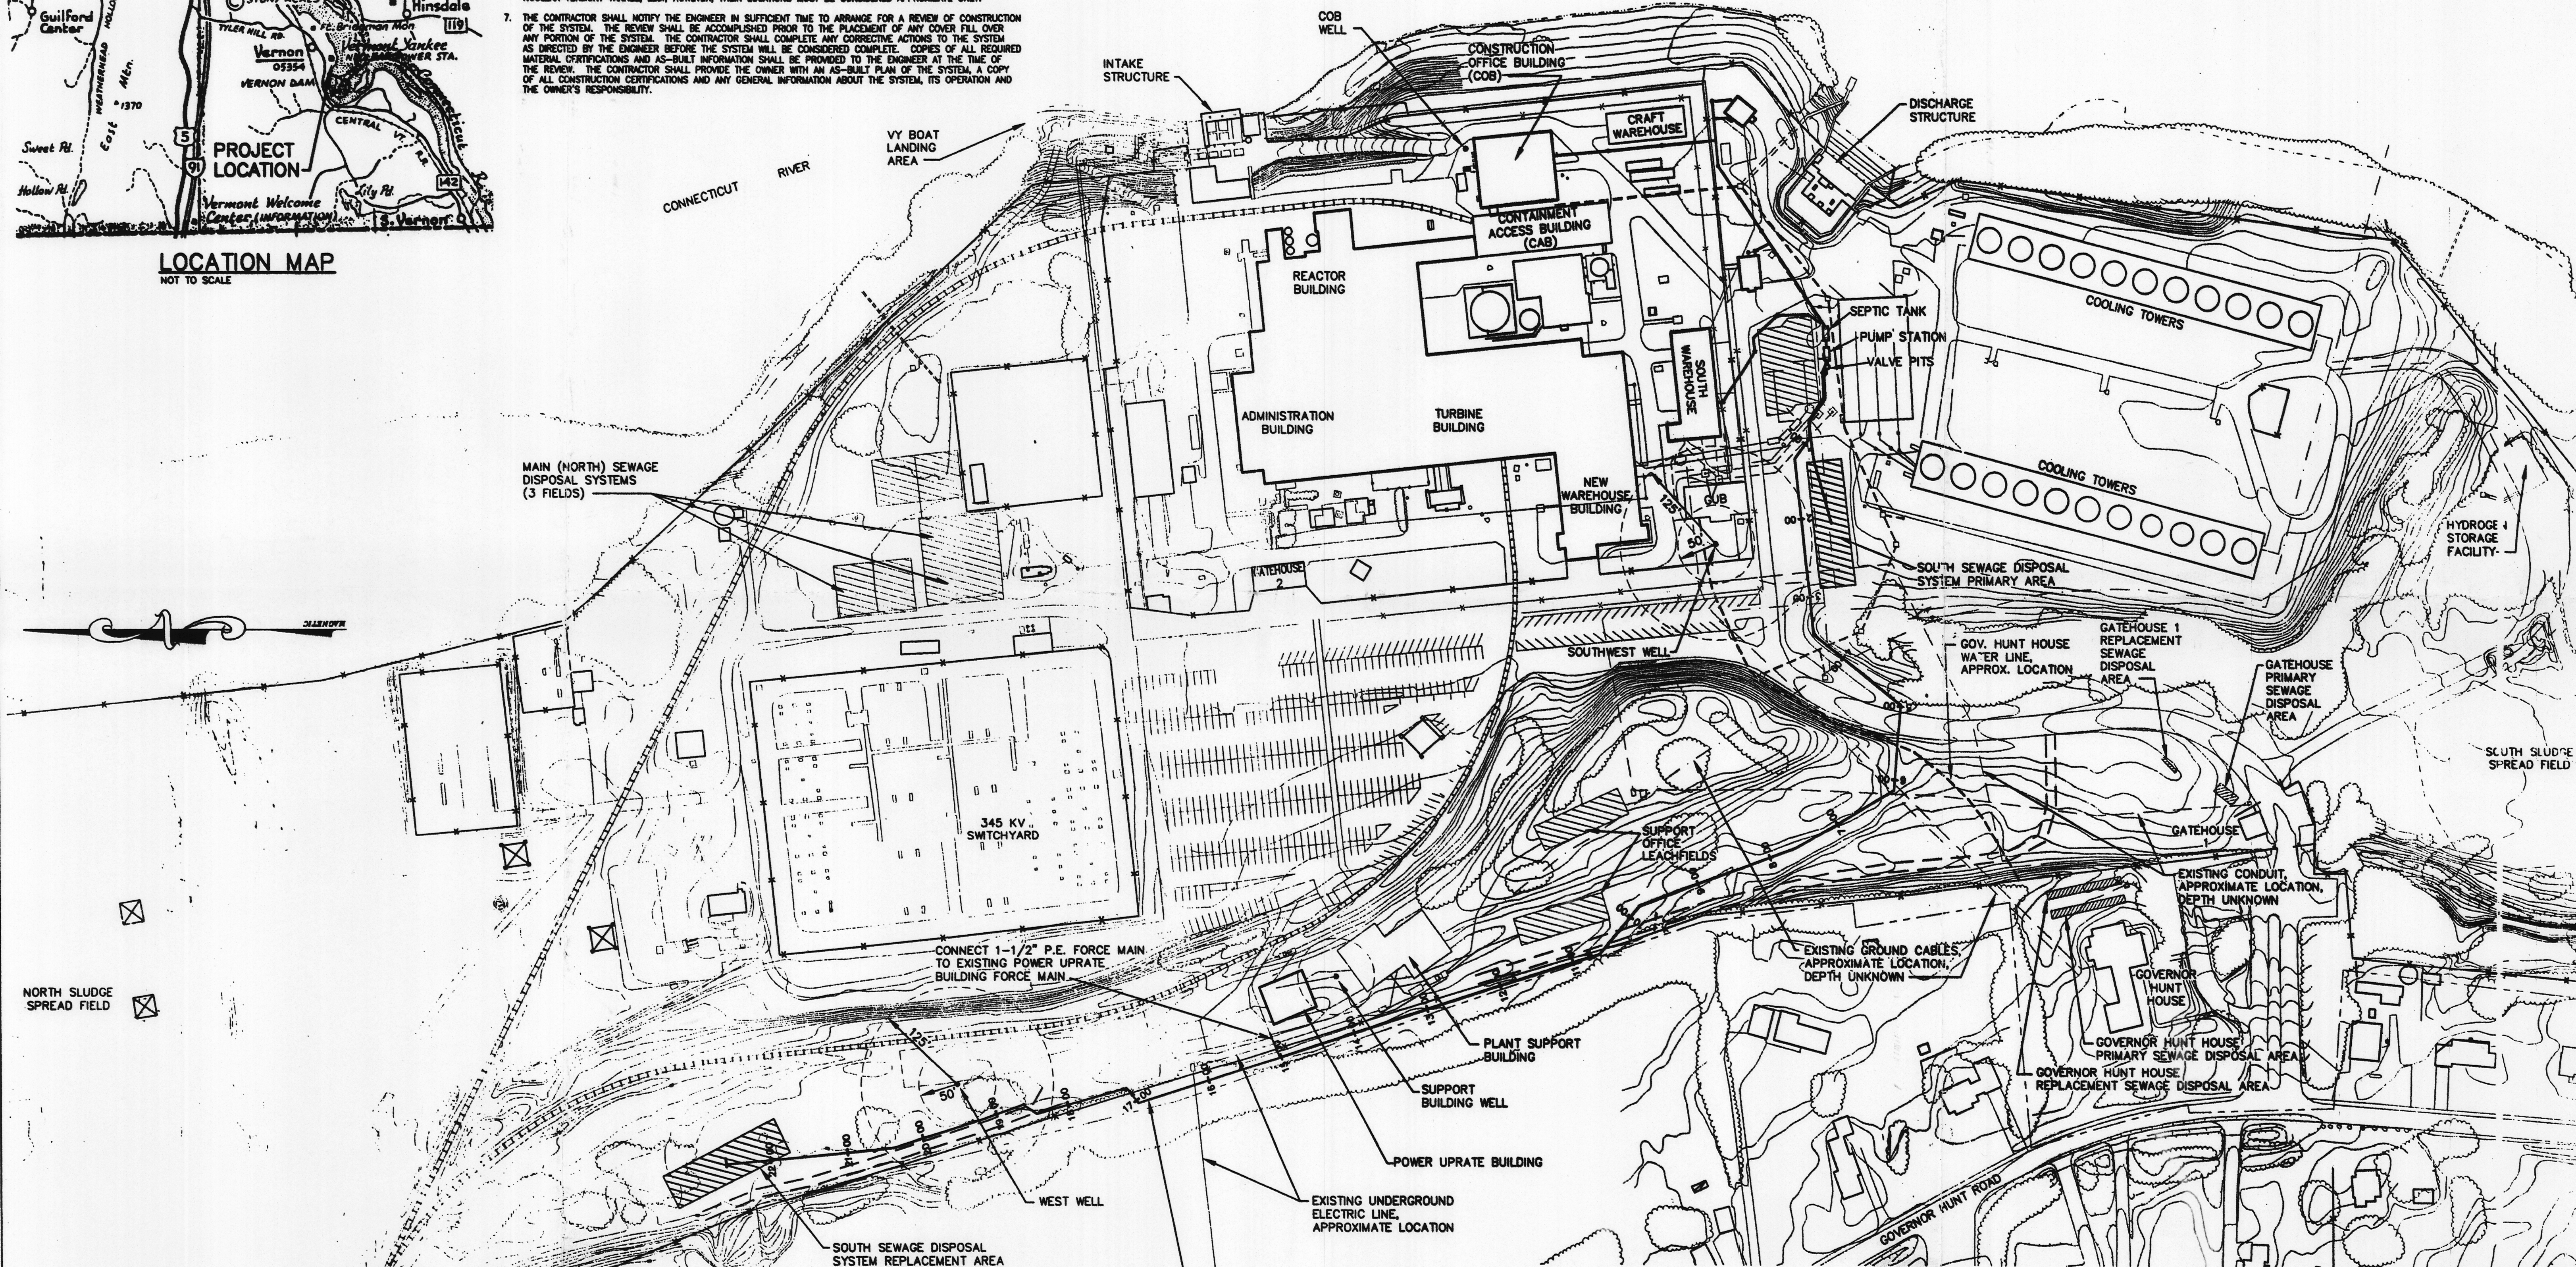

NORTH SLUDGE SPREAD FIELD

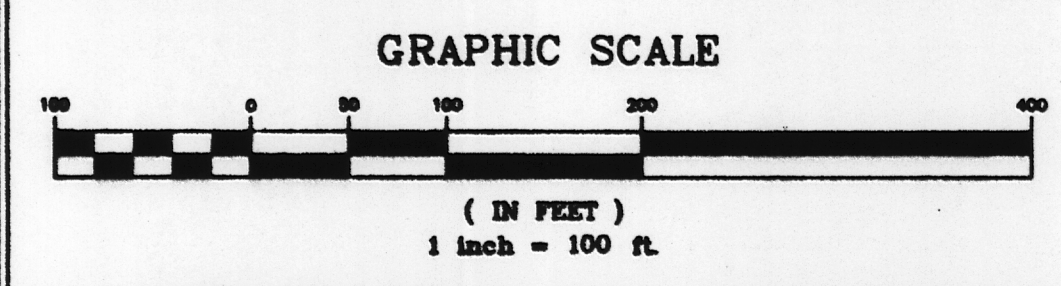

Project: B4000B ENTERGY VYNPC\dwg\B4000C01.dwg 4/14/2003 9:23:33 AM EST

VY DRAWING NO. 5920-13021

SITE PLAN FOR NORTHWEST LEACHFIELD & FORCE MAIN FROM (COB) SOUTH SEWAGE DISPOSAL SYSTEM ENTERGY NUCLEAR, VERMONT YANKEE, LLC. VERNON, VERMONT				DATE PLAN: 2/11/03 DATE SURVEY: N/A DESIGNED BY: JEG DRAWN BY: JJS CHECKED BY: FRB SCALE: 1"=130'	PROJ. NO.: B4000C CAD NO.: B4000C01 SHEET 1 OF 5
SVE Associates Engineering Surveying Landscape Architecture Planning P.O. Box 1818, Brattleboro, VT 05302-1818 Phone: (802) 257-0581 Fax: (802) 257-0721 website: www.sveassoc.com					