


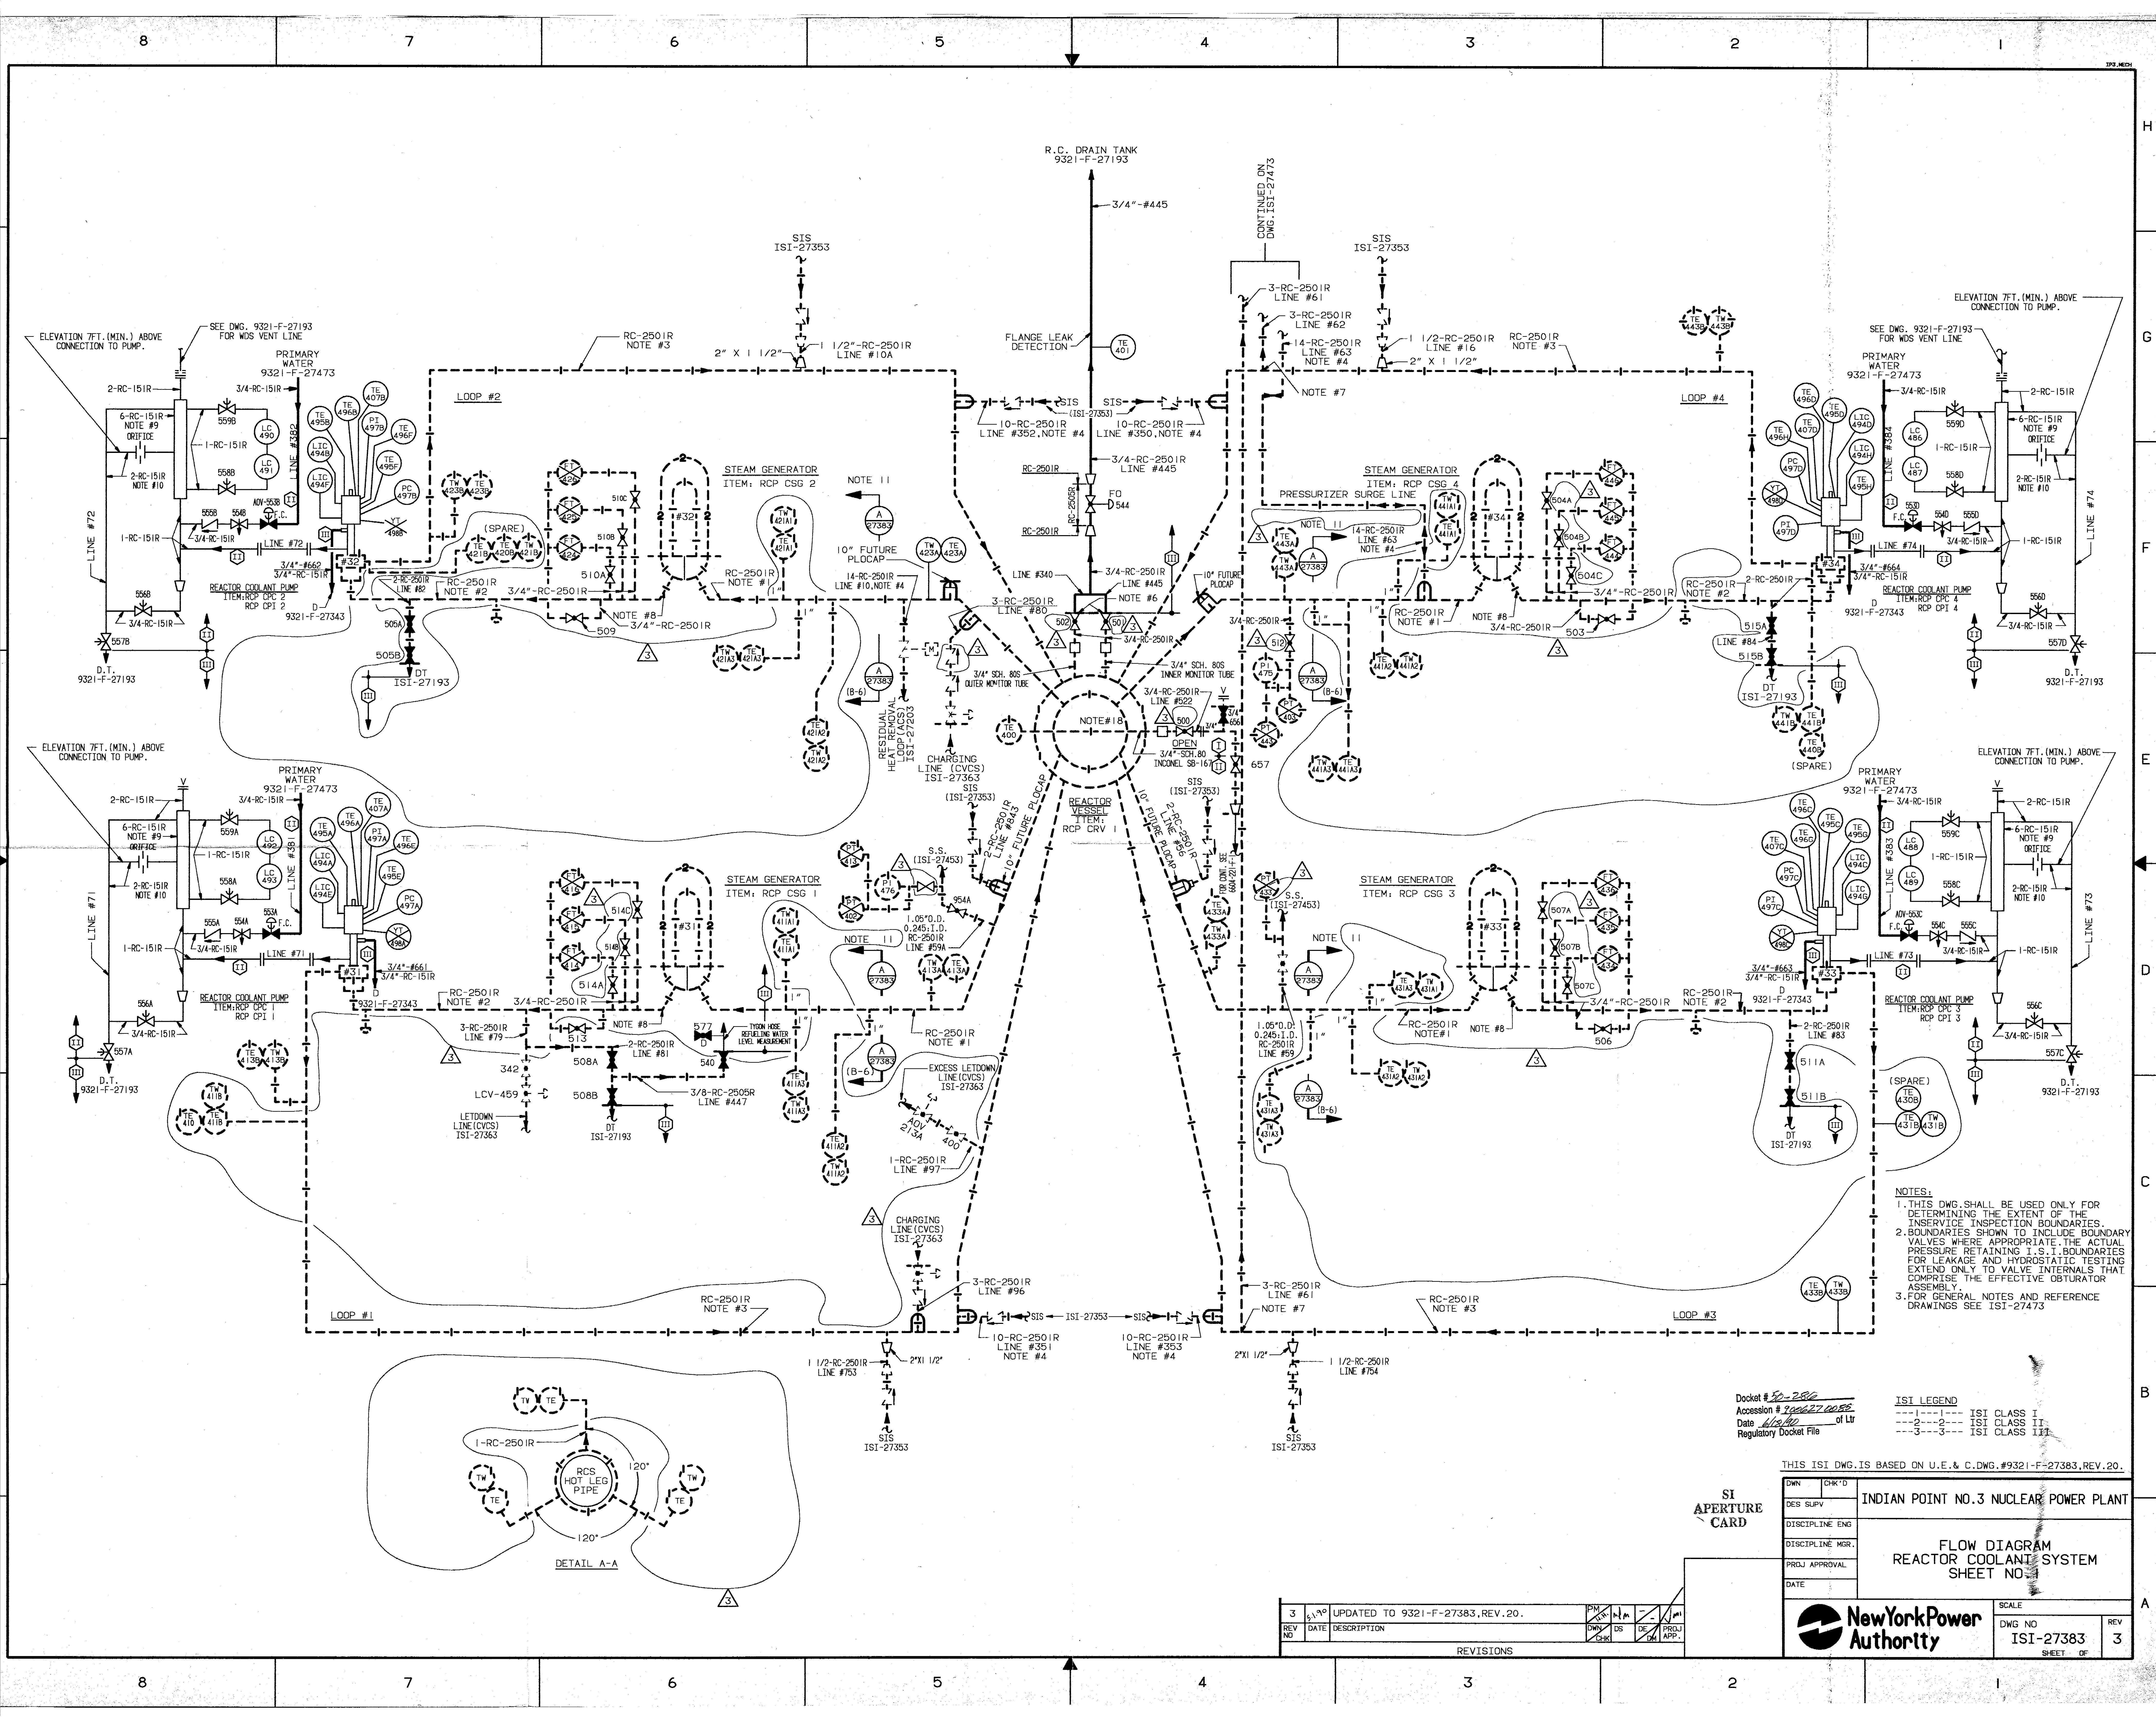

NOTES:
1. THIS DWG. SHALL BE USED ONLY FOR DETERMINING THE EXTENT OF THE INSERVICE INSPECTION BOUNDARIES.
2. BOUNDARIES SHOWN TO INCLUDE BOUNDARY VALVES WHERE APPROPRIATE. THE ACTUAL PRESSURE RETAINING I.S.I. BOUNDARIES FOR LEAKAGE AND HYDROSTATIC TESTING EXTEND ONLY TO VALVE INTERNALS THAT COMPRISE THE EFFECTIVE OBSTURATOR ASSEMBLY.
3. FOR GENERAL NOTES AND REFERENCE DRAWINGS SEE ISI-27473

Docket # 20-286
Accession # 200627 0055
Date 4/29/02 of 11
Regulatory Docket File

ISI LEGEND
---1---1--- ISI CLASS I
---2---2--- ISI CLASS II
---3---3--- ISI CLASS III

THIS ISI DWG. IS BASED ON U.E. & C.DWG. #9321-F-27383, REV. 20.

DWN		CHK'D	INDIAN POINT NO. 3 NUCLEAR POWER PLANT	
DES SUPV				
DISCIPLINE ENG				
DISCIPLINE MGR.				
PRJ APPR				
DATE				
REV NO		3		
DATE		4/29/02		
DESCRIPTION		UPDATED TO 9321-F-27383, REV. 20.		
REVISIONS				
DWN		CHK	DS	DE
APP		DM	DM	DM
SCALE		DWG NO		
REV		3		
SHEET OF		3		

New York Power Authority