
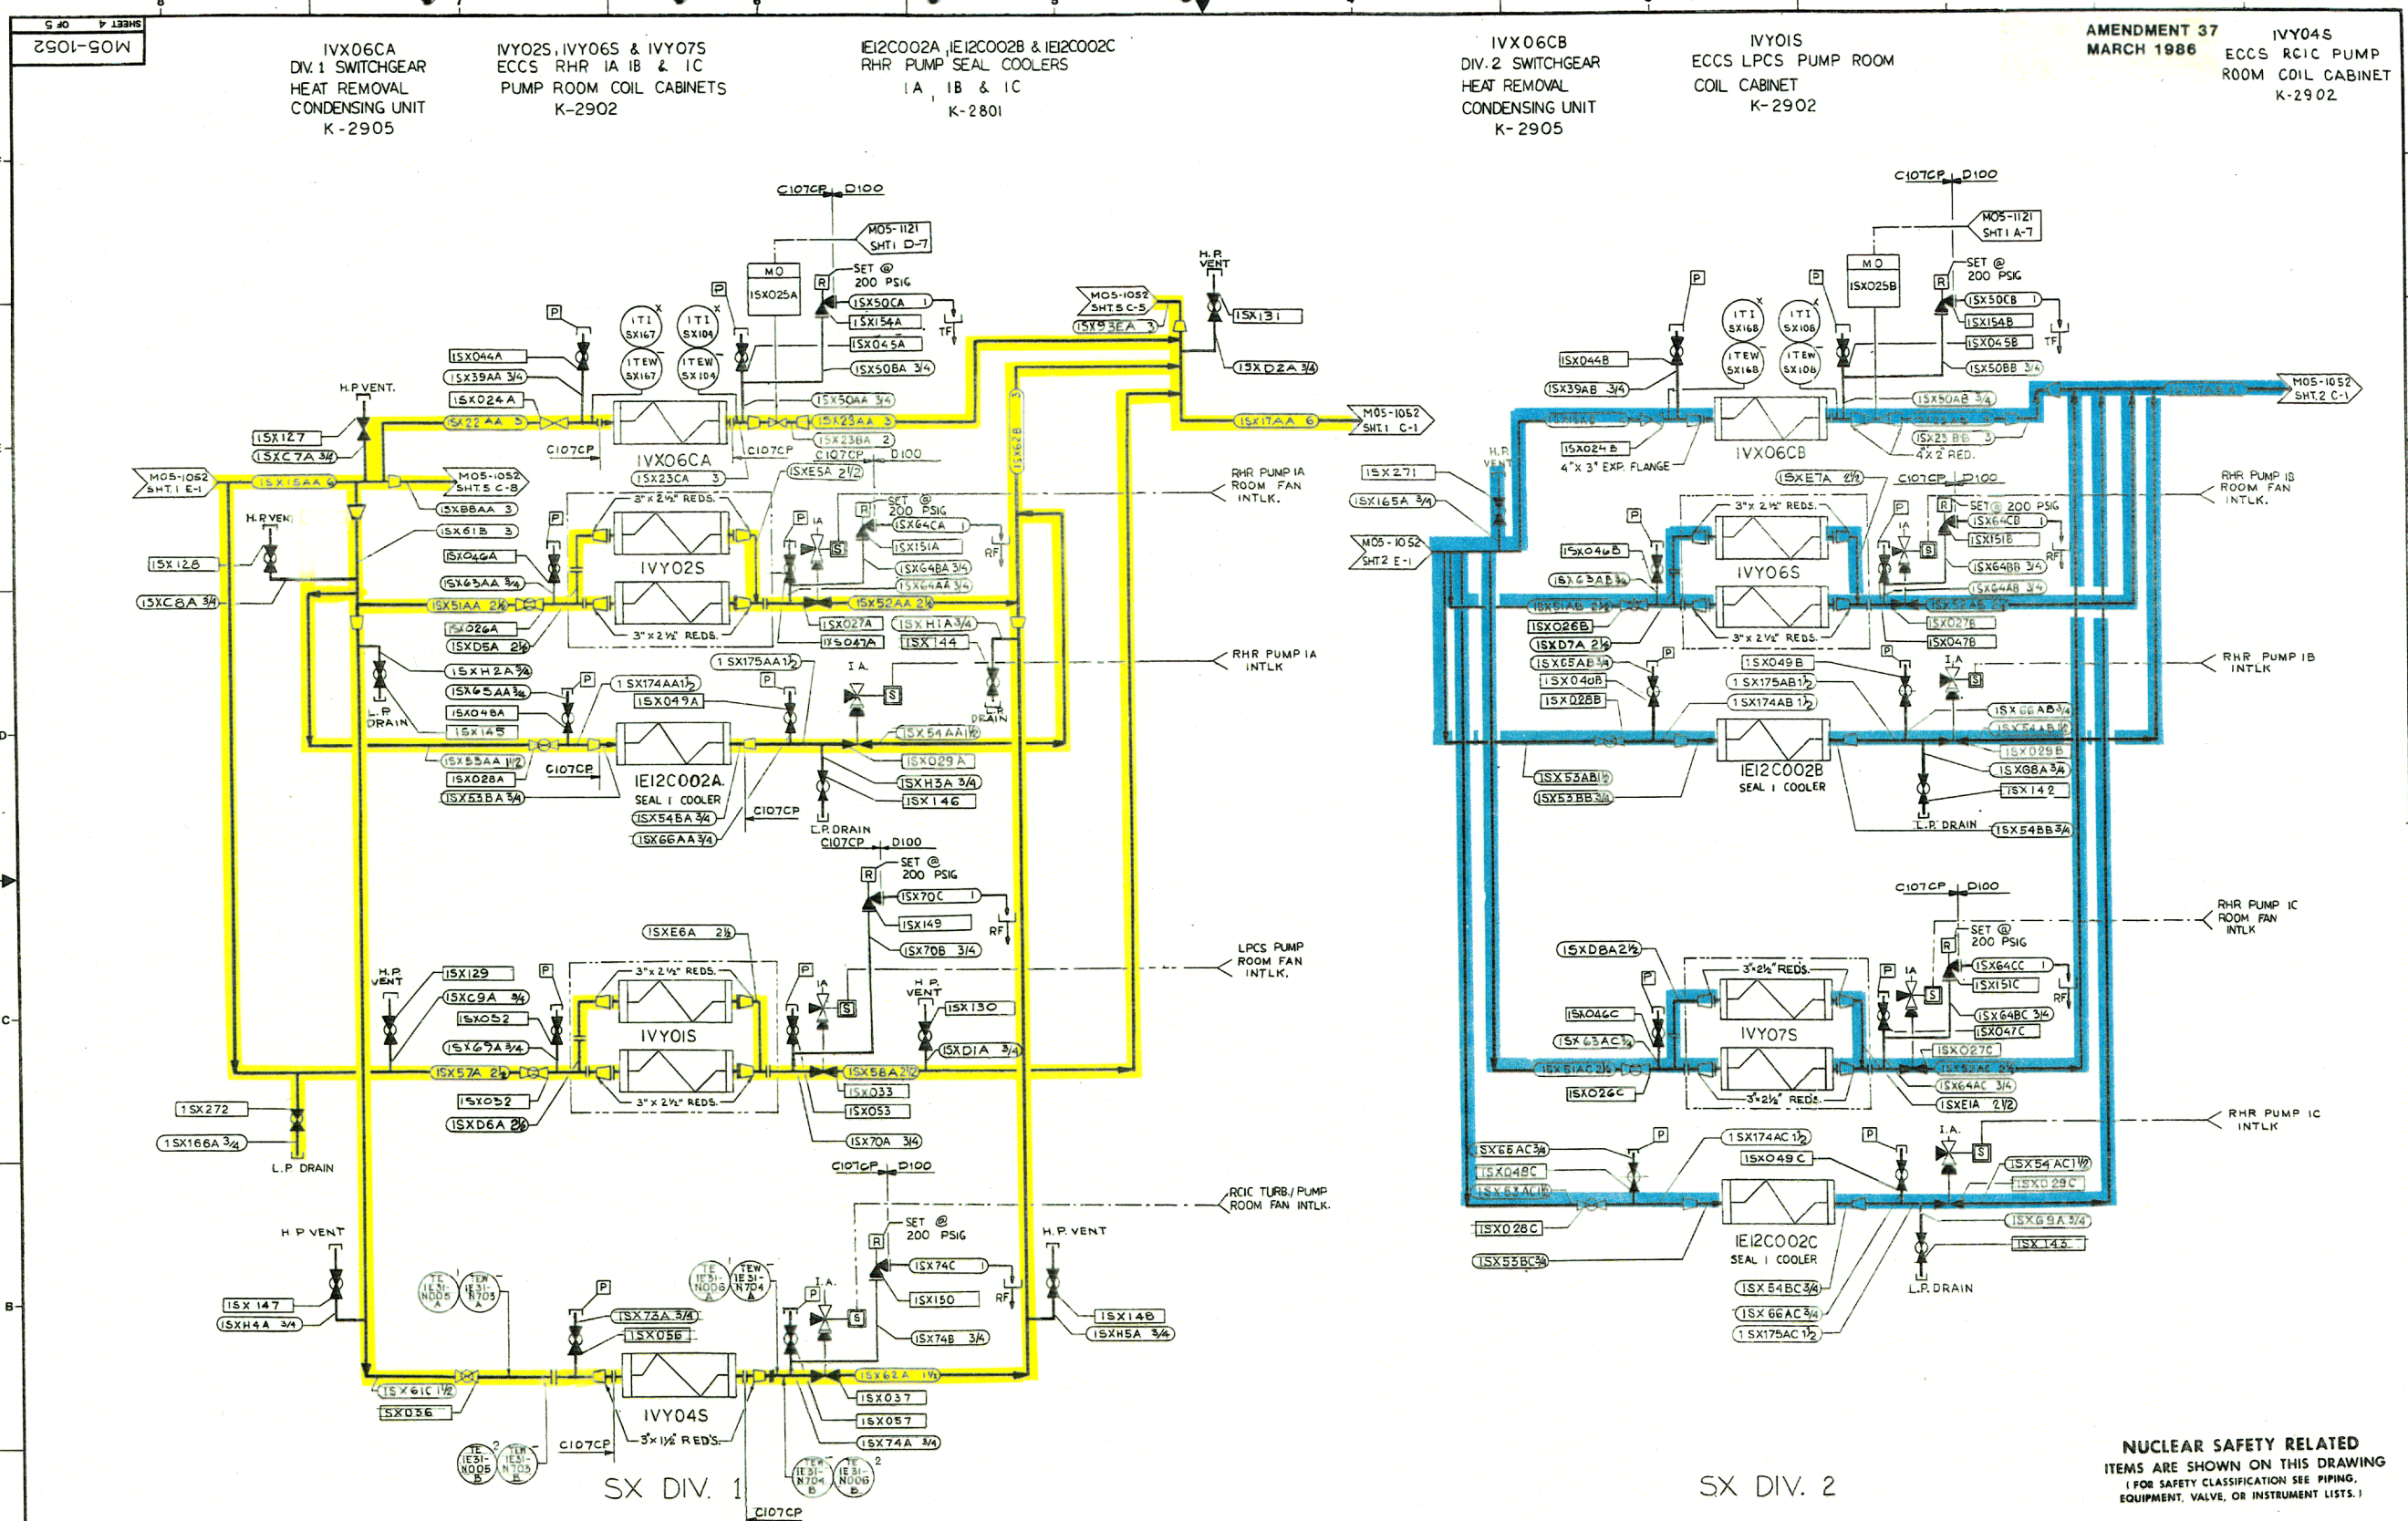


AMENDMENT 37
MARCH 1986IVY04S
ECCS RHR PUMP
ROOM COIL CABINET
K-2902

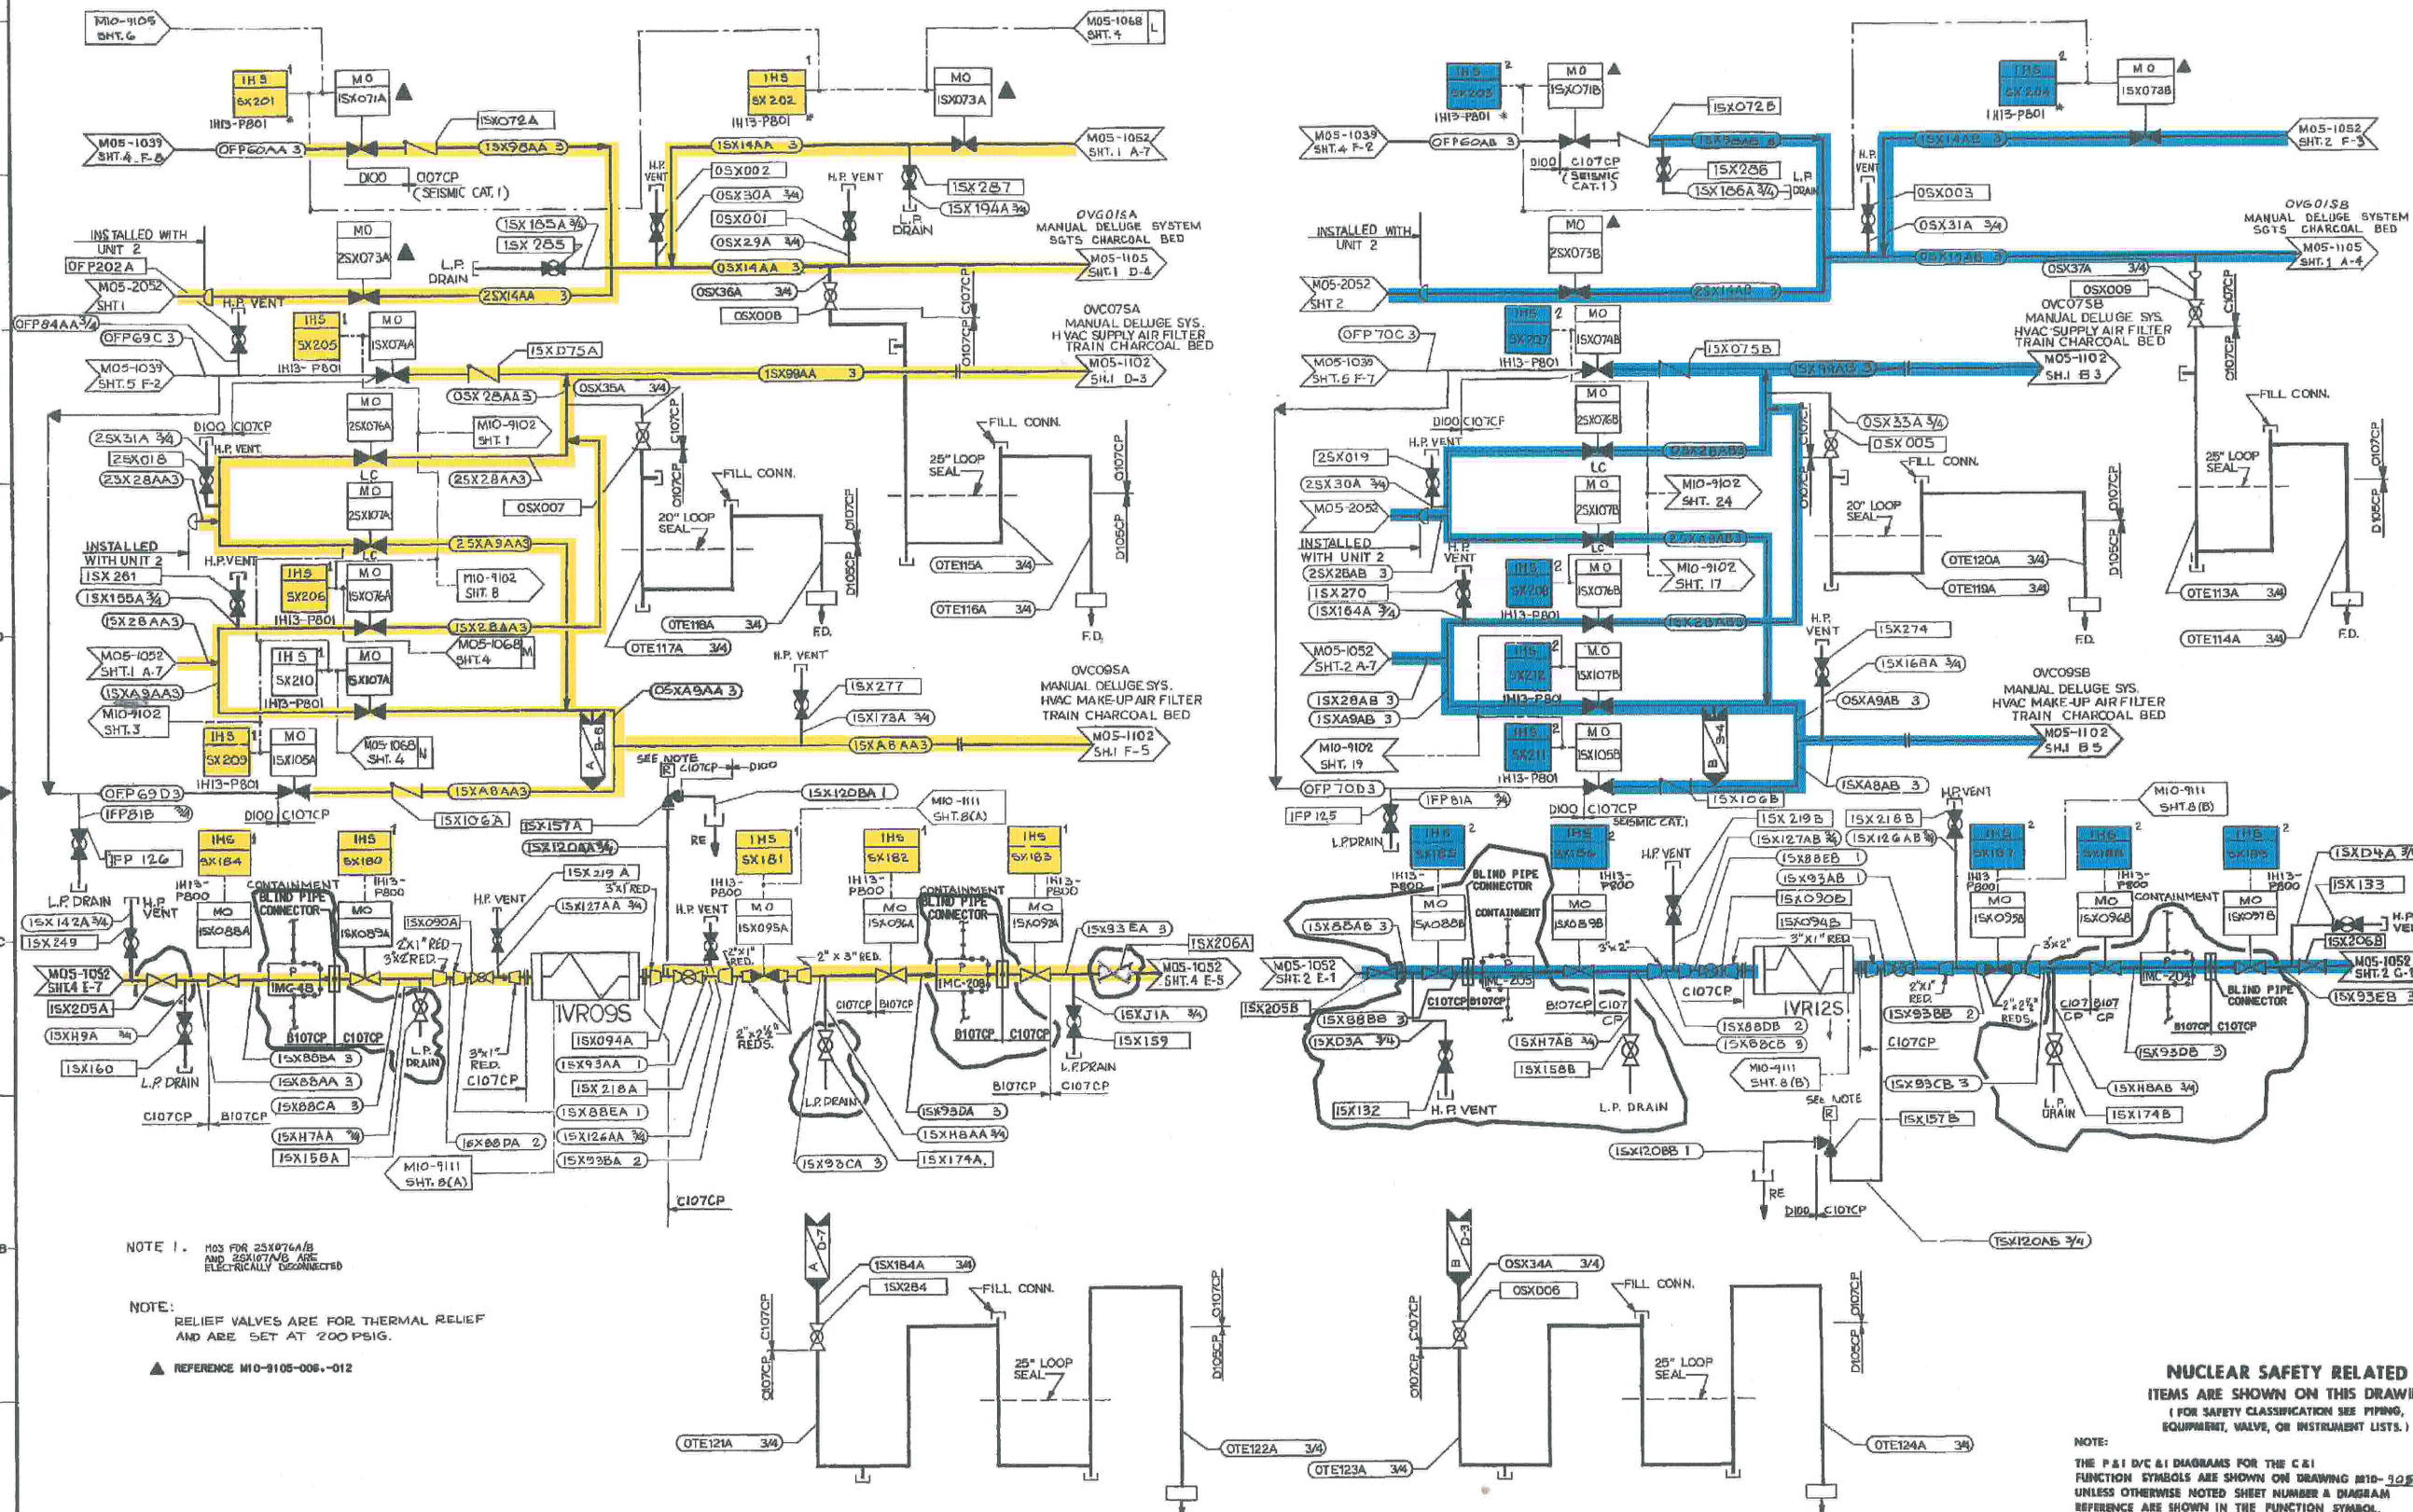


NUCLEAR SAFETY RELATED
ITEMS ARE SHOWN ON THIS DRAWING
(FOR SAFETY CLASSIFICATION SEE PIPING,
EQUIPMENT, VALVE, OR INSTRUMENT LISTS.)

NOTE:
THE P&ID/C&I DIAGRAMS FOR THE C&I
FUNCTION SYMBOLS ARE SHOWN ON DRAWING M10-9052
UNLESS OTHERWISE NOTED SHEET NUMBER & DIAGRAM
REFERENCE ARE SHOWN IN THE FUNCTION SYMBOL.

CLINTON POWER STATION
UPDATED SAFETY ANALYSIS REPORT

FIGURE 3-6-1
DIVISIONAL SEPARATION AND
HIGH-ENERGY P&ID'S-
SHUTDOWN SERVICE WATER

SHEET 51 OF 111

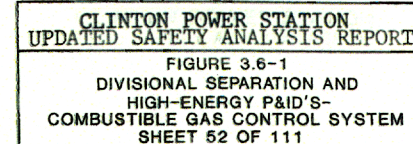

WEI
WAI

ITEMS ARE SHOWN ON THIS DRAWING
(FOR SAFETY CLASSIFICATION SEE PIPING,
EQUIPMENT, VALVE, OR INSTRUMENT LISTS.)

NOTE:

THE P & I D/C & I DIAGRAMS FOR THE C & I
FUNCTION SYMBOLS ARE SHOWN ON DRAWING M10-9069
UNLESS OTHERWISE NOTED. SHEET NUMBER & DIAGRAM
REFERENCE ARE SHOWN IN THE FUNCTION SYMBOL.

CLINTON POWER STATION
UPDATED SAFETY ANALYSIS REPORT


FIGURE 3.6-1
DIVISIONAL SEPARATION AND
HIGH-ENERGY P&ID'S-
SUPPRESSION POOL MAKEUP
SHEET 53 OF 111

IE32B001A, IE32B001E,
IE32B001J & IE32B001N
MSIV HEATERS
K-2801

IE32C001
BLOWER
K-2801

IE32C002B & IE32C002F
BLOWERS
K-2801

REVISION 8
DECEMBER 1997

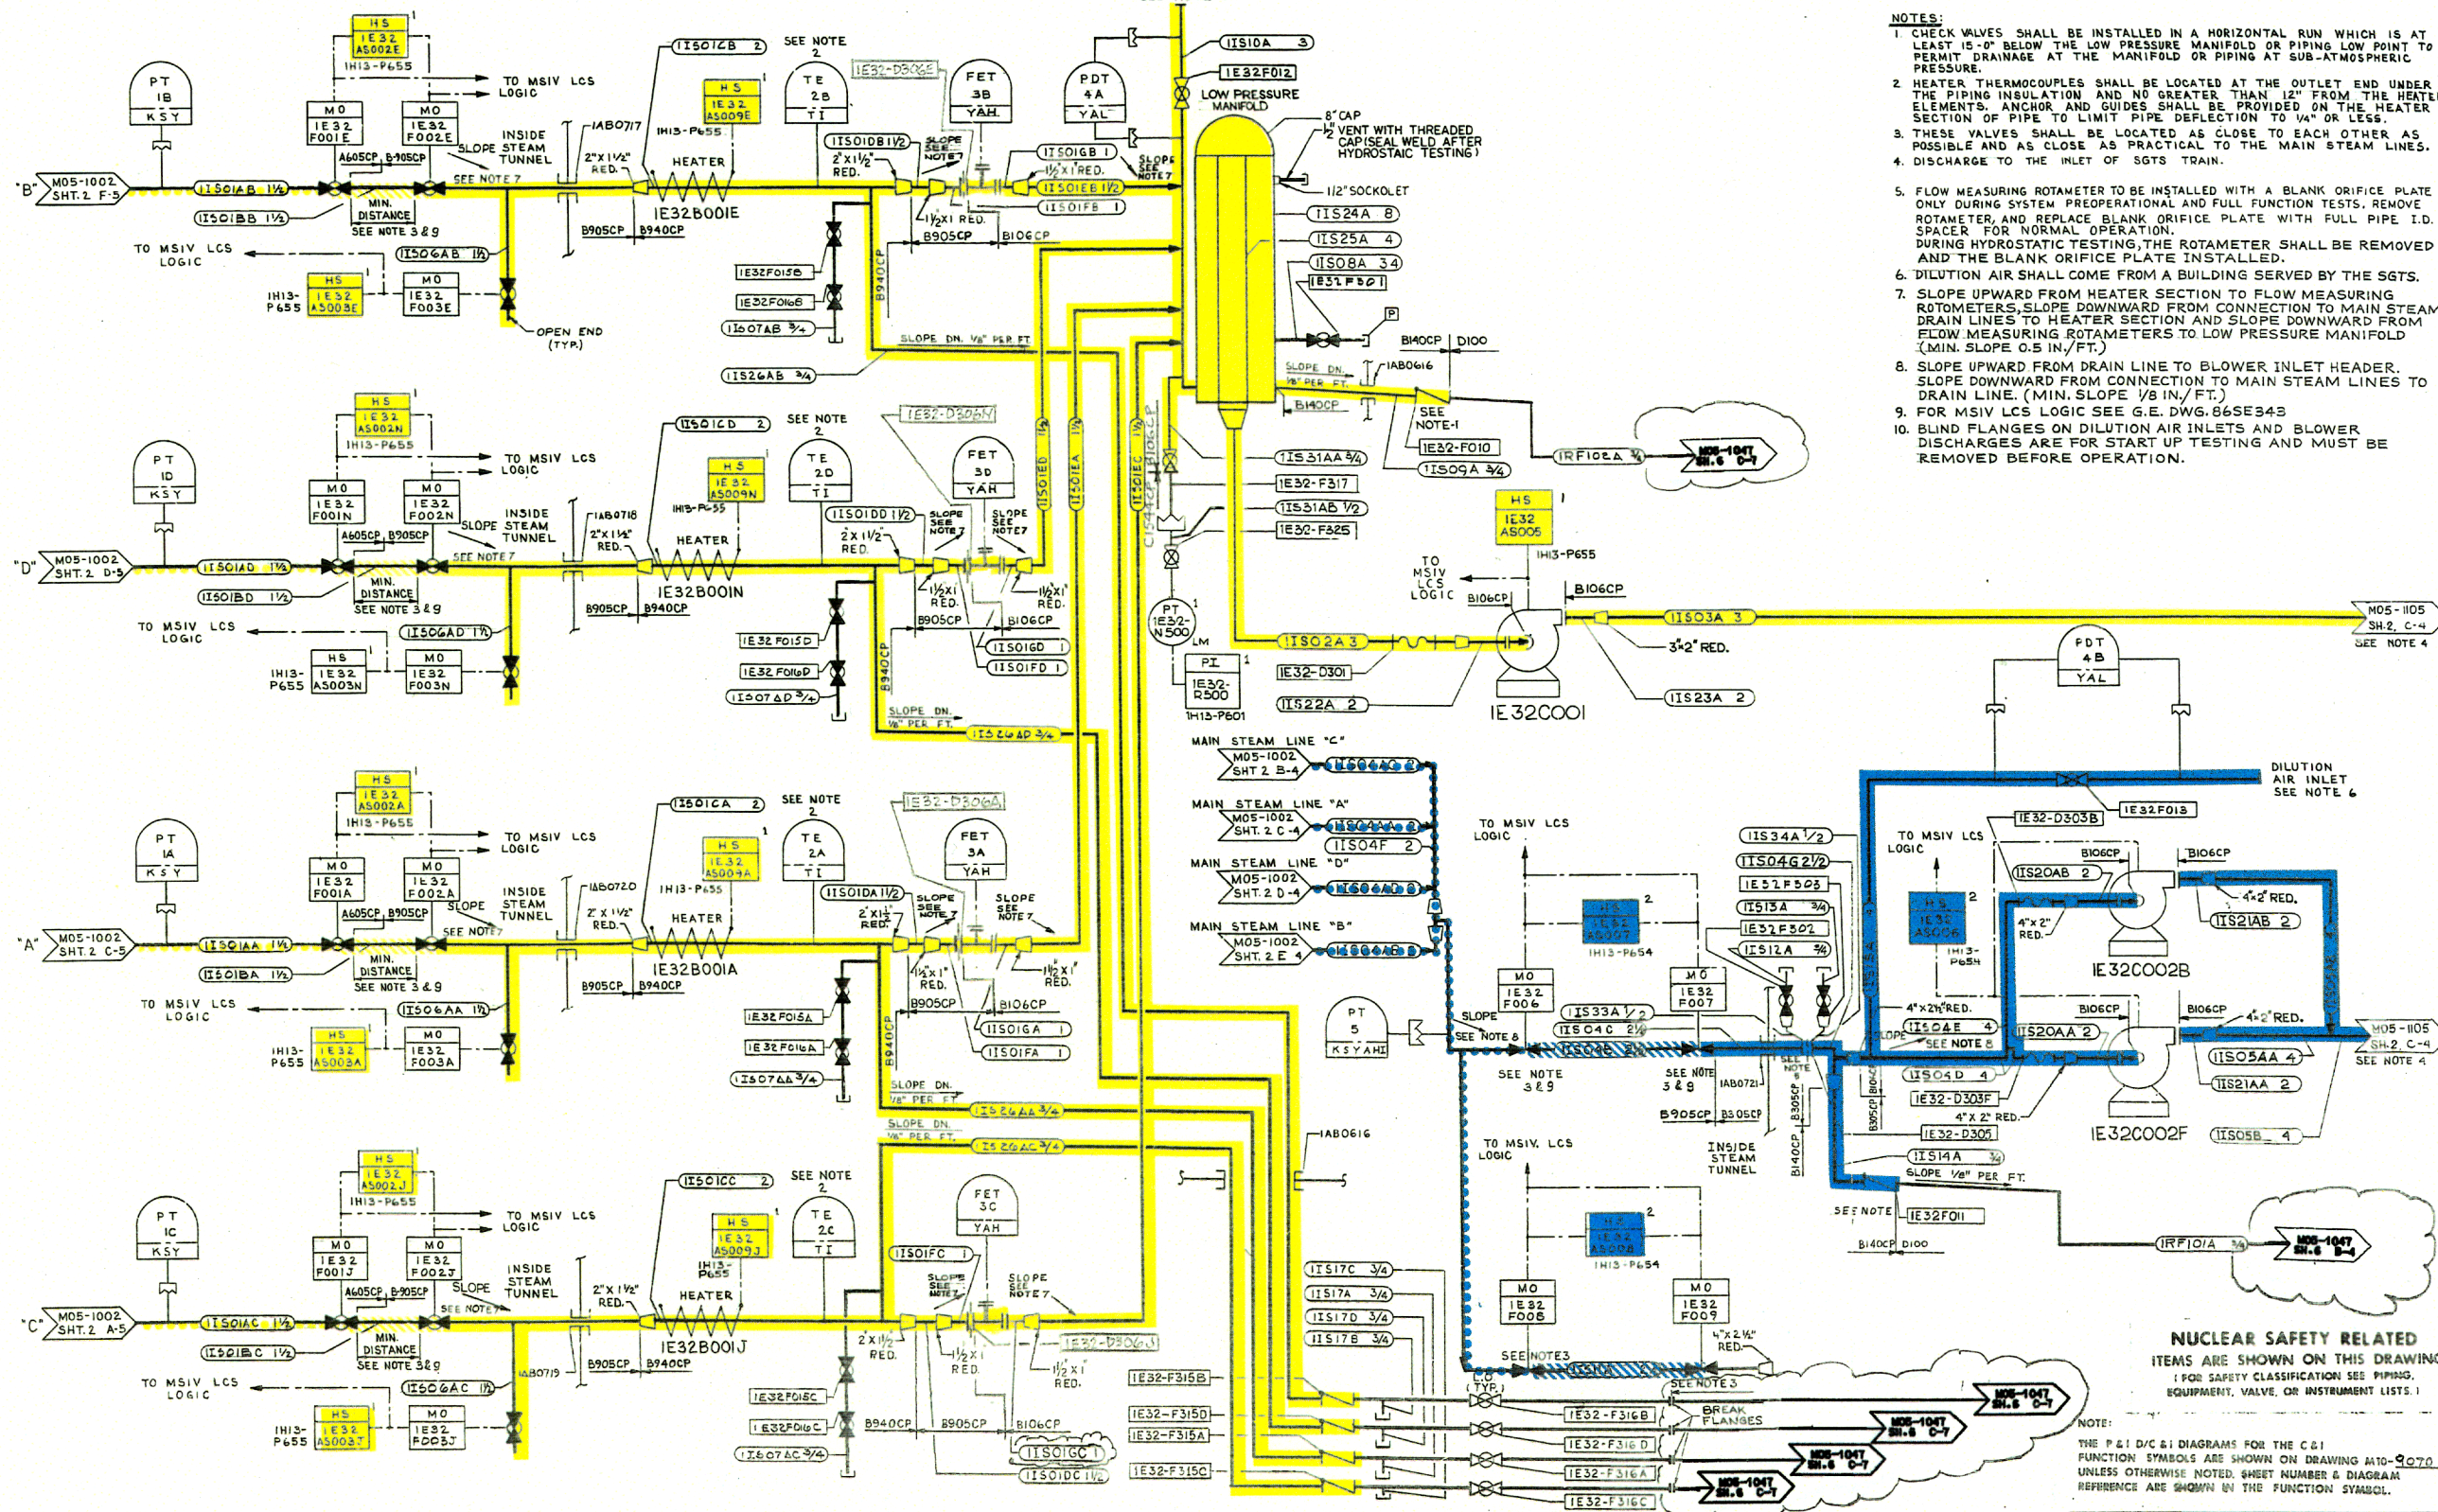

CLINTON POWER STATION
UPDATED SAFETY ANALYSIS REPORT

FIGURE 3.6-1
DIVISIONAL SEPARATION AND
HIGH-ENERGY P&ID'S-
MSIV LEAKAGE CONTROL SYSTEM
SHEET 54 OF 111

