

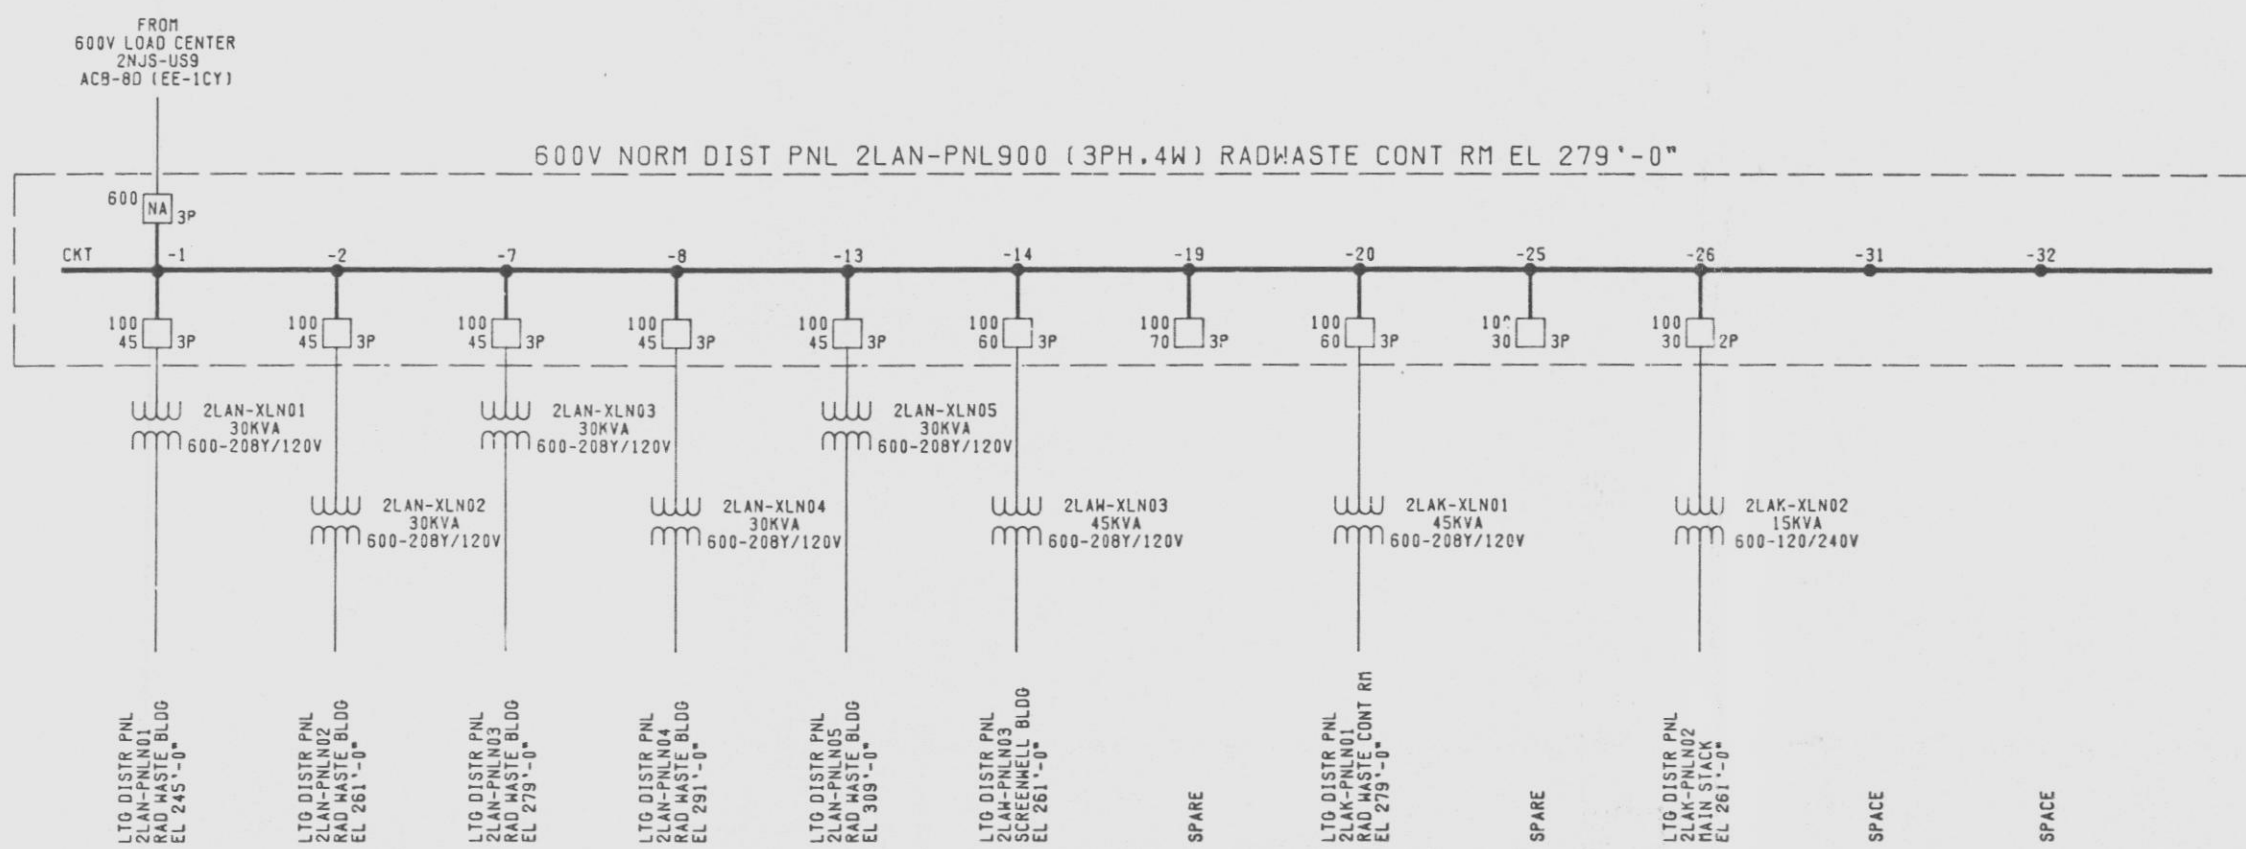


12177-EE-1BF-7

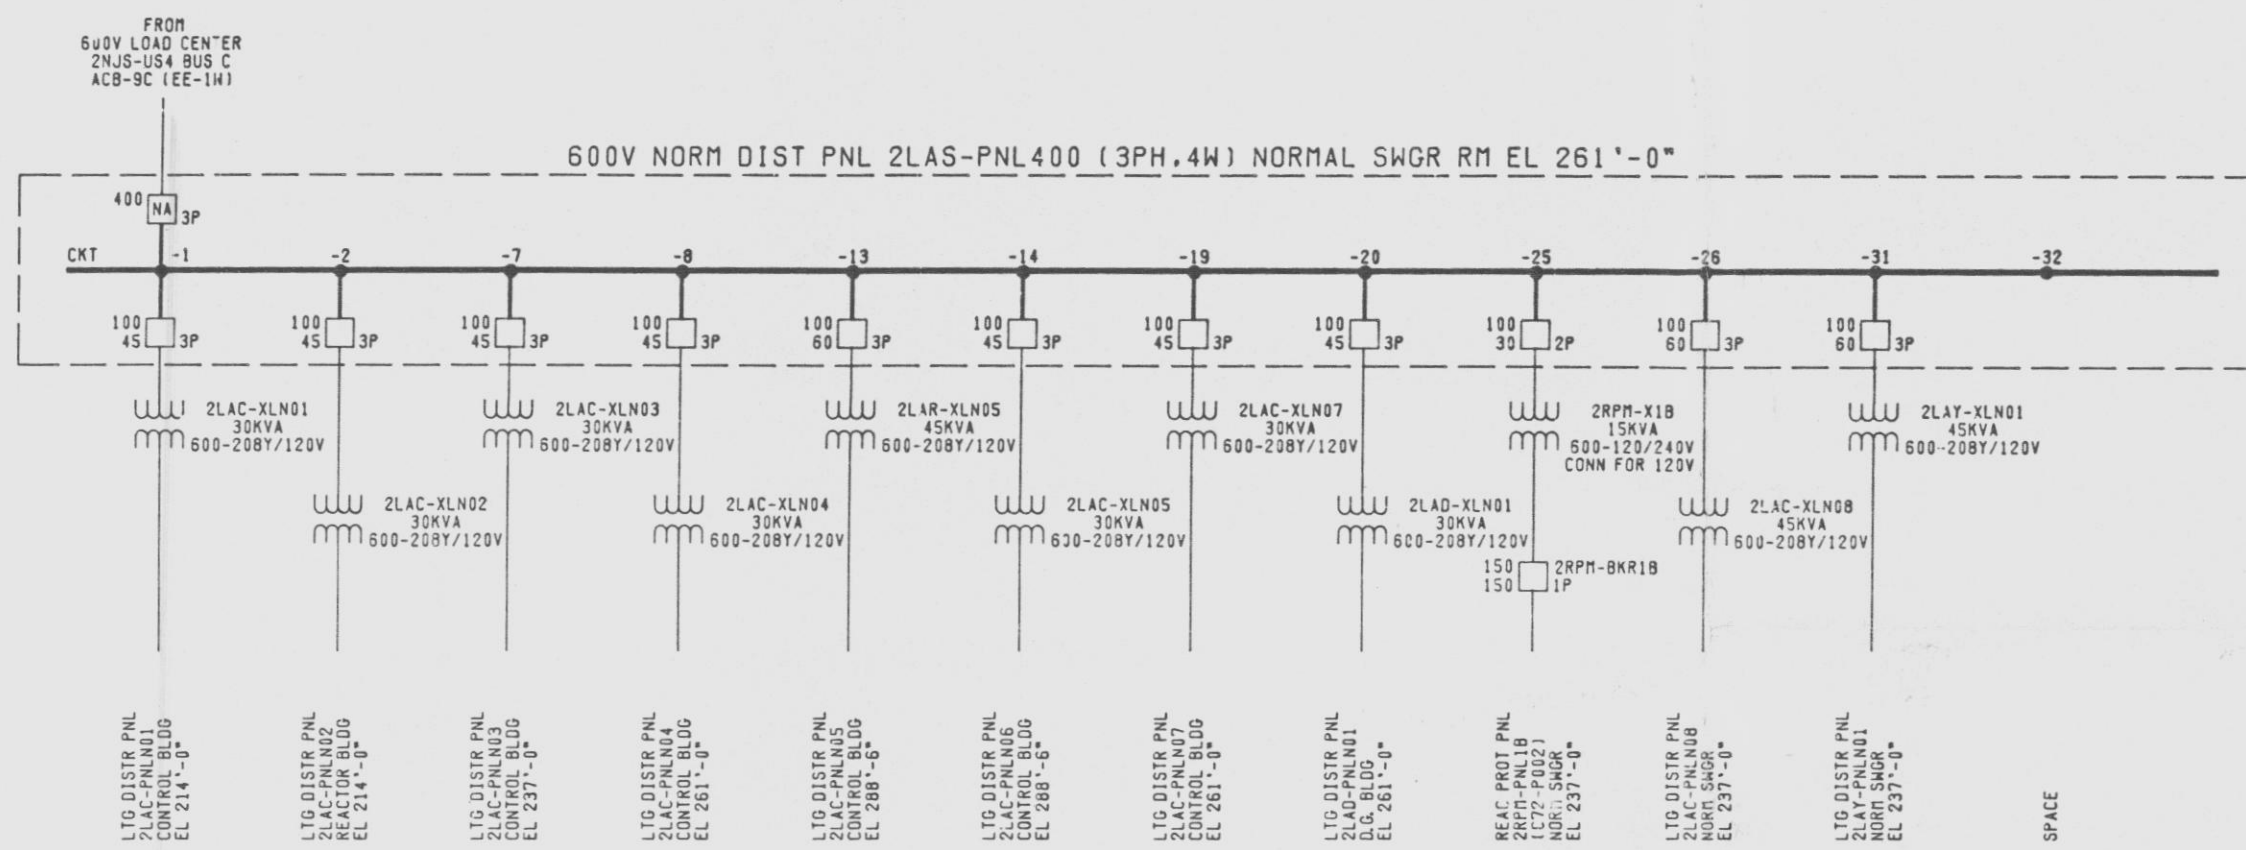

NOTES:  
1. GENERAL NOTES, REFERENCES & ADDITIONAL SYMBOLS SEE-1CA.

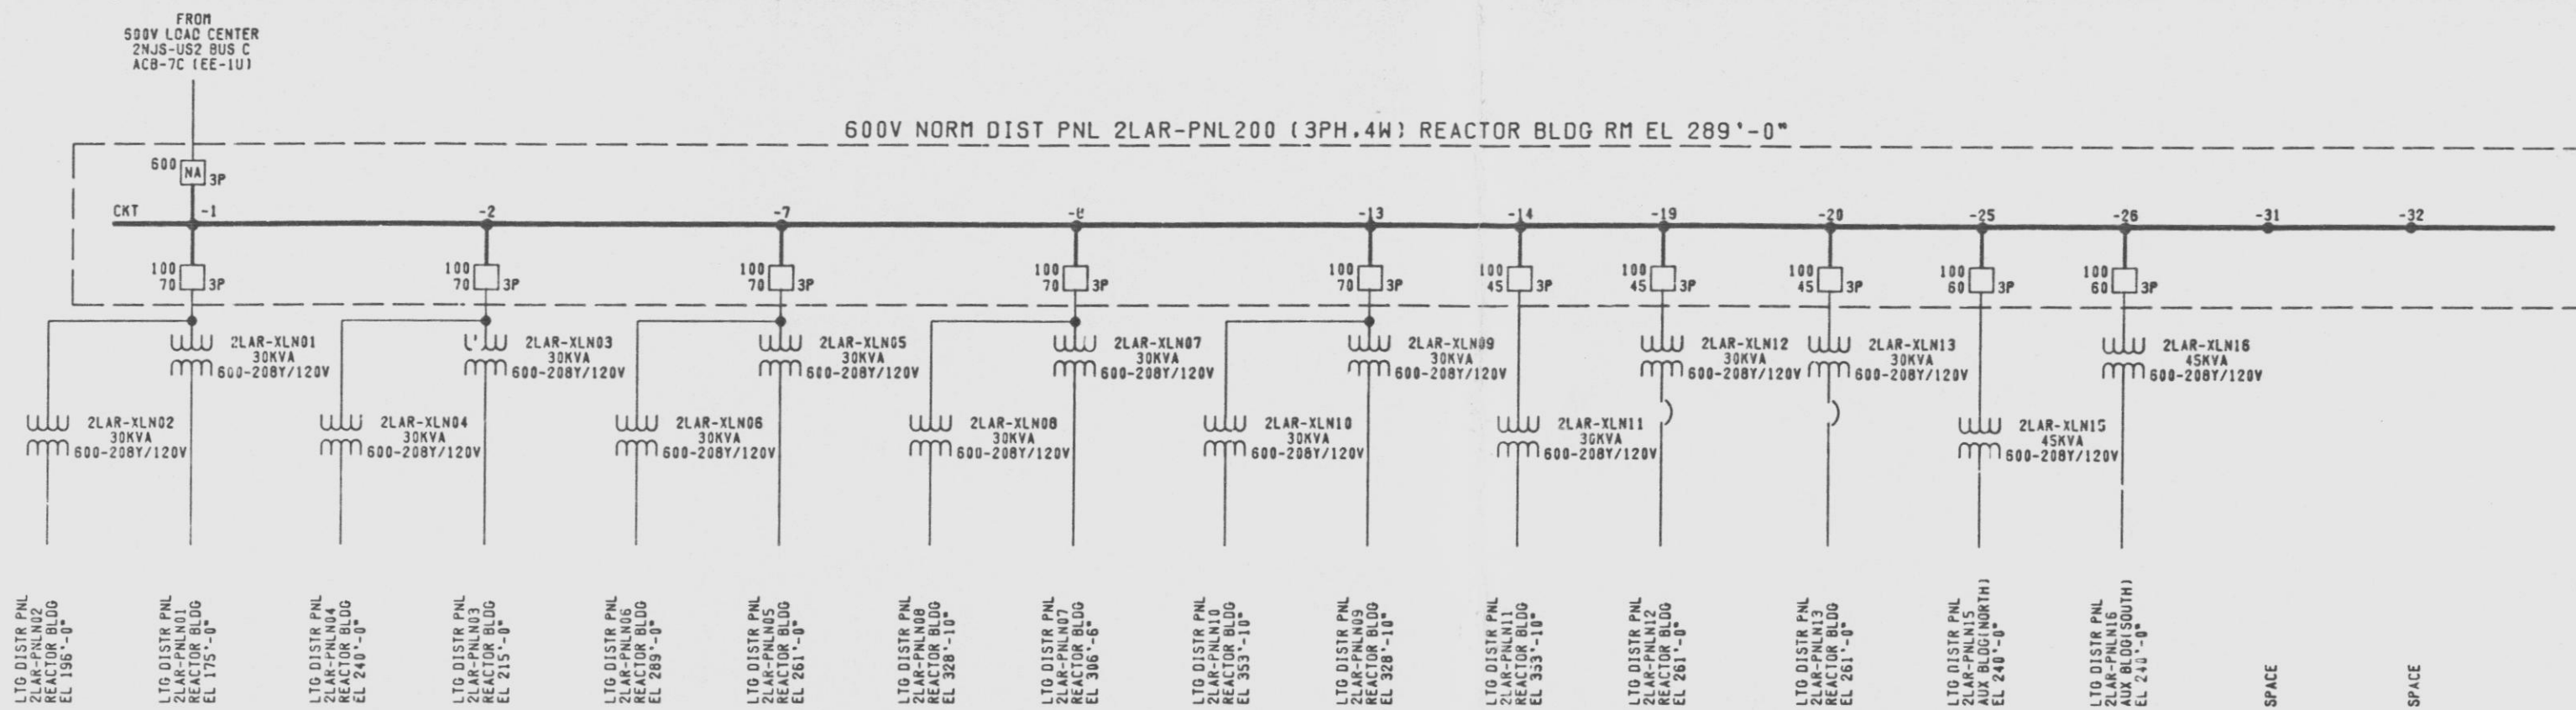

APPROVED *J. Cheesman*  
LICENSED PROFESSIONAL ENGINEER, NO. 55726  
ALTERATION EXCEPT BY A LICENSED PROFESSIONAL ENGINEER IN ALLIANCE

QA CAT II

600V ONE LINE DIAGRAM  
DISTRIBUTION PANELS  
2LAR-PNL200, 2LAS-PNL400 & 2LAN-PNL900  
NINE MILE POINT NUCLEAR STATION-UNIT 2  
NIAGARA MOHAWK POWER CORPORATION  
STONE & WEBSTER ENGINEERING CORPORATION  
CHERRY HILL, N.J.

DRAWING NUMBER 12177-EE-1BF-7

DESIGNED BY J. CHEESMAN DRAWN BY G. WEINBERG  
CHECKED BY C. HENDERSON

DATE 10/14/77

144 33A

144 33A

144 33A

144 33A

144 33A

144 33A