
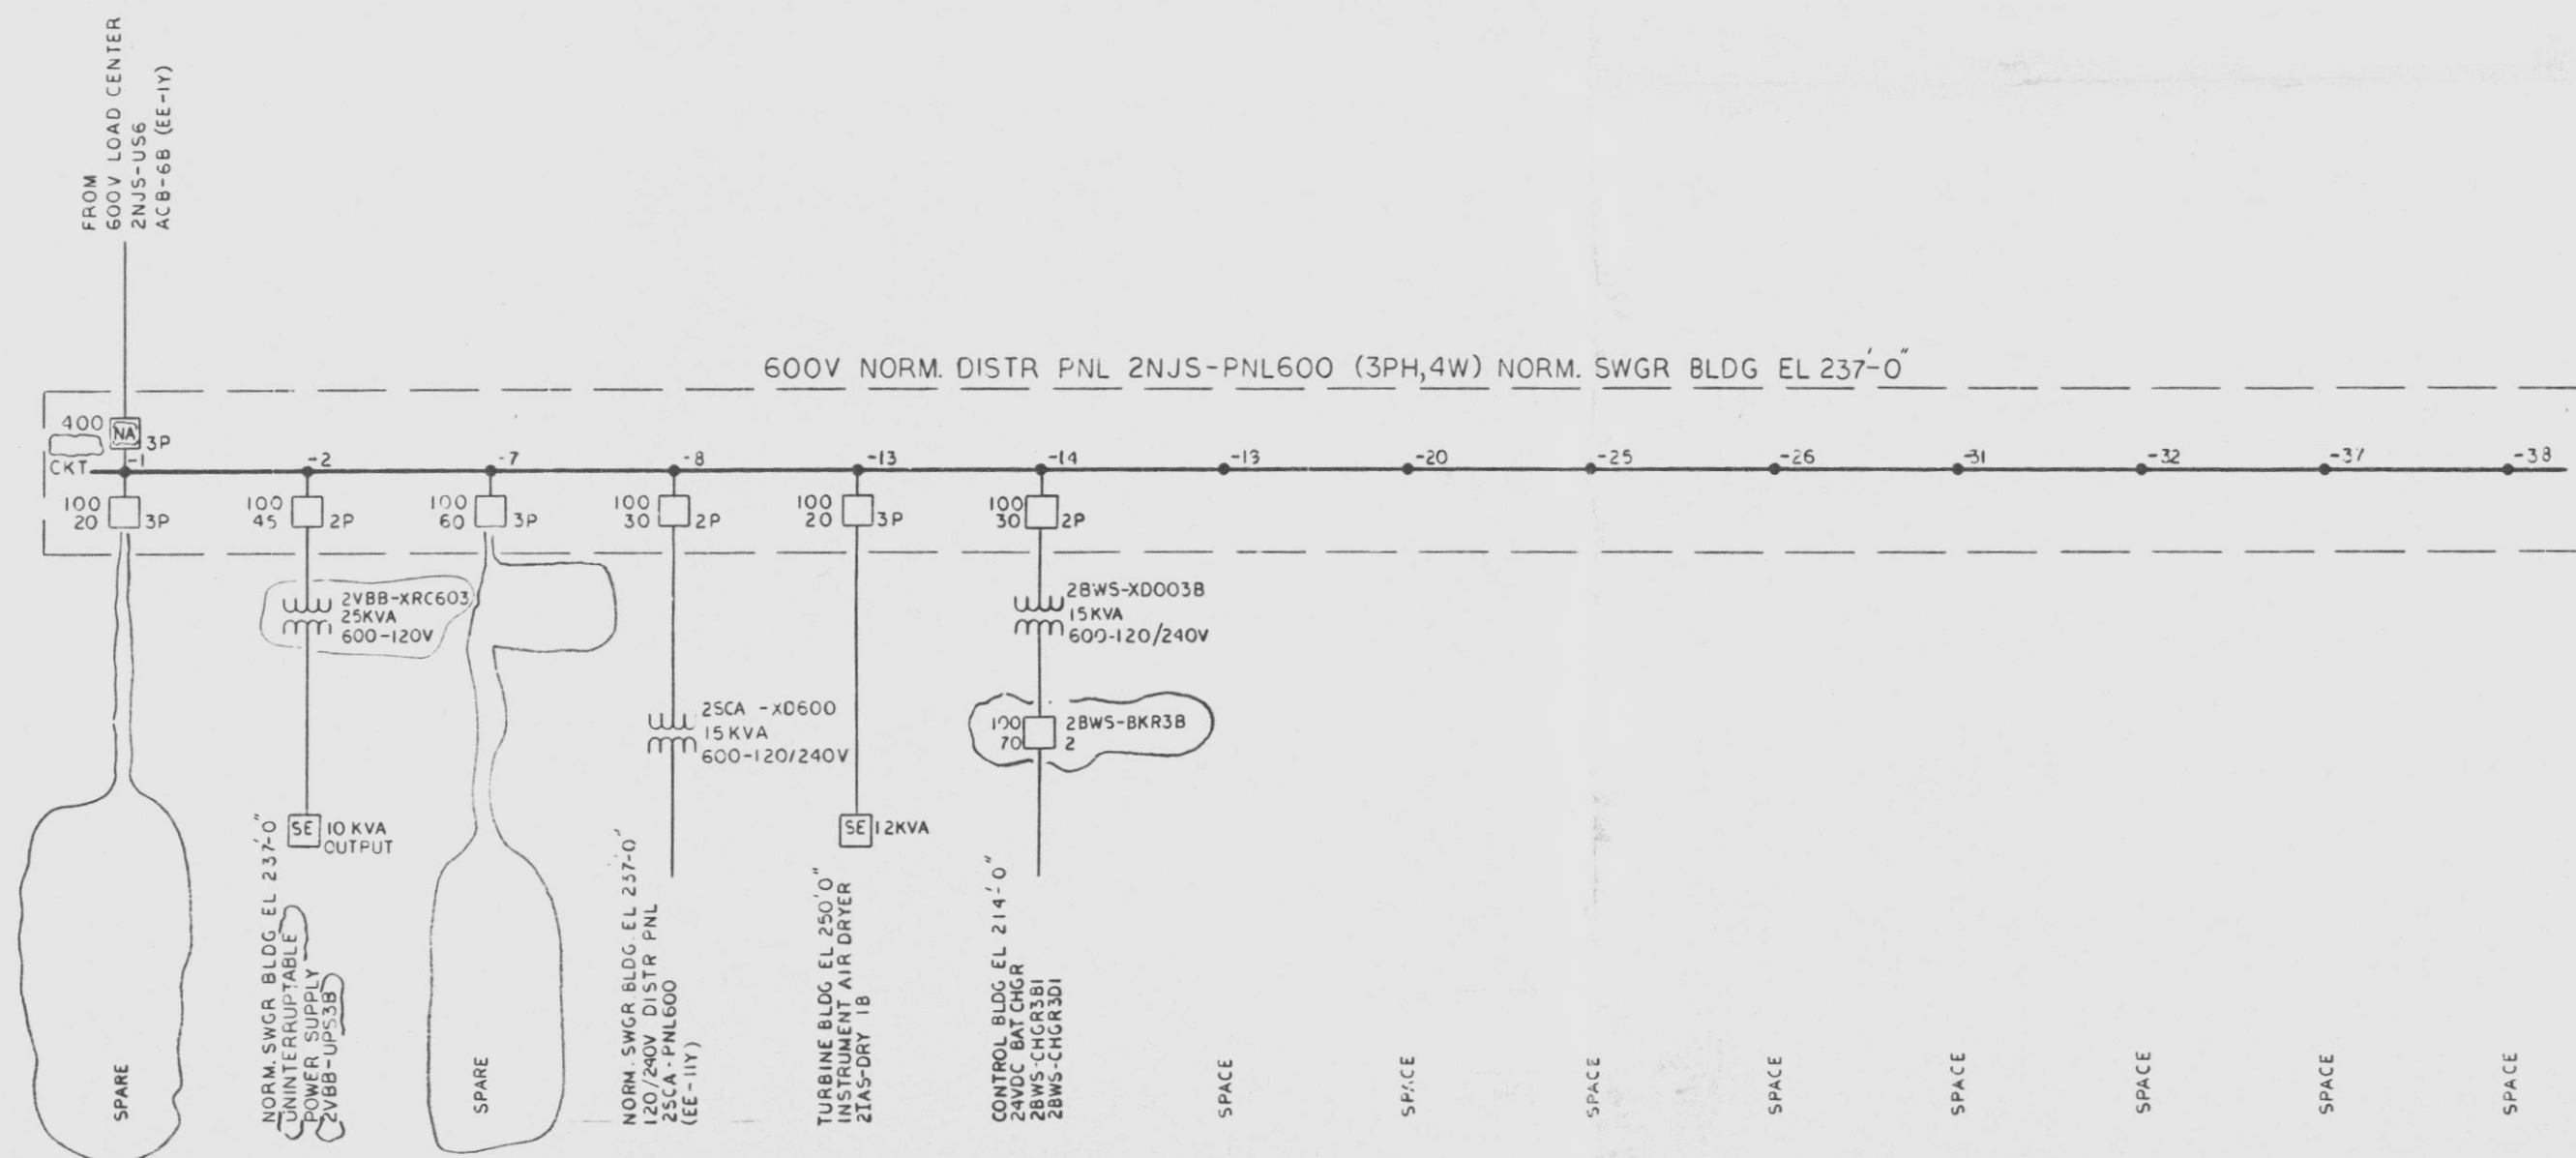


12177-EE-18G-3

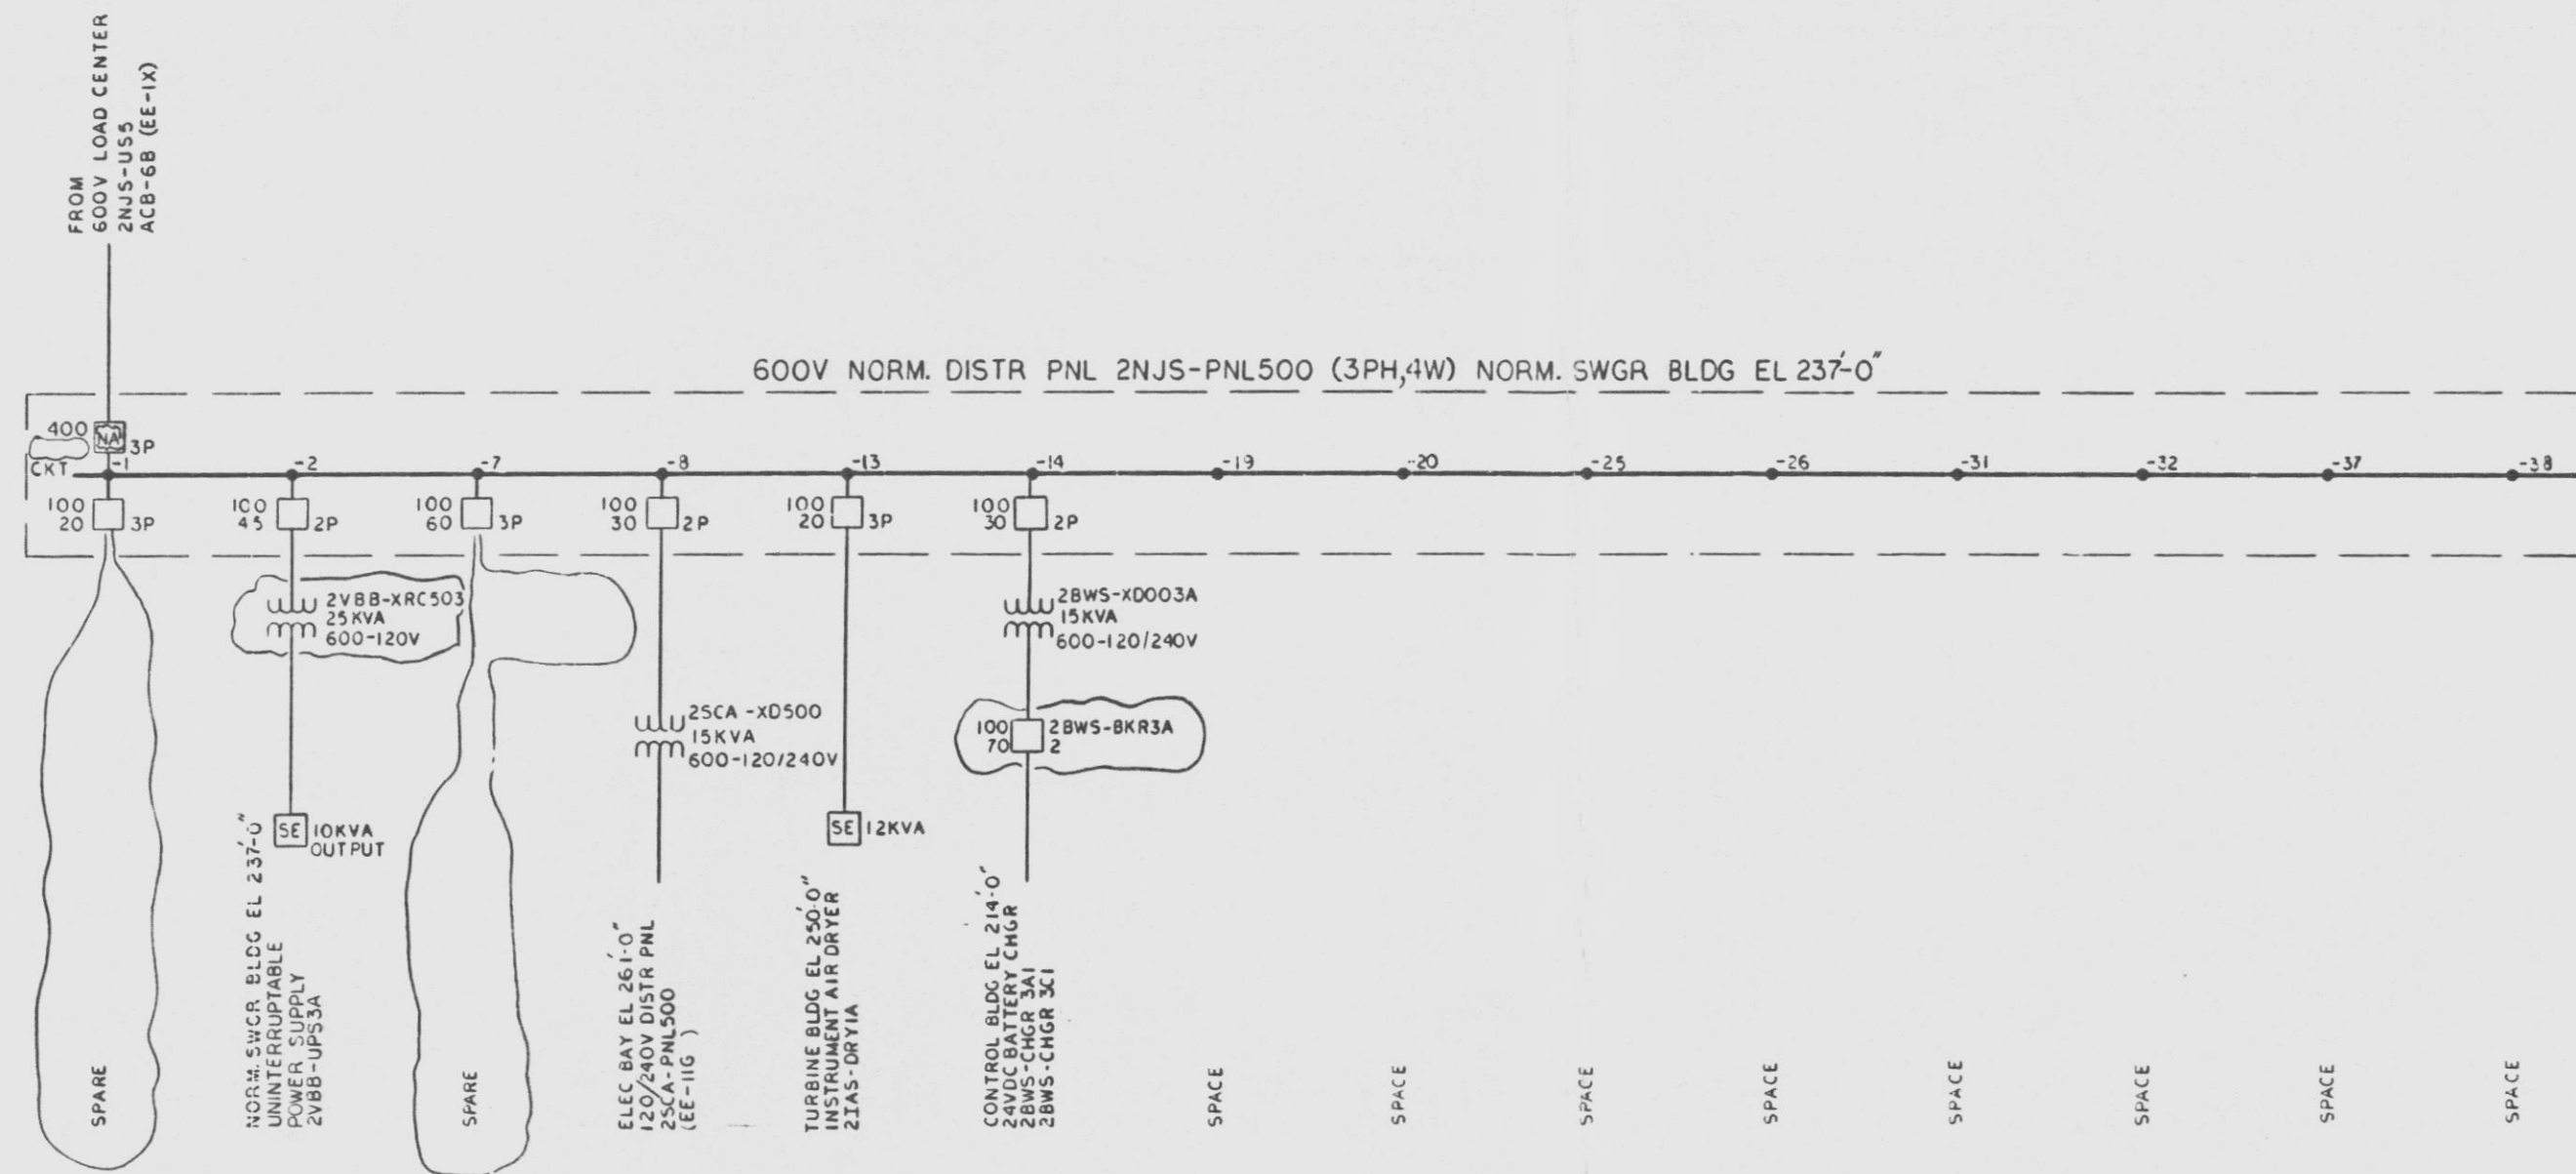

NOTES:
1. GENERAL NOTES, REFERENCES &
ADDITIONAL SYMBOLS EE-1CA.

APPROVED *K. K. K.*
LICENSED PROFESSIONAL ENGINEER, NO. 35786
STATE OF NEW YORK
ALTERATION EXCEPT BY A LICENSED PROFESSIONAL ENGINEER IS ILLEGAL.

QA CAT II

600V ONE LINE DIAGRAM
DISTRIBUTION PANELS
2NJS-PNL500 & 2NJS-PNL600

NINE MILE POINT NUCLEAR STATION - UNIT 2
NIAGARA MOHAWK POWER CORPORATION
STONE & WEBSTER ENGINEERING CORPORATION
CHERRY HILL, N.J.

CH *DR* *12/19*
DRAWING NUMBER 12177-EE-18G-3
DESIGNED BY D. BAKLEY DRAWN BY F. SCHRAMM
CHECKED BY C. HENDERSON

ISSUED FOR DESIGN REVIEW

THE INFORMATION ON THIS DRAWING MAY NOT BE COPIED
OR USED FOR OTHER THAN THE CONSTRUCTION,
MAINTENANCE OR REPAIR OF THE PLANT FACILITY
DEPICTED IN THE TITLE BLOCK.

ORIGINAL ISSUE

SEE RECORD OF DWG
CHANGES BCE-18G-2

SEE RECORD OF DRAWING
CHANGES BCE-18G-3

REV	DESCRIPTION	DATE	BY	CHKD	APPD	REV	DESCRIPTION	DATE	BY	CHKD	APPD	REV	DESCRIPTION	DATE	BY	CHKD	APPD
1	ISSUED FOR DESIGN REVIEW	12/19	DB	FS		2	CHANGES BCE-18G-2	12/19	DB	FS		3	CHANGES BCE-18G-3	12/19	DB	FS	

12/19

12/19

