



12177-EK-401A-1

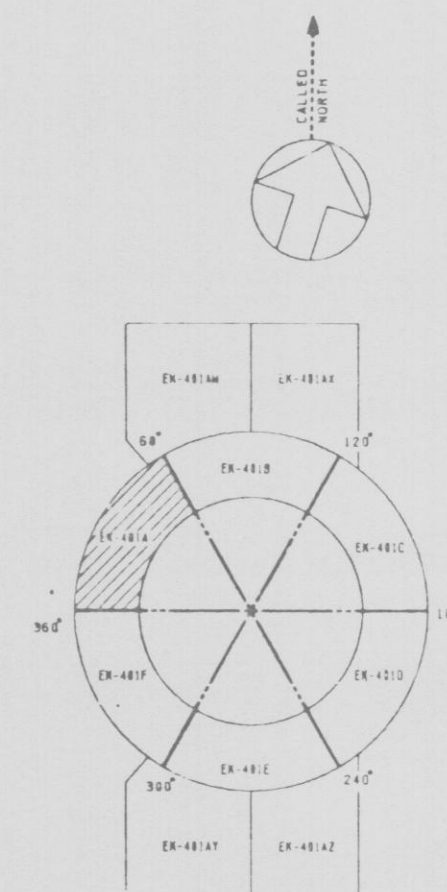

KEY PLAN  
EL 175'-0"

NOTES:  
1. SCALE: 3/8"=1'-0", UNLESS OTHERWISE NOTED.  
2. GENERAL NOTES AND REFERENCES, EK-401BC.

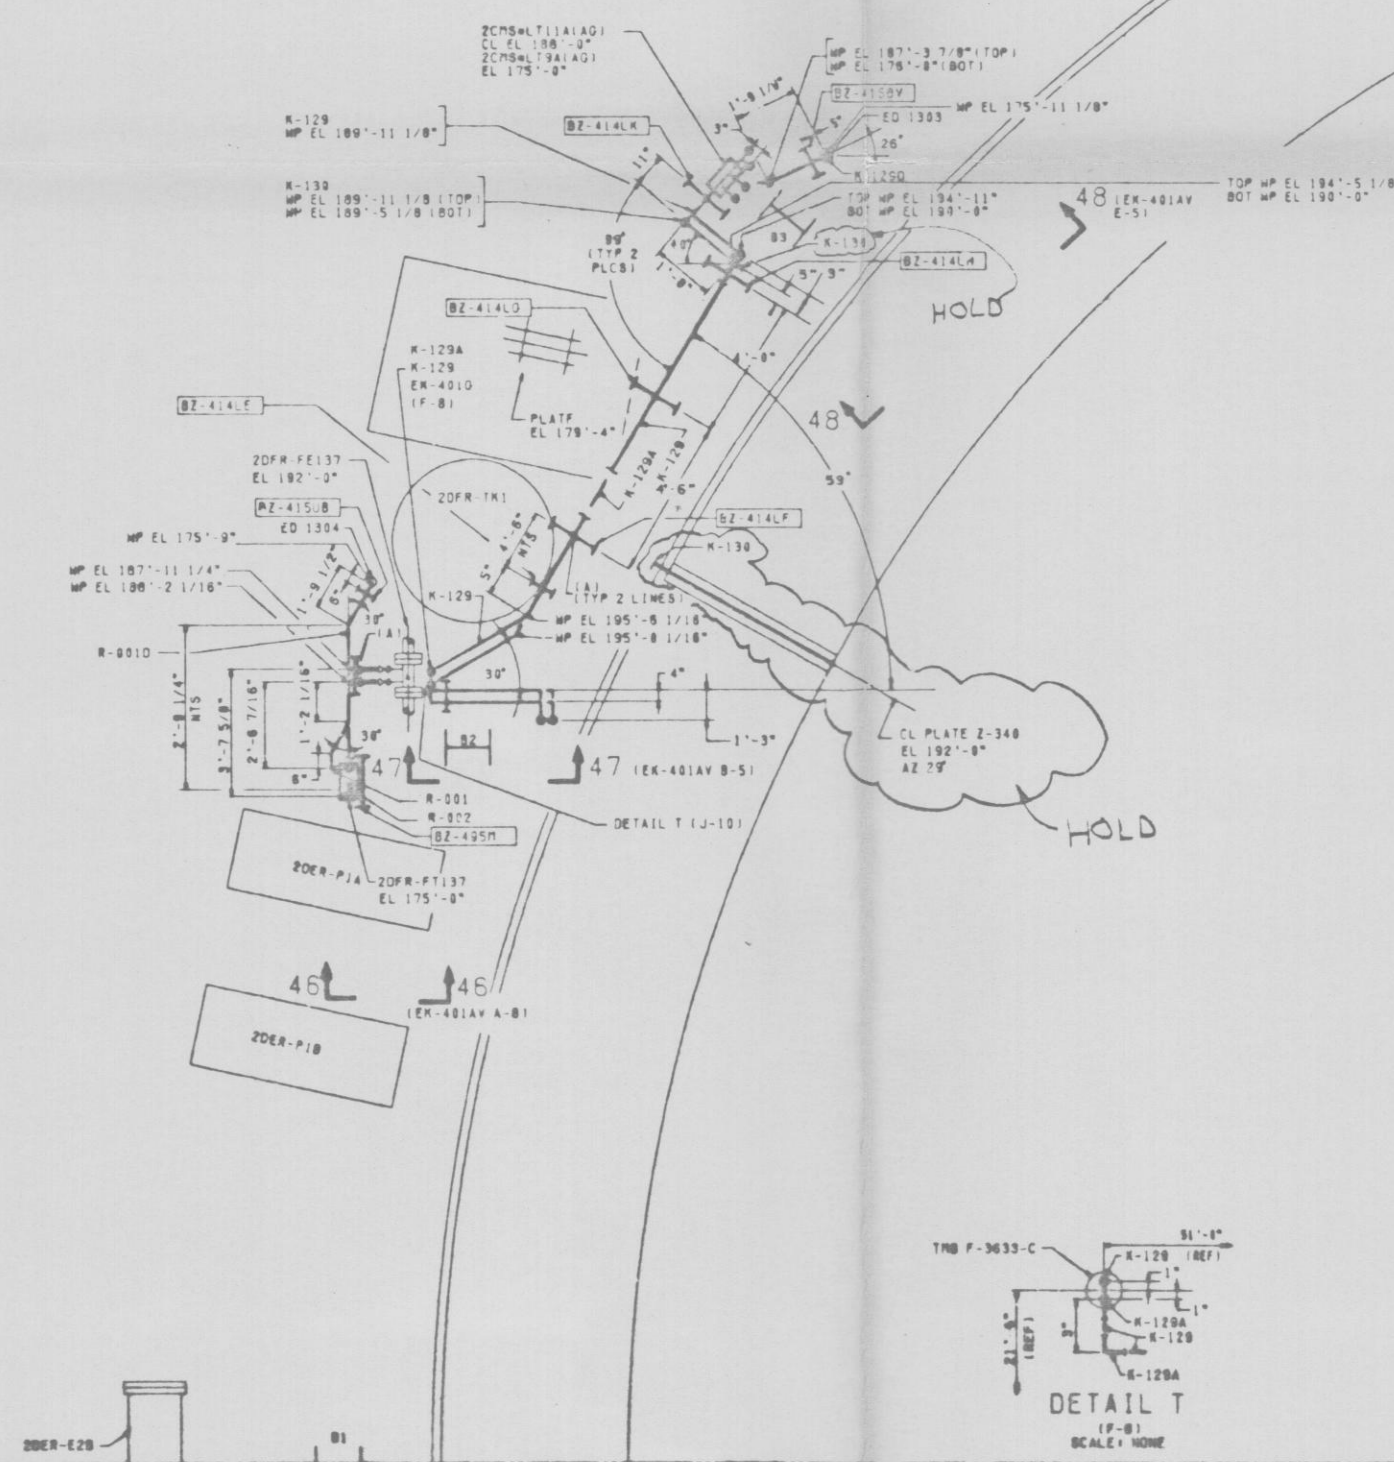

PRC  
APERTURE  
CARD



APPROVED R. J. Cohnick 59006

NUCLEAR SAFETY RELATED  
QA CAT I,II

INSTRUMENT PIPING PLAN  
REACTOR BUILDING  
EL 175'-0" SH 1

---

NINE MILE POINT NUCLEAR STATION-UNIT 2  
NIAGARA MOHAWK POWER CORPORATION

STONE & WEBSTER ENGINEERING CORPORATION  
CHERT HILL, N.J.

12177-EK-401A-1

DESIGNED BY E. LOEE	DRAWN BY E. LOEE	AREAS	LEVELS	WORTH
10.1	10.1	1	1	1

2025 RELEASE UNDER E.O. 14176

1

THE INFORMATION ON THIS DRAWING MAY NOT BE COPIED  
OR USED FOR OTHER THAN THE CONSTRUCTION,  
MAINTENANCE OR REPAIR OF THE PLANT FACILITY  
DESCRIBED IN THE TITLE BLOCK.

ORIGINAL ISSUE	2	---	---
----------------	---	-----	-----

FOR CONSTRUCTION		DATE	BY
DESCRIPTION	DATE	BY	BY

07	ARCH	CIVIL	COND	STL	LAP	INST	ALD	P.S	S.A	PAC	ELEC	LTE
----	------	-------	------	-----	-----	------	-----	-----	-----	-----	------	-----

24 25 26 100

1

0												4												8												C																			
DESCRIPTION				CHRG	CORRECT	DATE	DESCRIPTION				CHRG	CORRECT	DATE	DESCRIPTION				CHRG	CORRECT	DATE	DESCRIPTION				CHRG	CORRECT	DATE																												
PCT	ARCH	CIVIL	CONC	STL	LAP	INST	N/A	P.A.	N/A	PAC	ELEC	LTD	PAT	PCT	ARCH	CIVIL	CONC	STL	LAP	INST	N/A	P.A.	N/A	PAC	ELEC	LTD	PAT	PCT	ARCH	CIVIL	CONC	STL	LAP	INST	N/A	P.A.	N/A	PAC	ELEC	LTD	PAT	PCT	ARCH	CIVIL	CONC	STL	LAP	INST	N/A	P.A.	N/A	PAC	ELEC	LTD	PAT