

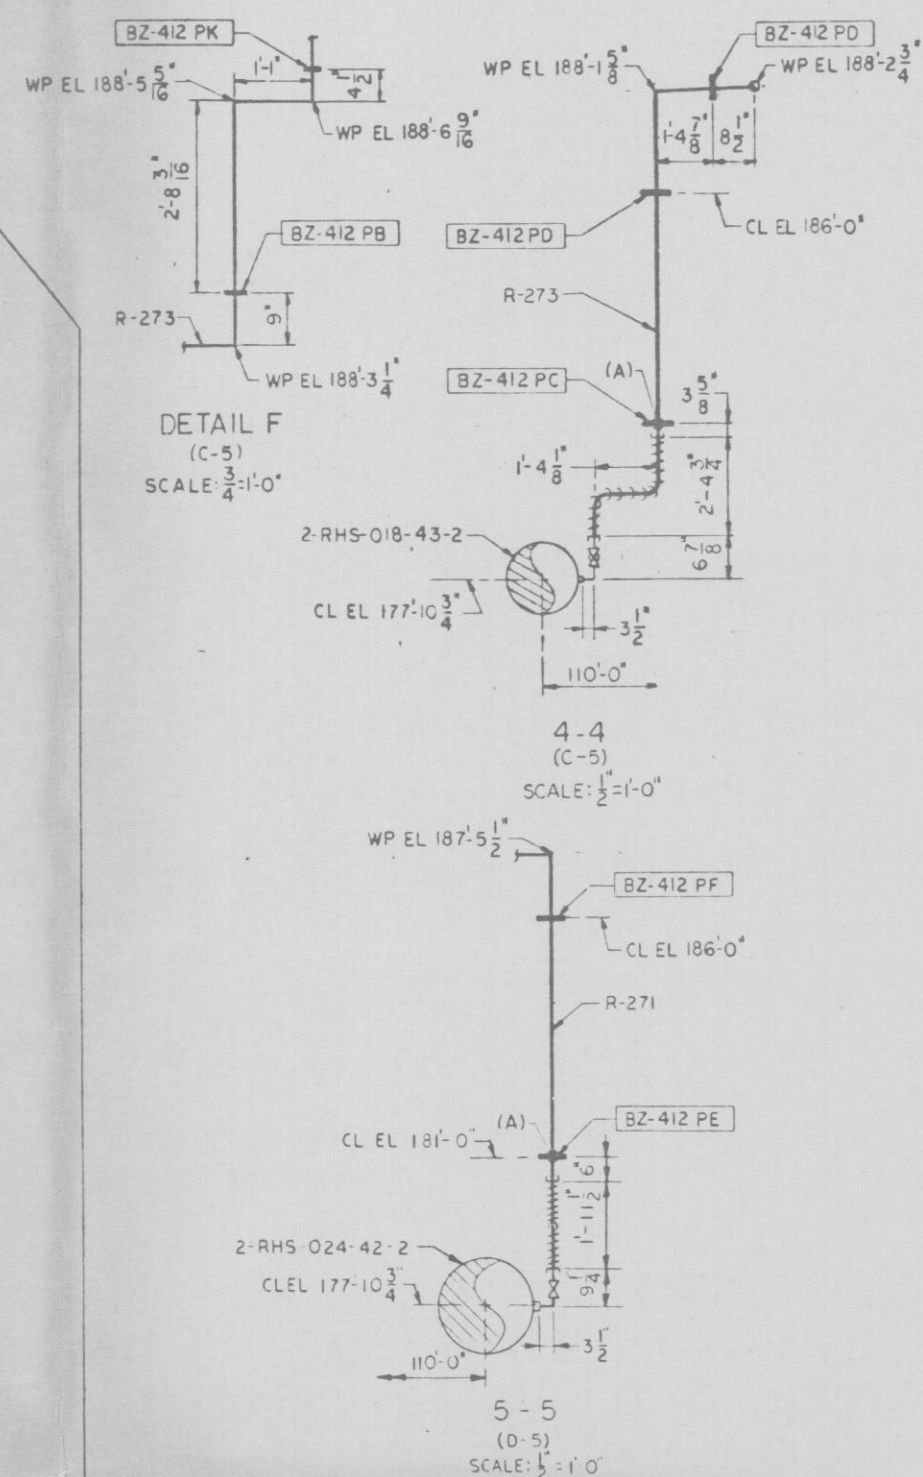
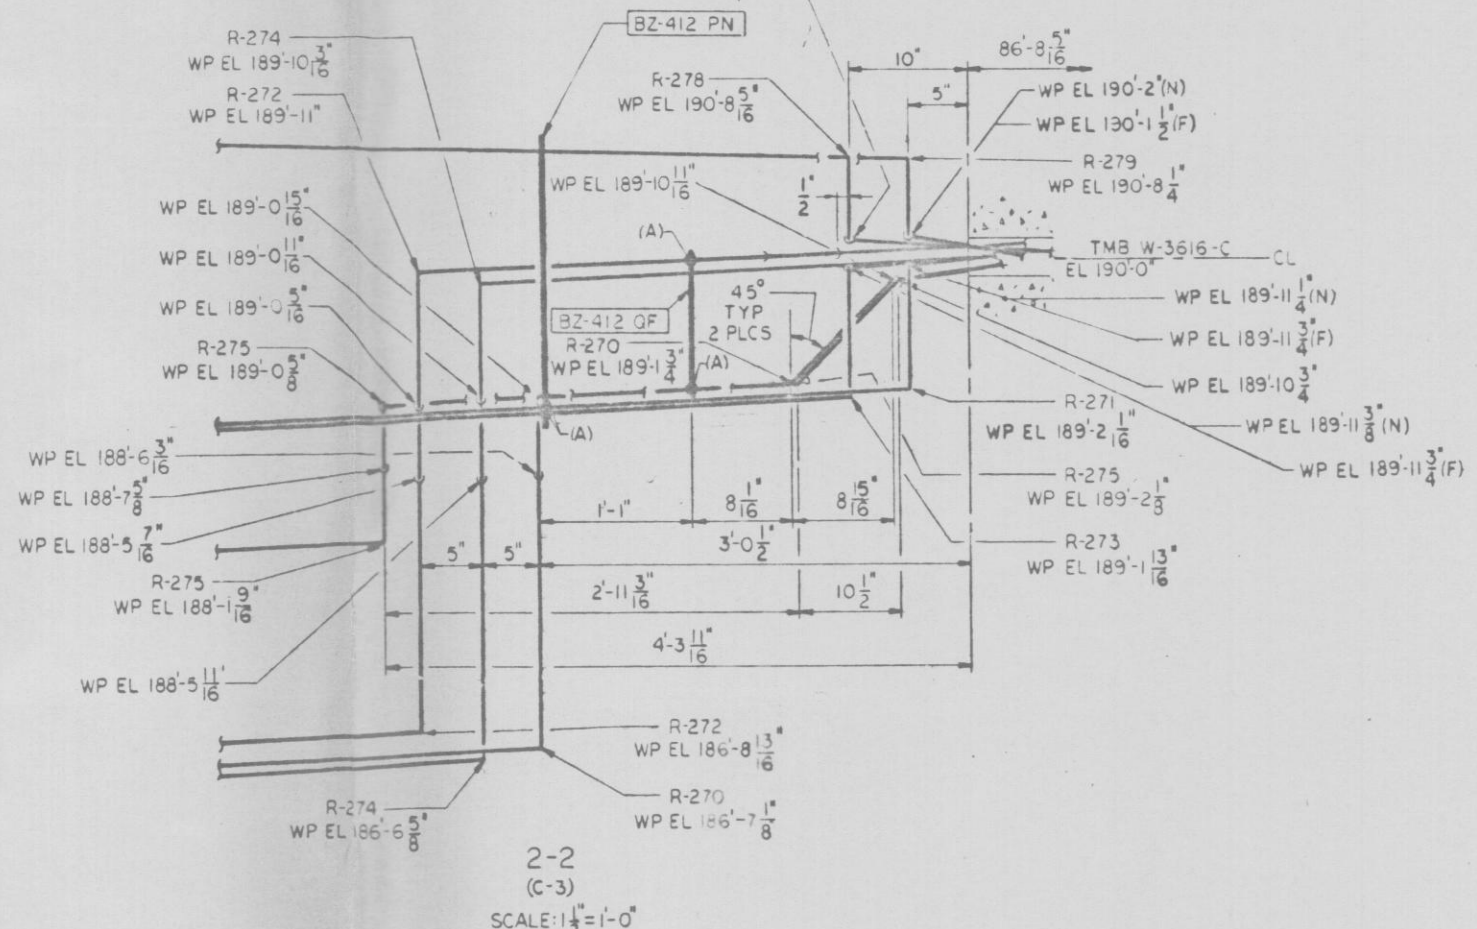
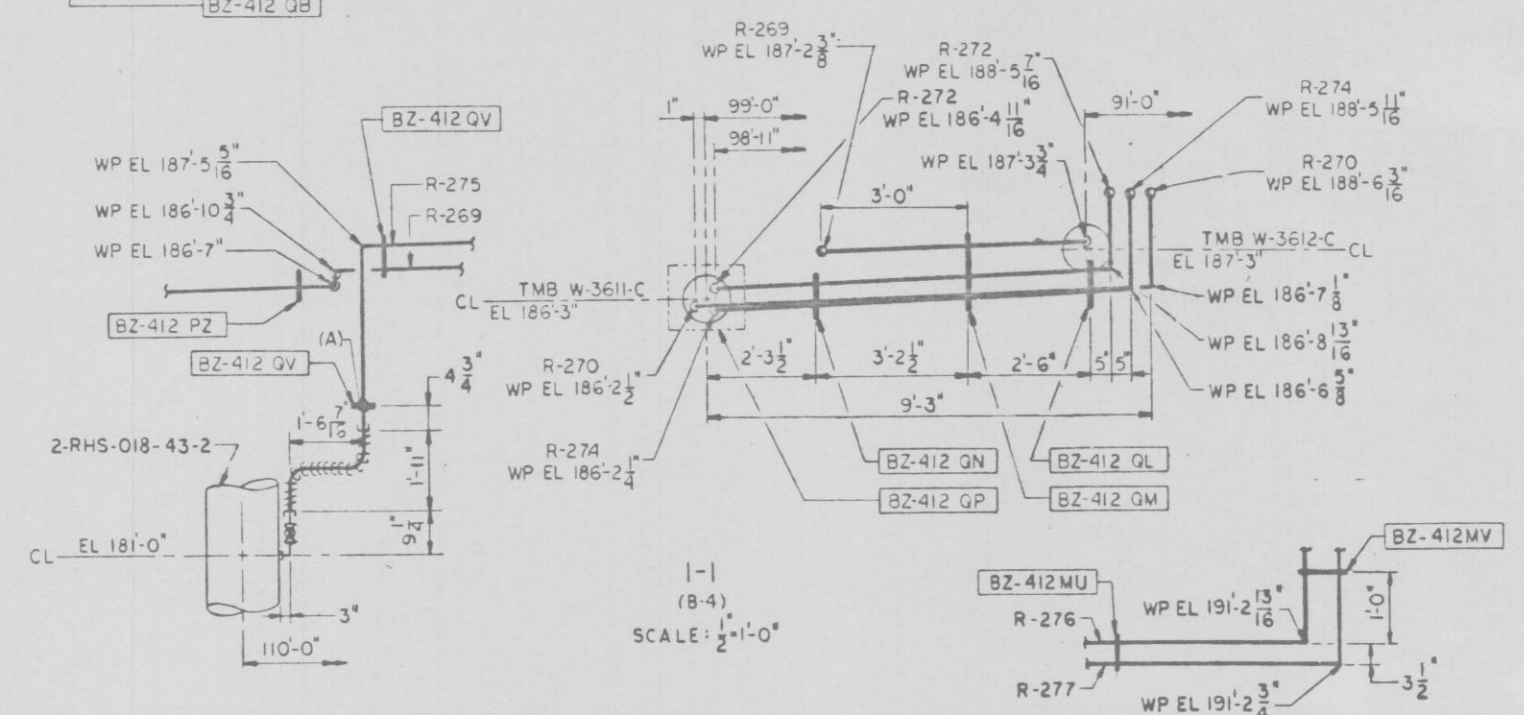


MATCH LINE EK-401 E-7

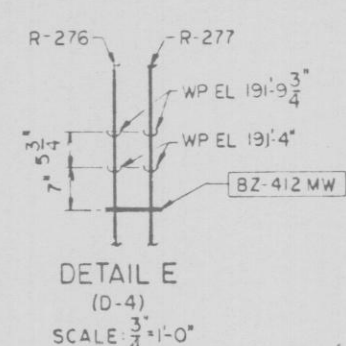

NOTES

1. SCALE: $\frac{3}{8}$ " = 1' 0" UNLESS OTHERWISE NOTED.
2. GENERAL NOTES & REFERENCES EK 401BC

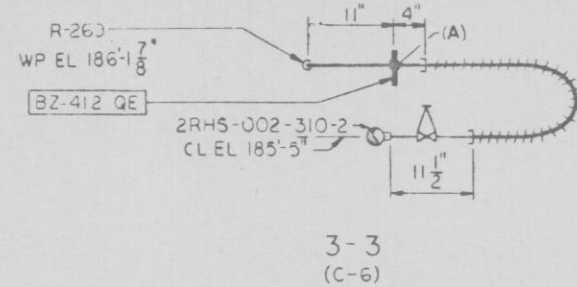

PRC
APERTURE
CARD




APPROVED: R. P. Potvin 59006
 LICENSED PROFESSIONAL ENGINEER, NO.
 STATE OF NEW YORK
 ALTERATION EXCEPT BY A LICENSED PROFESSIONAL ENGINEER IS ILLEGAL

NUCLEAR SAFETY RELATED
QA CAT I, II

INSTR PIPING PLAN
SOUTH AUX BAY EL 175'-0" SH 2
NINE MILE POINT NUCLEAR STATION - UNIT 2
NIAGARA MOHAWK POWER CORPORATION

STONE & WEBSTER ENGINEERING CORPORATION
CHERRY HILL, N.J.

CH  DRAWING 13177-EK-101A7-1

CH NUMBER 12177-ER-401A2-1

DESIGNED BY J. SYLVESTER	DRAWN BY TALAROWSKI	AREAS	LEVELS	WORK PKG
ORIGIN CHECK BY T. FOWLER	CHECK BY T. FOWLER	1	—	81C

1	2	3	100
---	---	---	---	---	---	---	---	---	----	----	-----

1

26