
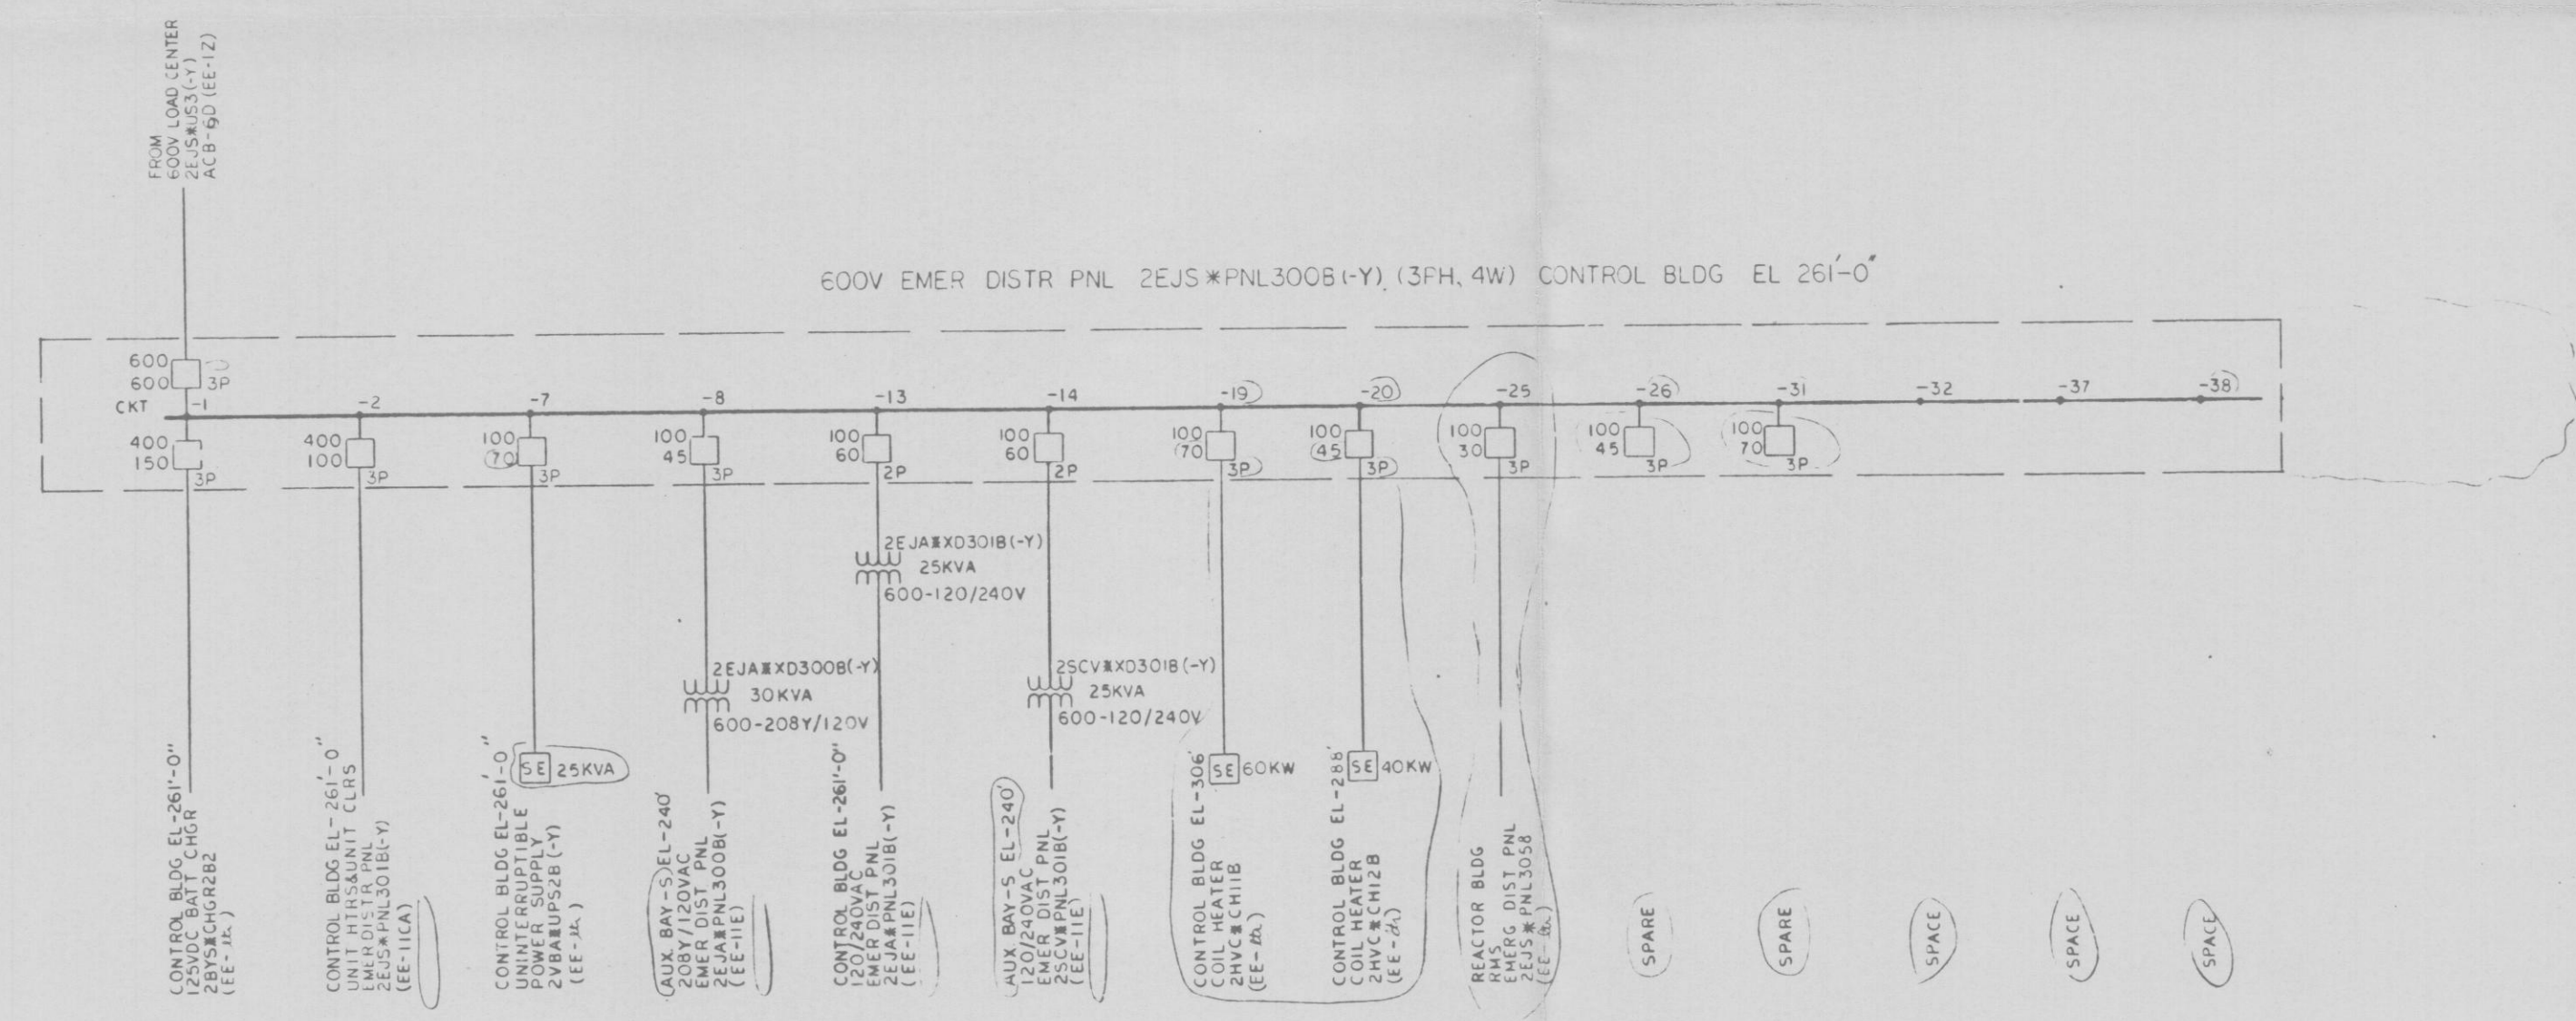


12177-EE-ICC-4

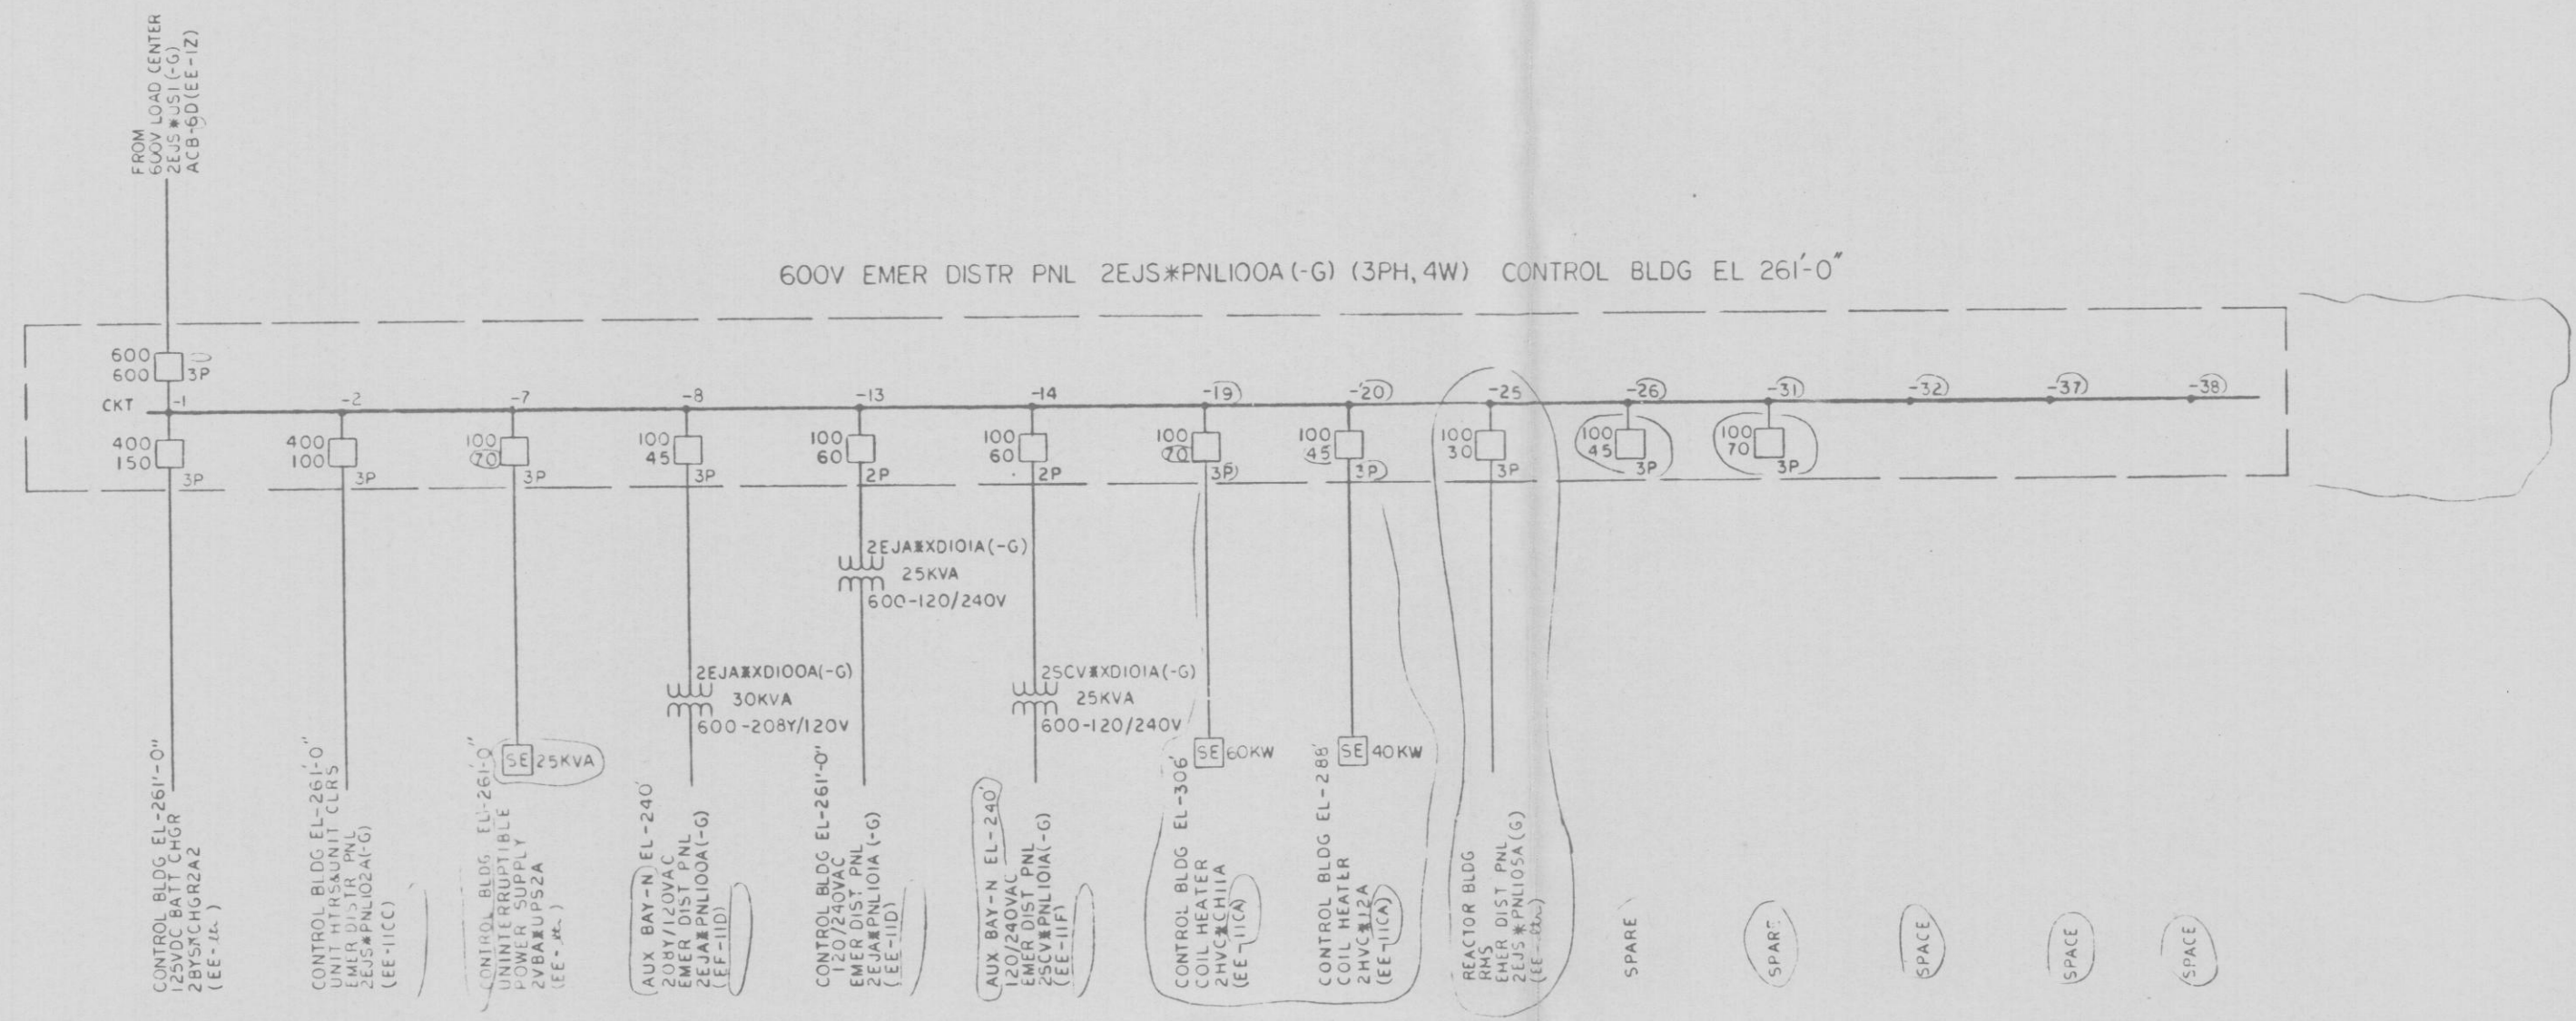

PRC
APERTURE
CARD

NOTES:
1. GENERAL NOTES, REFERENCES &
ADDITIONAL SYMBOLS EE-1CA.

NUCLEAR SAFETY RELATED
QA CAT I



APPROVED
LICENSED PROFESSIONAL ENGINEER NO 052849
STATE OF NEW YORK
ALTERATION EXCEPT BY A LICENSED PROFESSIONAL ENGINEER IS ILLEGAL

600V ONE LINE DIAGRAM
DISTRIBUTION PANELS
2EJS*PNL100A(-G) & 2EJS*PNL300B(-Y)
NINE MILE POINT NUCLEAR STATION - UNIT 2
NIAGARA MOHAWK POWER CORPORATION
RTONE & WEBSTER ENGINEERING CORPORATION
CHERRY HILL, NJ

CH
DRAWING NUMBER 12177-EE-ICC-4

DESIGNED BY J. CHEESMAN
DRAWN BY D. BAKLEY
CHECKED BY J. CHEESMAN

AREAS 4
LEVELS 33A

THE INFORMATION ON THIS DRAWING MAY NOT BE COPIED
OR USED FOR OTHER THAN THE CONSTRUCTION,
MAINTENANCE OR REPAIR OF THE PLANT FACILITY
DESCRIBED IN THE TITLE BLOCK.

NO.	DESCRIPTION	CHG	CORR	APP	DATE	ISSUE	NO.	DESCRIPTION	CHG	CORR	APP	DATE	ISSUE	NO.	DESCRIPTION	CHG	CORR	APP	DATE	ISSUE
1	600V EMER DISTR PNL 2EJS*PNL100A(-G) (3PH,4W) CONTROL BLDG EL 261'-0"						2	600V EMER DISTR PNL 2EJS*PNL300B(-Y) (3PH,4W) CONTROL BLDG EL 261'-0"						3	600V EMER DISTR PNL 2EJS*PNL100A(-G) (3PH,4W) CONTROL BLDG EL 261'-0"					
4	600V EMER DISTR PNL 2EJS*PNL100A(-G) (3PH,4W) CONTROL BLDG EL 261'-0"						6	600V EMER DISTR PNL 2EJS*PNL100A(-G) (3PH,4W) CONTROL BLDG EL 261'-0"						8	600V EMER DISTR PNL 2EJS*PNL100A(-G) (3PH,4W) CONTROL BLDG EL 261'-0"					
10	600V EMER DISTR PNL 2EJS*PNL100A(-G) (3PH,4W) CONTROL BLDG EL 261'-0"						12	600V EMER DISTR PNL 2EJS*PNL100A(-G) (3PH,4W) CONTROL BLDG EL 261'-0"						14	600V EMER DISTR PNL 2EJS*PNL100A(-G) (3PH,4W) CONTROL BLDG EL 261'-0"					
16	600V EMER DISTR PNL 2EJS*PNL100A(-G) (3PH,4W) CONTROL BLDG EL 261'-0"						18	600V EMER DISTR PNL 2EJS*PNL100A(-G) (3PH,4W) CONTROL BLDG EL 261'-0"						20	600V EMER DISTR PNL 2EJS*PNL100A(-G) (3PH,4W) CONTROL BLDG EL 261'-0"					
22	600V EMER DISTR PNL 2EJS*PNL100A(-G) (3PH,4W) CONTROL BLDG EL 261'-0"						24	600V EMER DISTR PNL 2EJS*PNL100A(-G) (3PH,4W) CONTROL BLDG EL 261'-0"						26	600V EMER DISTR PNL 2EJS*PNL100A(-G) (3PH,4W) CONTROL BLDG EL 261'-0"					
28	600V EMER DISTR PNL 2EJS*PNL100A(-G) (3PH,4W) CONTROL BLDG EL 261'-0"						30	600V EMER DISTR PNL 2EJS*PNL100A(-G) (3PH,4W) CONTROL BLDG EL 261'-0"						32	600V EMER DISTR PNL 2EJS*PNL100A(-G) (3PH,4W) CONTROL BLDG EL 261'-0"					
34	600V EMER DISTR PNL 2EJS*PNL100A(-G) (3PH,4W) CONTROL BLDG EL 261'-0"						36	600V EMER DISTR PNL 2EJS*PNL100A(-G) (3PH,4W) CONTROL BLDG EL 261'-0"						38	600V EMER DISTR PNL 2EJS*PNL100A(-G) (3PH,4W) CONTROL BLDG EL 261'-0"					
40	600V EMER DISTR PNL 2EJS*PNL100A(-G) (3PH,4W) CONTROL BLDG EL 261'-0"						42	600V EMER DISTR PNL 2EJS*PNL100A(-G) (3PH,4W) CONTROL BLDG EL 261'-0"						44	600V EMER DISTR PNL 2EJS*PNL100A(-G) (3PH,4W) CONTROL BLDG EL 261'-0"					
46	600V EMER DISTR PNL 2EJS*PNL100A(-G) (3PH,4W) CONTROL BLDG EL 261'-0"						48	600V EMER DISTR PNL 2EJS*PNL100A(-G) (3PH,4W) CONTROL BLDG EL 261'-0"						50	600V EMER DISTR PNL 2EJS*PNL100A(-G) (3PH,4W) CONTROL BLDG EL 261'-0"					