
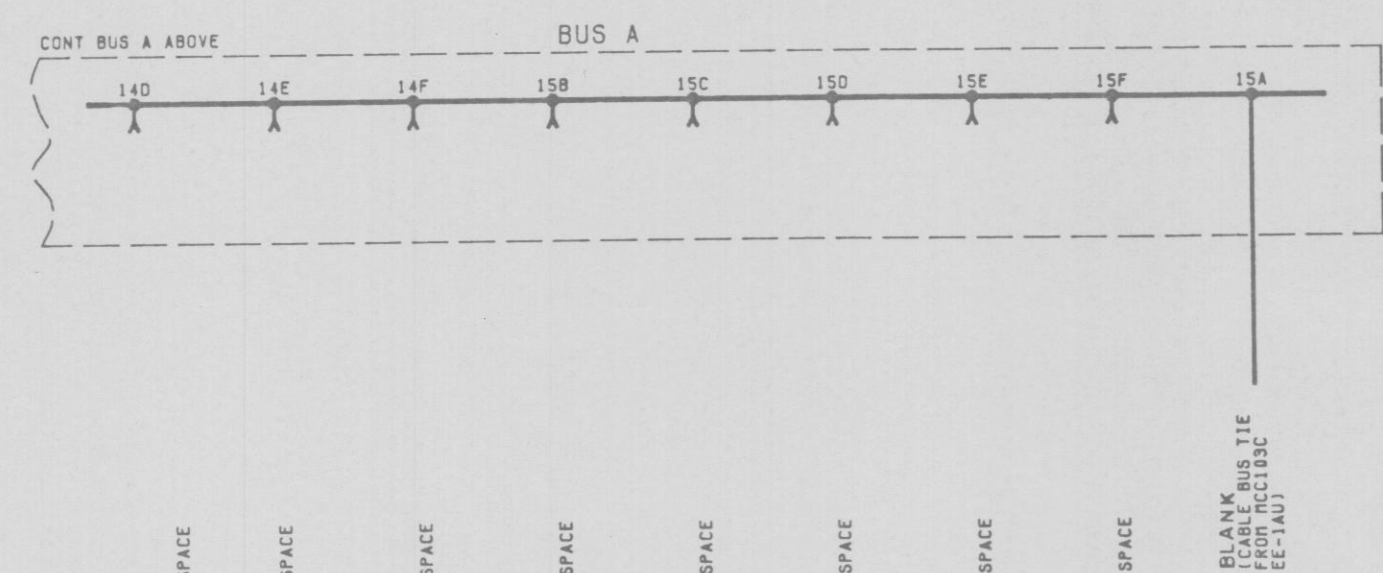
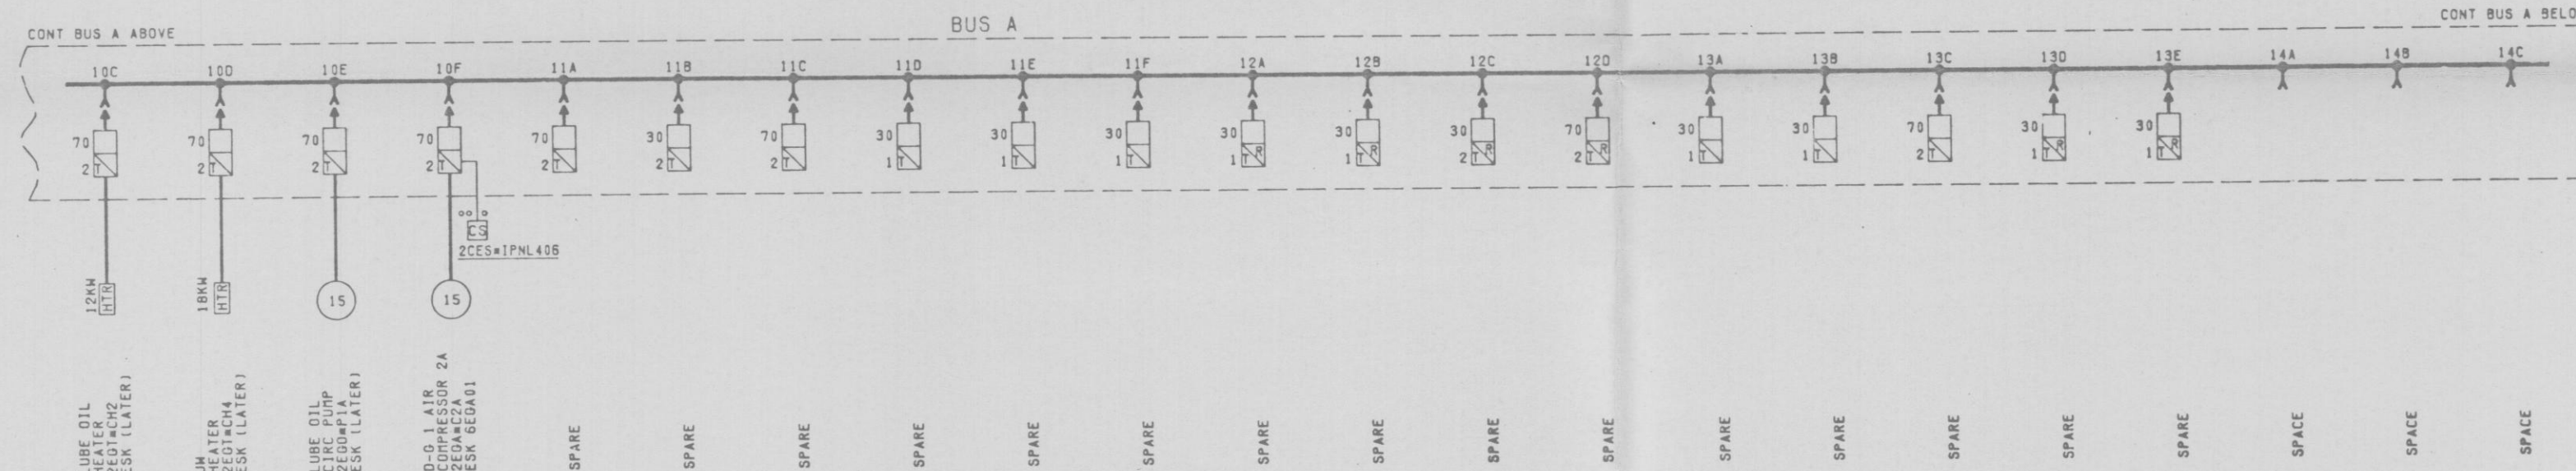
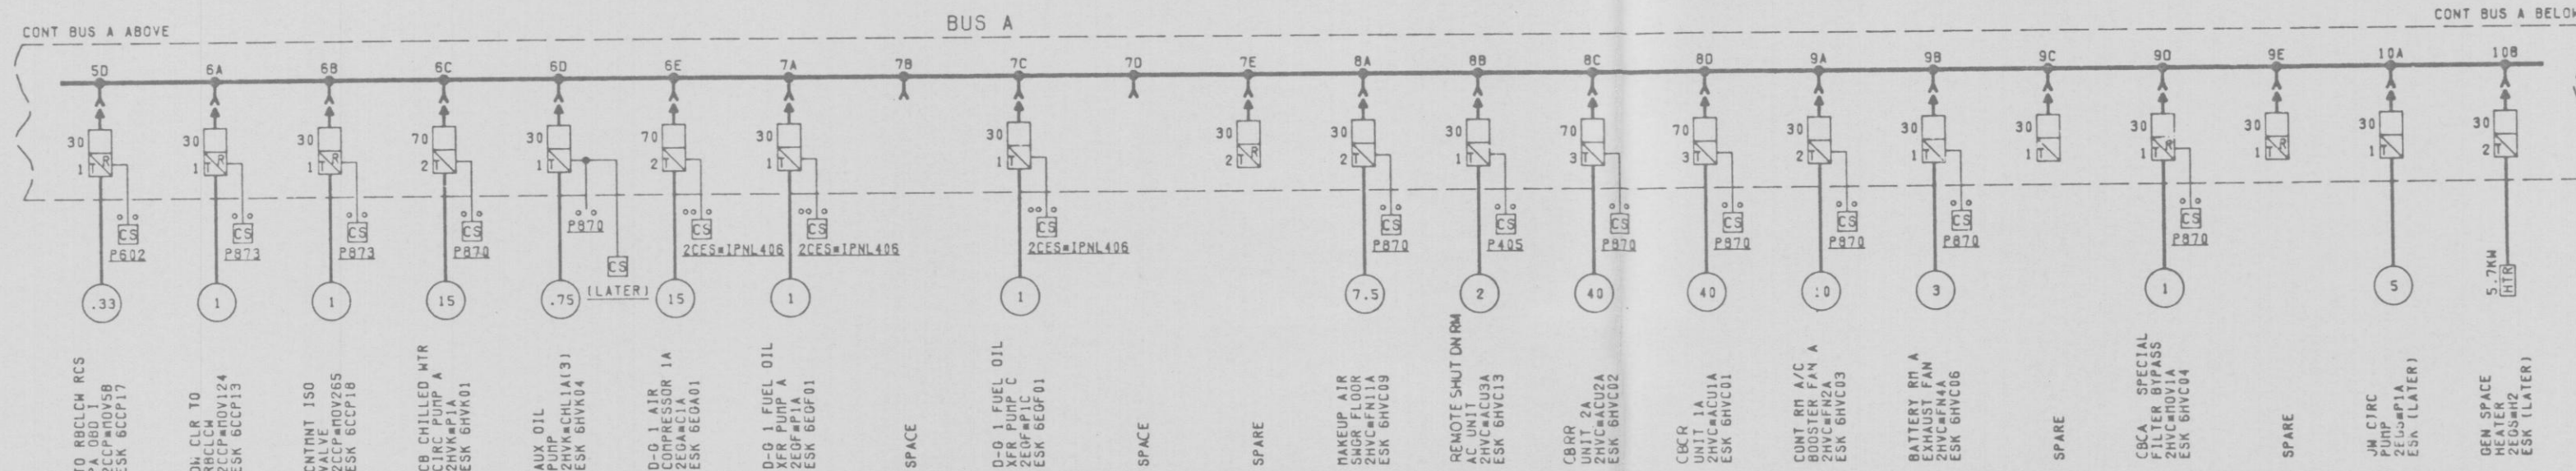


12177-EE-1AT-3

2EHS-MCC103 (CONTROL ROOM BUILDING) EL-261'-0" GREEN

BUS A

CONT BUS A BELOW

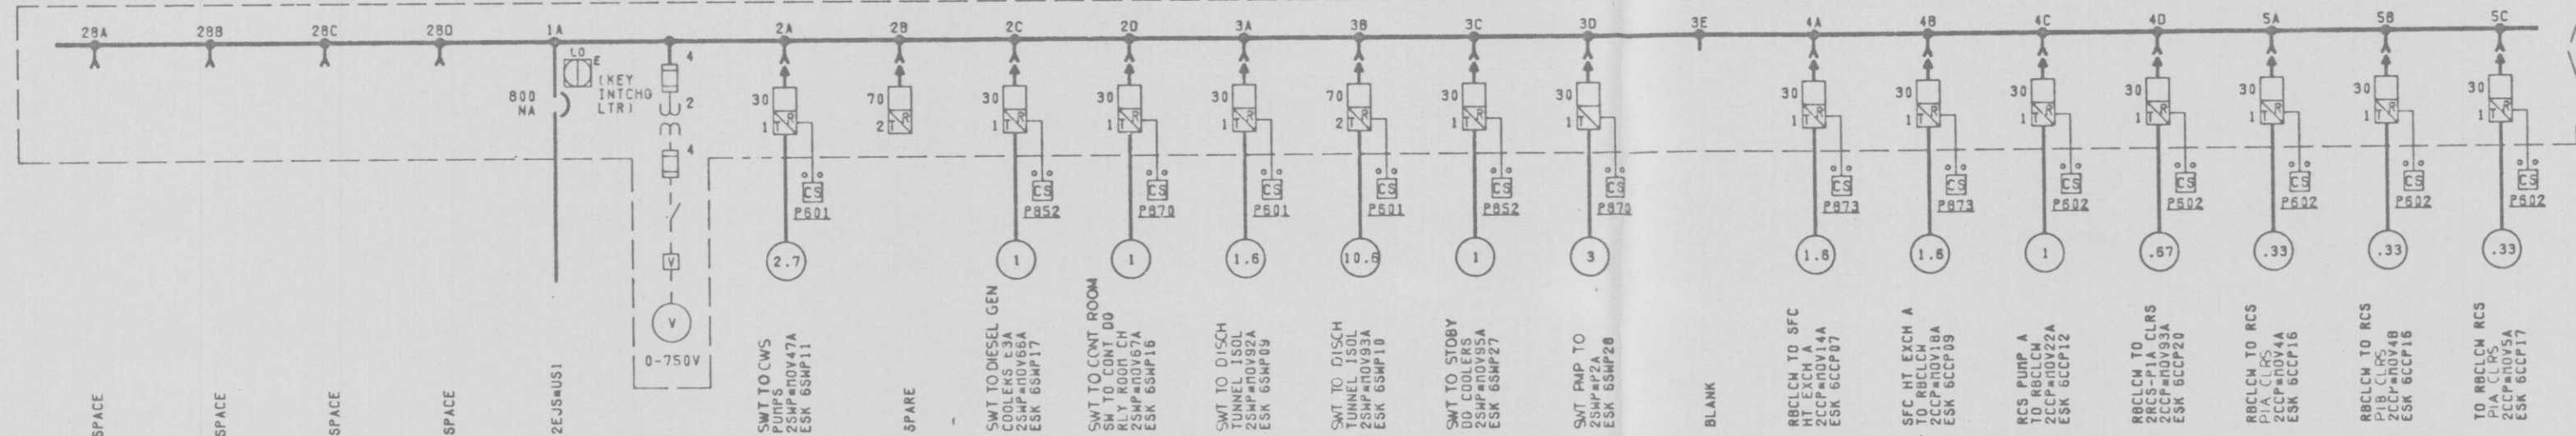

NOTES:
1. GENERAL NOTES, REFERENCES, ADDITIONAL SYMBOLS & LOCATION SYMBOLS EE-1AA.

PRO APERTURE CARD

APPROVED *K. Khanna*
LICENSED PROFESSIONAL ENGINEER, NO. 53786
ALTERATION EXCEPT BY A LICENSED PROFESSIONAL ENGINEER IS ILLEGAL

NUCLEAR SAFETY RELATED
QA CAT I

600V ONE LINE DIAGRAM
2EHS-MCC103 BUS-A
CONTROL ROOM BUILDING
NINE MILE POINT NUCLEAR STATION-UNIT 2
NIAGARA MOHAWK POWER CORPORATION
STONE & WEBSTER ENGINEERING CORPORATION
CHERRY HILL, N.J.

DRAWING NUMBER 12177-EE-1AT-3
DESIGNED BY J. DAVIS DRAWN BY D. BAWLEY
CHECKED BY C. HENDERSON

THE INFORMATION ON THIS DRAWING MAY NOT BE COPIED OR USED FOR OTHER THAN THE CONSTRUCTION, MAINTENANCE OR REPAIR OF THE PLANT FACILITY DESCRIBED IN THE TITLE BLOCK.

REVISED & REDRAWN	REVISION	DATE	BY	CHKD
1	REVISED	11/76	J. DAVIS	J. DAVIS
2	REVISED	11/76	J. DAVIS	J. DAVIS
3	REVISED	11/76	J. DAVIS	J. DAVIS
4	REVISED	11/76	J. DAVIS	J. DAVIS
5	REVISED	11/76	J. DAVIS	J. DAVIS
6	REVISED	11/76	J. DAVIS	J. DAVIS
7	REVISED	11/76	J. DAVIS	J. DAVIS
8	REVISED	11/76	J. DAVIS	J. DAVIS
9	REVISED	11/76	J. DAVIS	J. DAVIS
10	REVISED	11/76	J. DAVIS	J. DAVIS
11	REVISED	11/76	J. DAVIS	J. DAVIS
12	REVISED	11/76	J. DAVIS	J. DAVIS
13	REVISED	11/76	J. DAVIS	J. DAVIS
14	REVISED	11/76	J. DAVIS	J. DAVIS
15	REVISED	11/76	J. DAVIS	J. DAVIS
16	REVISED	11/76	J. DAVIS	J. DAVIS
17	REVISED	11/76	J. DAVIS	J. DAVIS
18	REVISED	11/76	J. DAVIS	J. DAVIS
19	REVISED	11/76	J. DAVIS	J. DAVIS
20	REVISED	11/76	J. DAVIS	J. DAVIS
21	REVISED	11/76	J. DAVIS	J. DAVIS
22	REVISED	11/76	J. DAVIS	J. DAVIS
23	REVISED	11/76	J. DAVIS	J. DAVIS
24	REVISED	11/76	J. DAVIS	J. DAVIS
25	REVISED	11/76	J. DAVIS	J. DAVIS
26	REVISED	11/76	J. DAVIS	J. DAVIS
27	REVISED	11/76	J. DAVIS	J. DAVIS
28	REVISED	11/76	J. DAVIS	J. DAVIS
29	REVISED	11/76	J. DAVIS	J. DAVIS
30	REVISED	11/76	J. DAVIS	J. DAVIS

REVISION
1
2
3
4
5
6
7
8
9
10
11
12
13
14
15
16
17
18
19
20
21
22
23
24
25
26
27
28
29
30