



12177-EE-1AR-3

2EHS-MCC102 (AUX BUILDING NORTH) EL-240'-0" GREEN

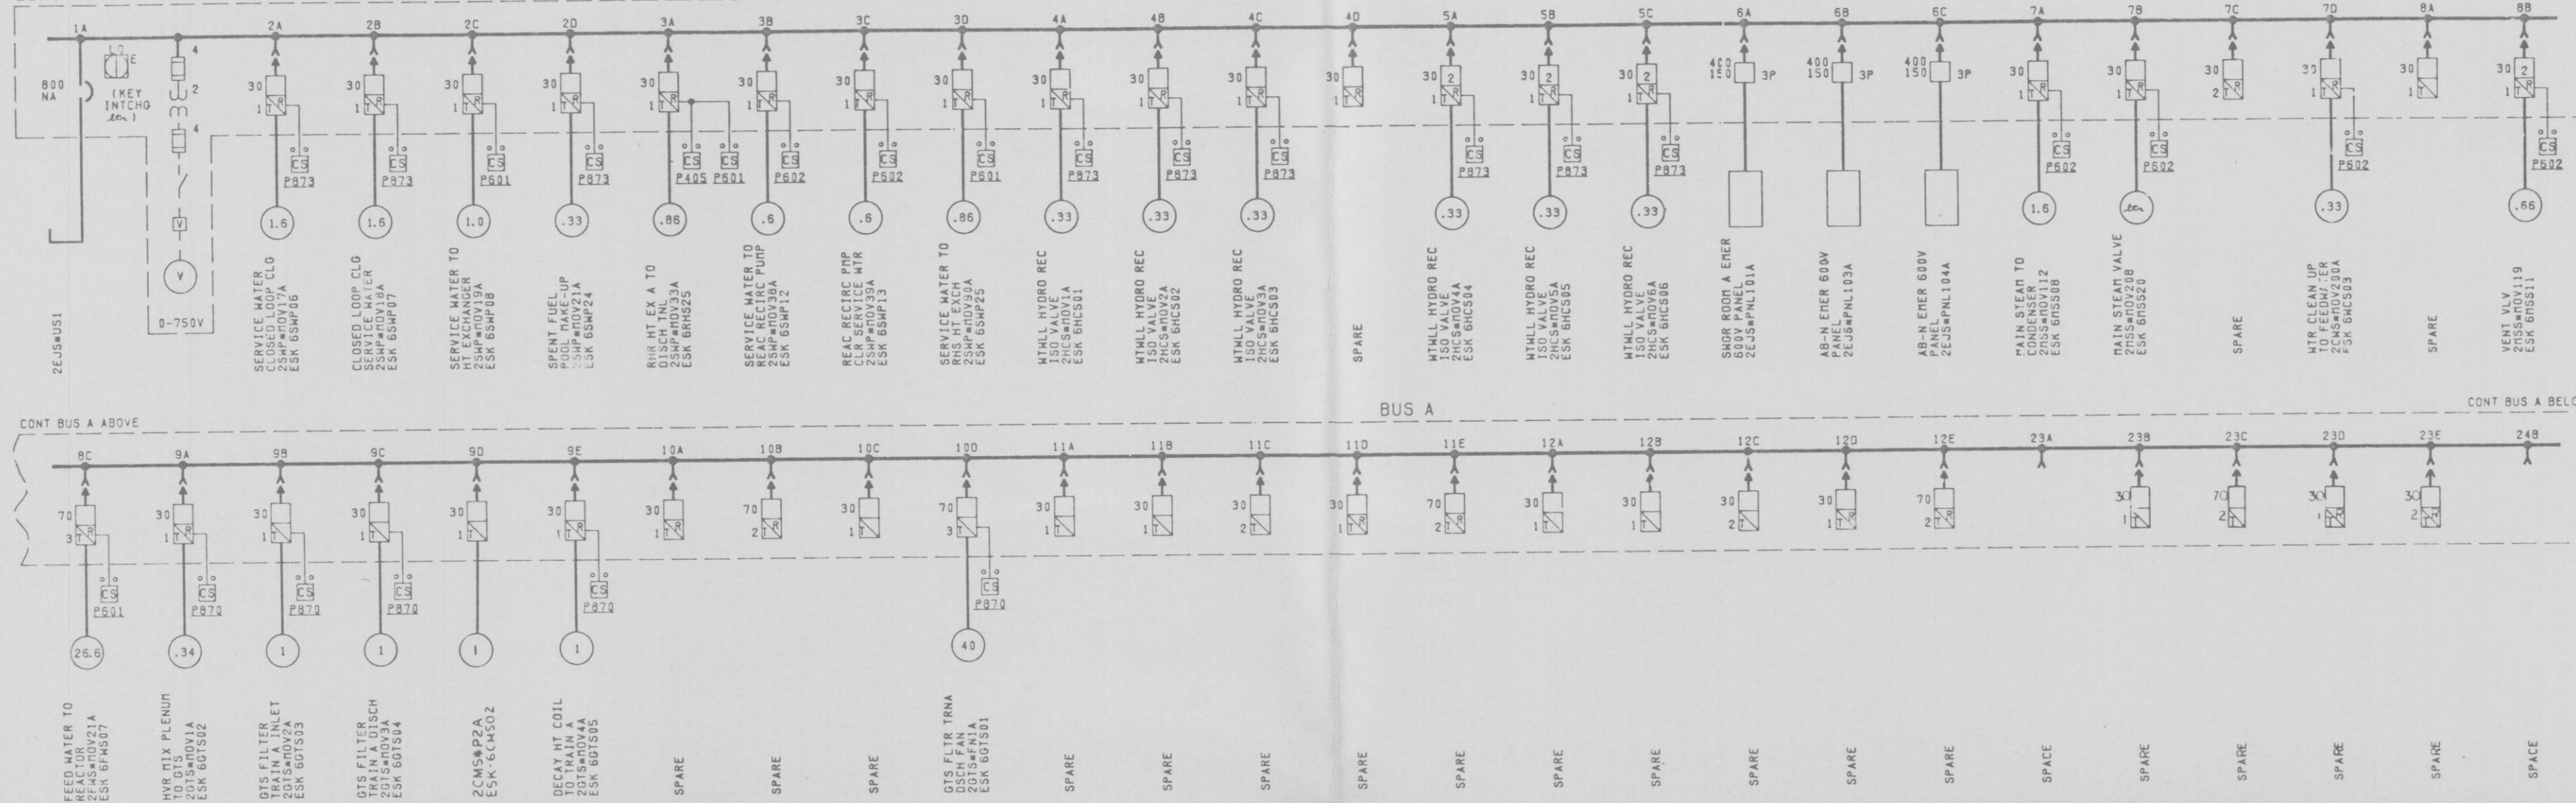

2EHS-MCC102 (AUXILIARY BLDG NORTH) EL-240'-0" GREEN

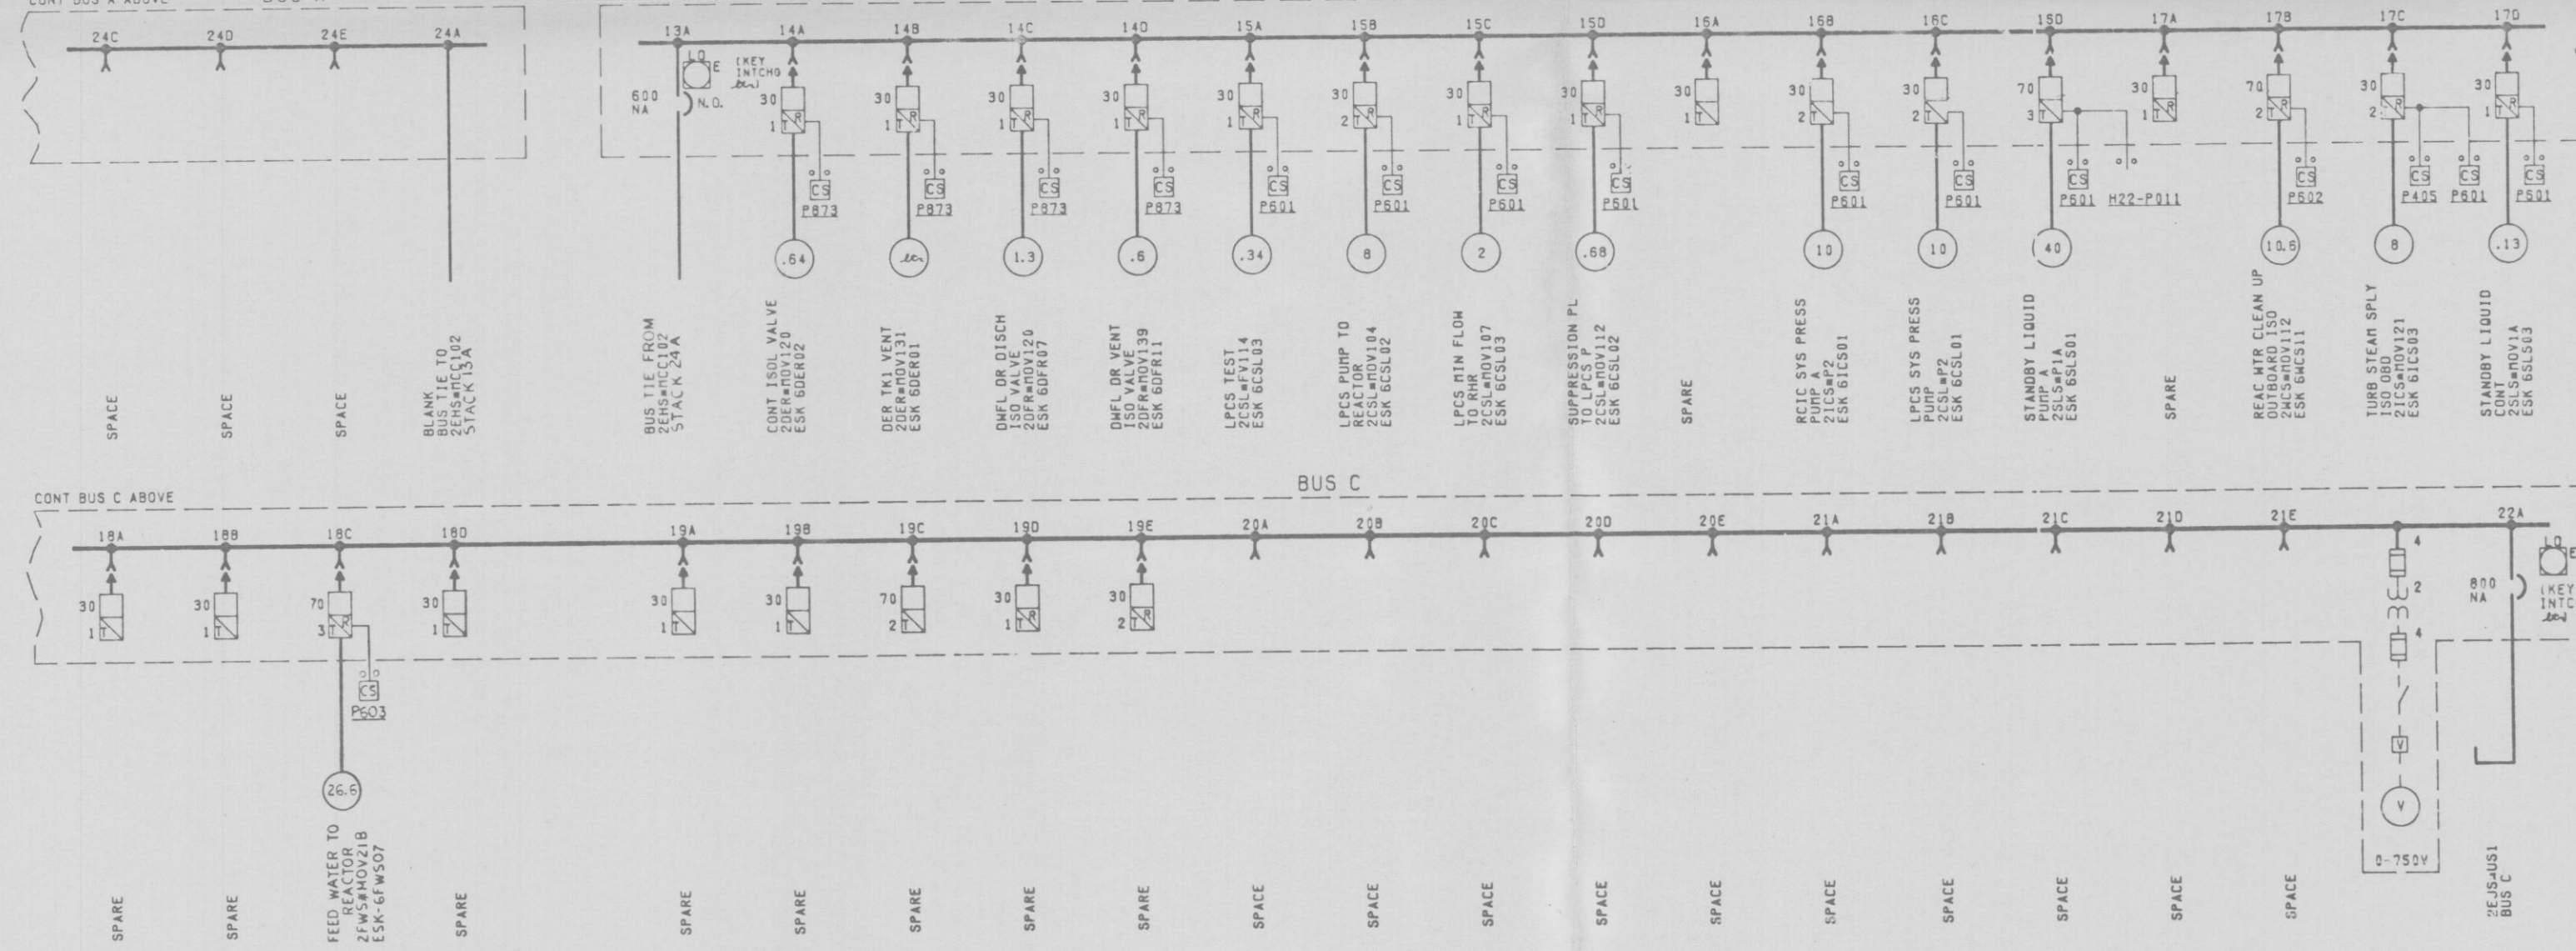

NOTES:
1. GENERAL NOTES, REFERENCES,
ADDITIONAL SYMBOLS & LOCATION
SYMBOLS EE-1A.

PRO
APERTURE
CARD



APPROVED *J. Davis*
LICENSED PROFESSIONAL ENGINEER NO. 55786
ALTERATION EXCEPT BY A LICENSED PROFESSIONAL ENGINEER IS ILLEGAL

NUCLEAR SAFETY RELATED
QA CAT I

600V ONE LINE DIAGRAM
2EHS-MCC102
AUXILIARY BUILDING NORTH
NINE MILE POINT NUCLEAR STATION-UNIT 2
NIAGARA MOHAWK POWER CORPORATION
STON & WEBSTER ENGINEERING CORPORATION
CHERRY HILL, N.J.
DRAWING NUMBER 12177-EE-1AR-3

THE INFORMATION ON THIS DRAWING MAY NOT BE COPIED
OR USED FOR OTHER THAN THE CONSTRUCTION,
MAINTENANCE OR REPAIR OF THE PLANT FACILITY
DESCRIBED IN THE TITLE BLOCK.

REVISION	DESCRIPTION	DATE	BY	CHKD
1	REVISED & REDRAWN	11-21-71	J. DAVIS	J. DAVIS
2	SUPERSEDED BY DRAWING EE-1AR-3			
3	ORIGINAL ISSUE FOR ENGINEERING ONLY			

NO.	DESCRIPTION	DATE	BY	CHKD
1	DESIGNED BY J. DAVIS			
2	DRAWN BY G. BAKLEY			
3	CHECKED BY C. HENDERSON			
4	APPROVED BY J. DAVIS			

NO.	DESCRIPTION	DATE	BY	CHKD
1	DESIGNED BY J. DAVIS			
2	DRAWN BY G. BAKLEY			
3	CHECKED BY C. HENDERSON			
4	APPROVED BY J. DAVIS			