



12177-EE-1A0-3

2EHS-MCC101 (SCREENWELL BUILDING) EL-261'-0" GREEN

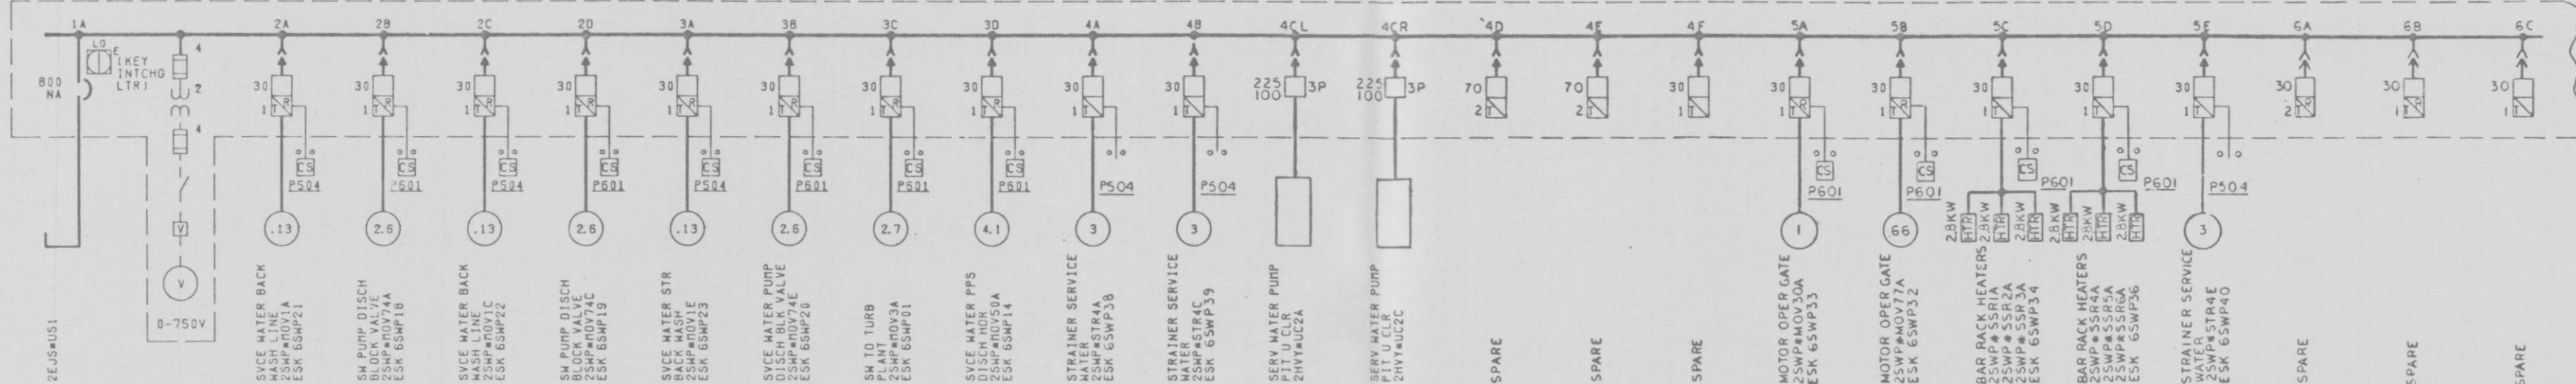


CONT 2EHS-MCC101 ABOVE

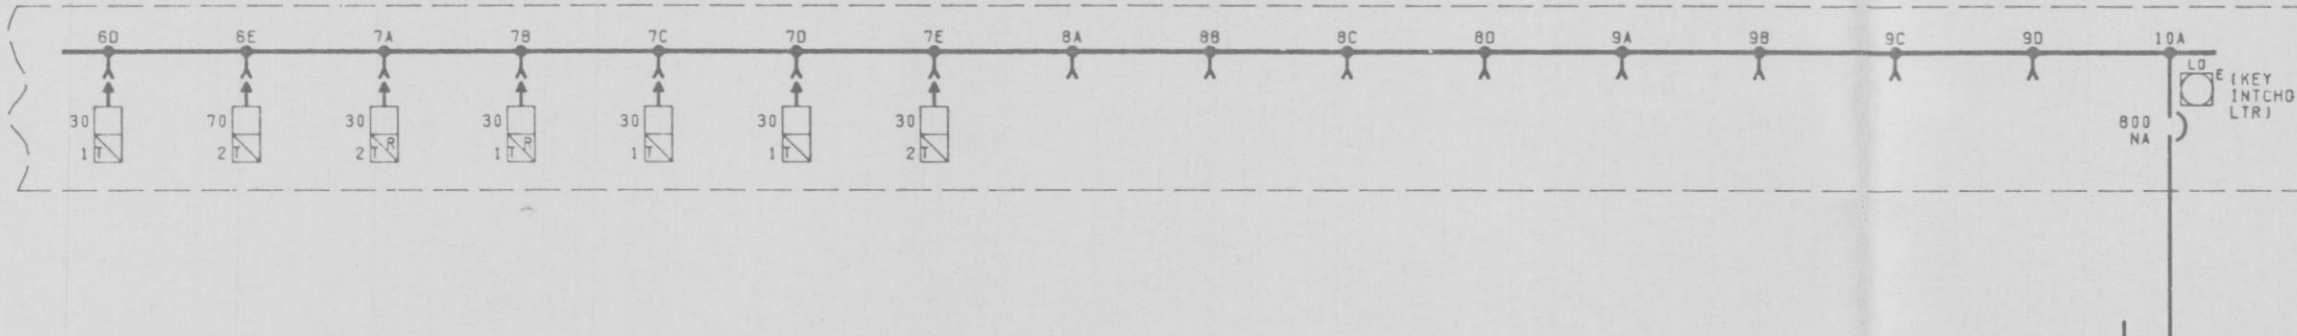


NOTES:
1. GENERAL NOTES, REFERENCES,
ADDITIONAL SYMBOLS & LOCATION
SYMBOLS EE-1AA.

2EHS-MCC301 (SCREENWELL BUILDING) EL-261'-0" YELLOW

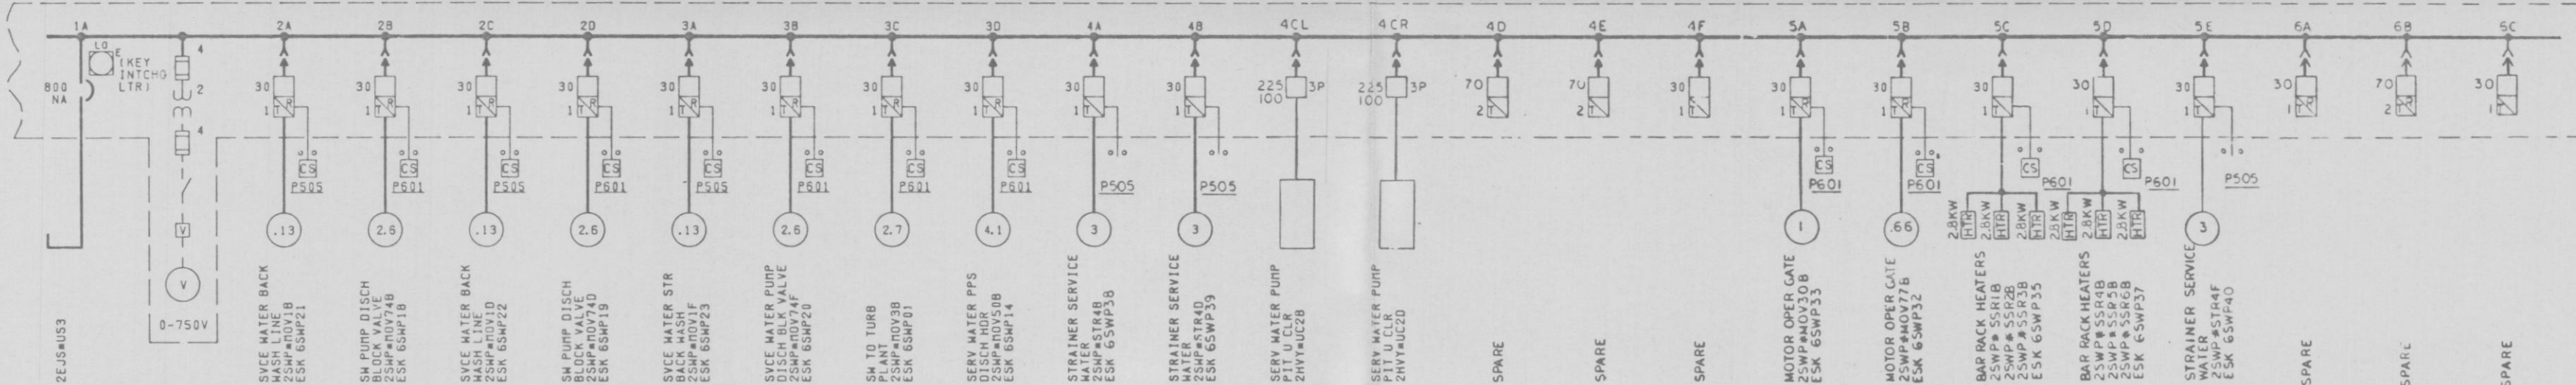

CONT 2EHS-MCC301 ABOVE

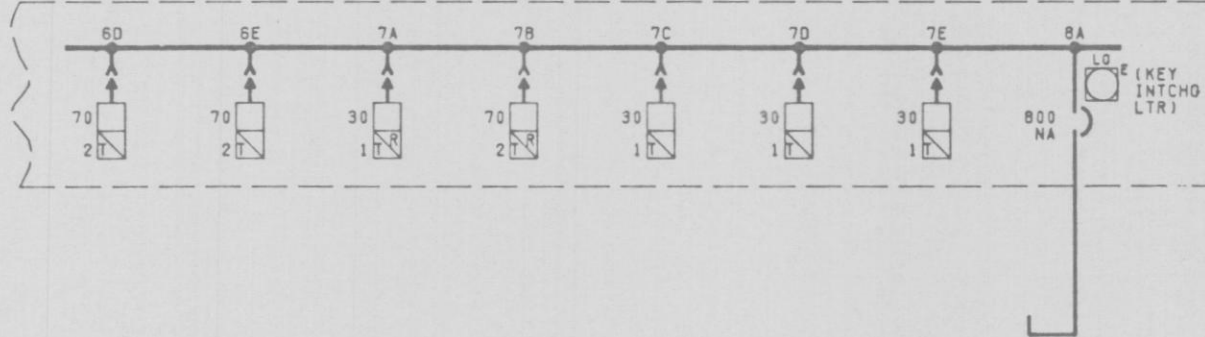

PRC
APERTURE
CARD



APPROVED *J. Davis*
LICENSED PROFESSIONAL ENGINEER, NO. 55786
ALTERNATE EXCEPT BY A LICENSED PROFESSIONAL ENGINEER IN ILLINOIS

NUCLEAR SAFETY RELATED
QA CAT I

600V ONE LINE DIAGRAM
2EHS-MCC101 & 2EHS-MCC301
SCREENWELL BUILDING
NINE MILE POINT NUCLEAR STATION-UNIT 2
NIAGARA MOHAWK POWER CORPORATION
STONE & WEBSTER ENGINEERING CORPORATION
CHERRY HILL, N.J.
CH DRAWING NUMBER 12177-EE-1A0-3
DESIGNED BY J. DAVIS DRAWN BY G. BAKLEY
CHECKED BY C. HENDERSON CHECKED BY J. DAVIS

THE INFORMATION ON THIS DRAWING IS NOT TO BE COPIED
OR USED FOR OTHER THAN THE CONSTRUCTION,
MAINTENANCE OR REPAIR OF THE PLANT FACILITY
DESCRIBED IN THE TITLE BLOCK.

REVISION	DESCRIPTION	DATE	BY	CHKD
1	REVISED & REDRAWN	11/21/82	J. DAVIS	J. DAVIS
2	SUPERSEDED BY DWG EE-1A0-3	11/21/82	J. DAVIS	J. DAVIS

REVISION	DESCRIPTION	DATE	BY	CHKD
1	ORIGINAL ISSUE FOR ENGINEERING ONLY	11/21/82	J. DAVIS	J. DAVIS
2	FOR CONSTRUCTION	11/21/82	J. DAVIS	J. DAVIS

REVISION	DESCRIPTION	DATE	BY	CHKD
1	FOR CONSTRUCTION	11/21/82	J. DAVIS	J. DAVIS
2	FOR CONSTRUCTION	11/21/82	J. DAVIS	J. DAVIS