


12177-EE-1AL-3



NOTES:
1. GENERAL NOTES, REFERENCES, ADDITIONAL SYMBOLS & LOCATION SYMBOLS SEE-1AA.

PRC
APERTURE
CARD

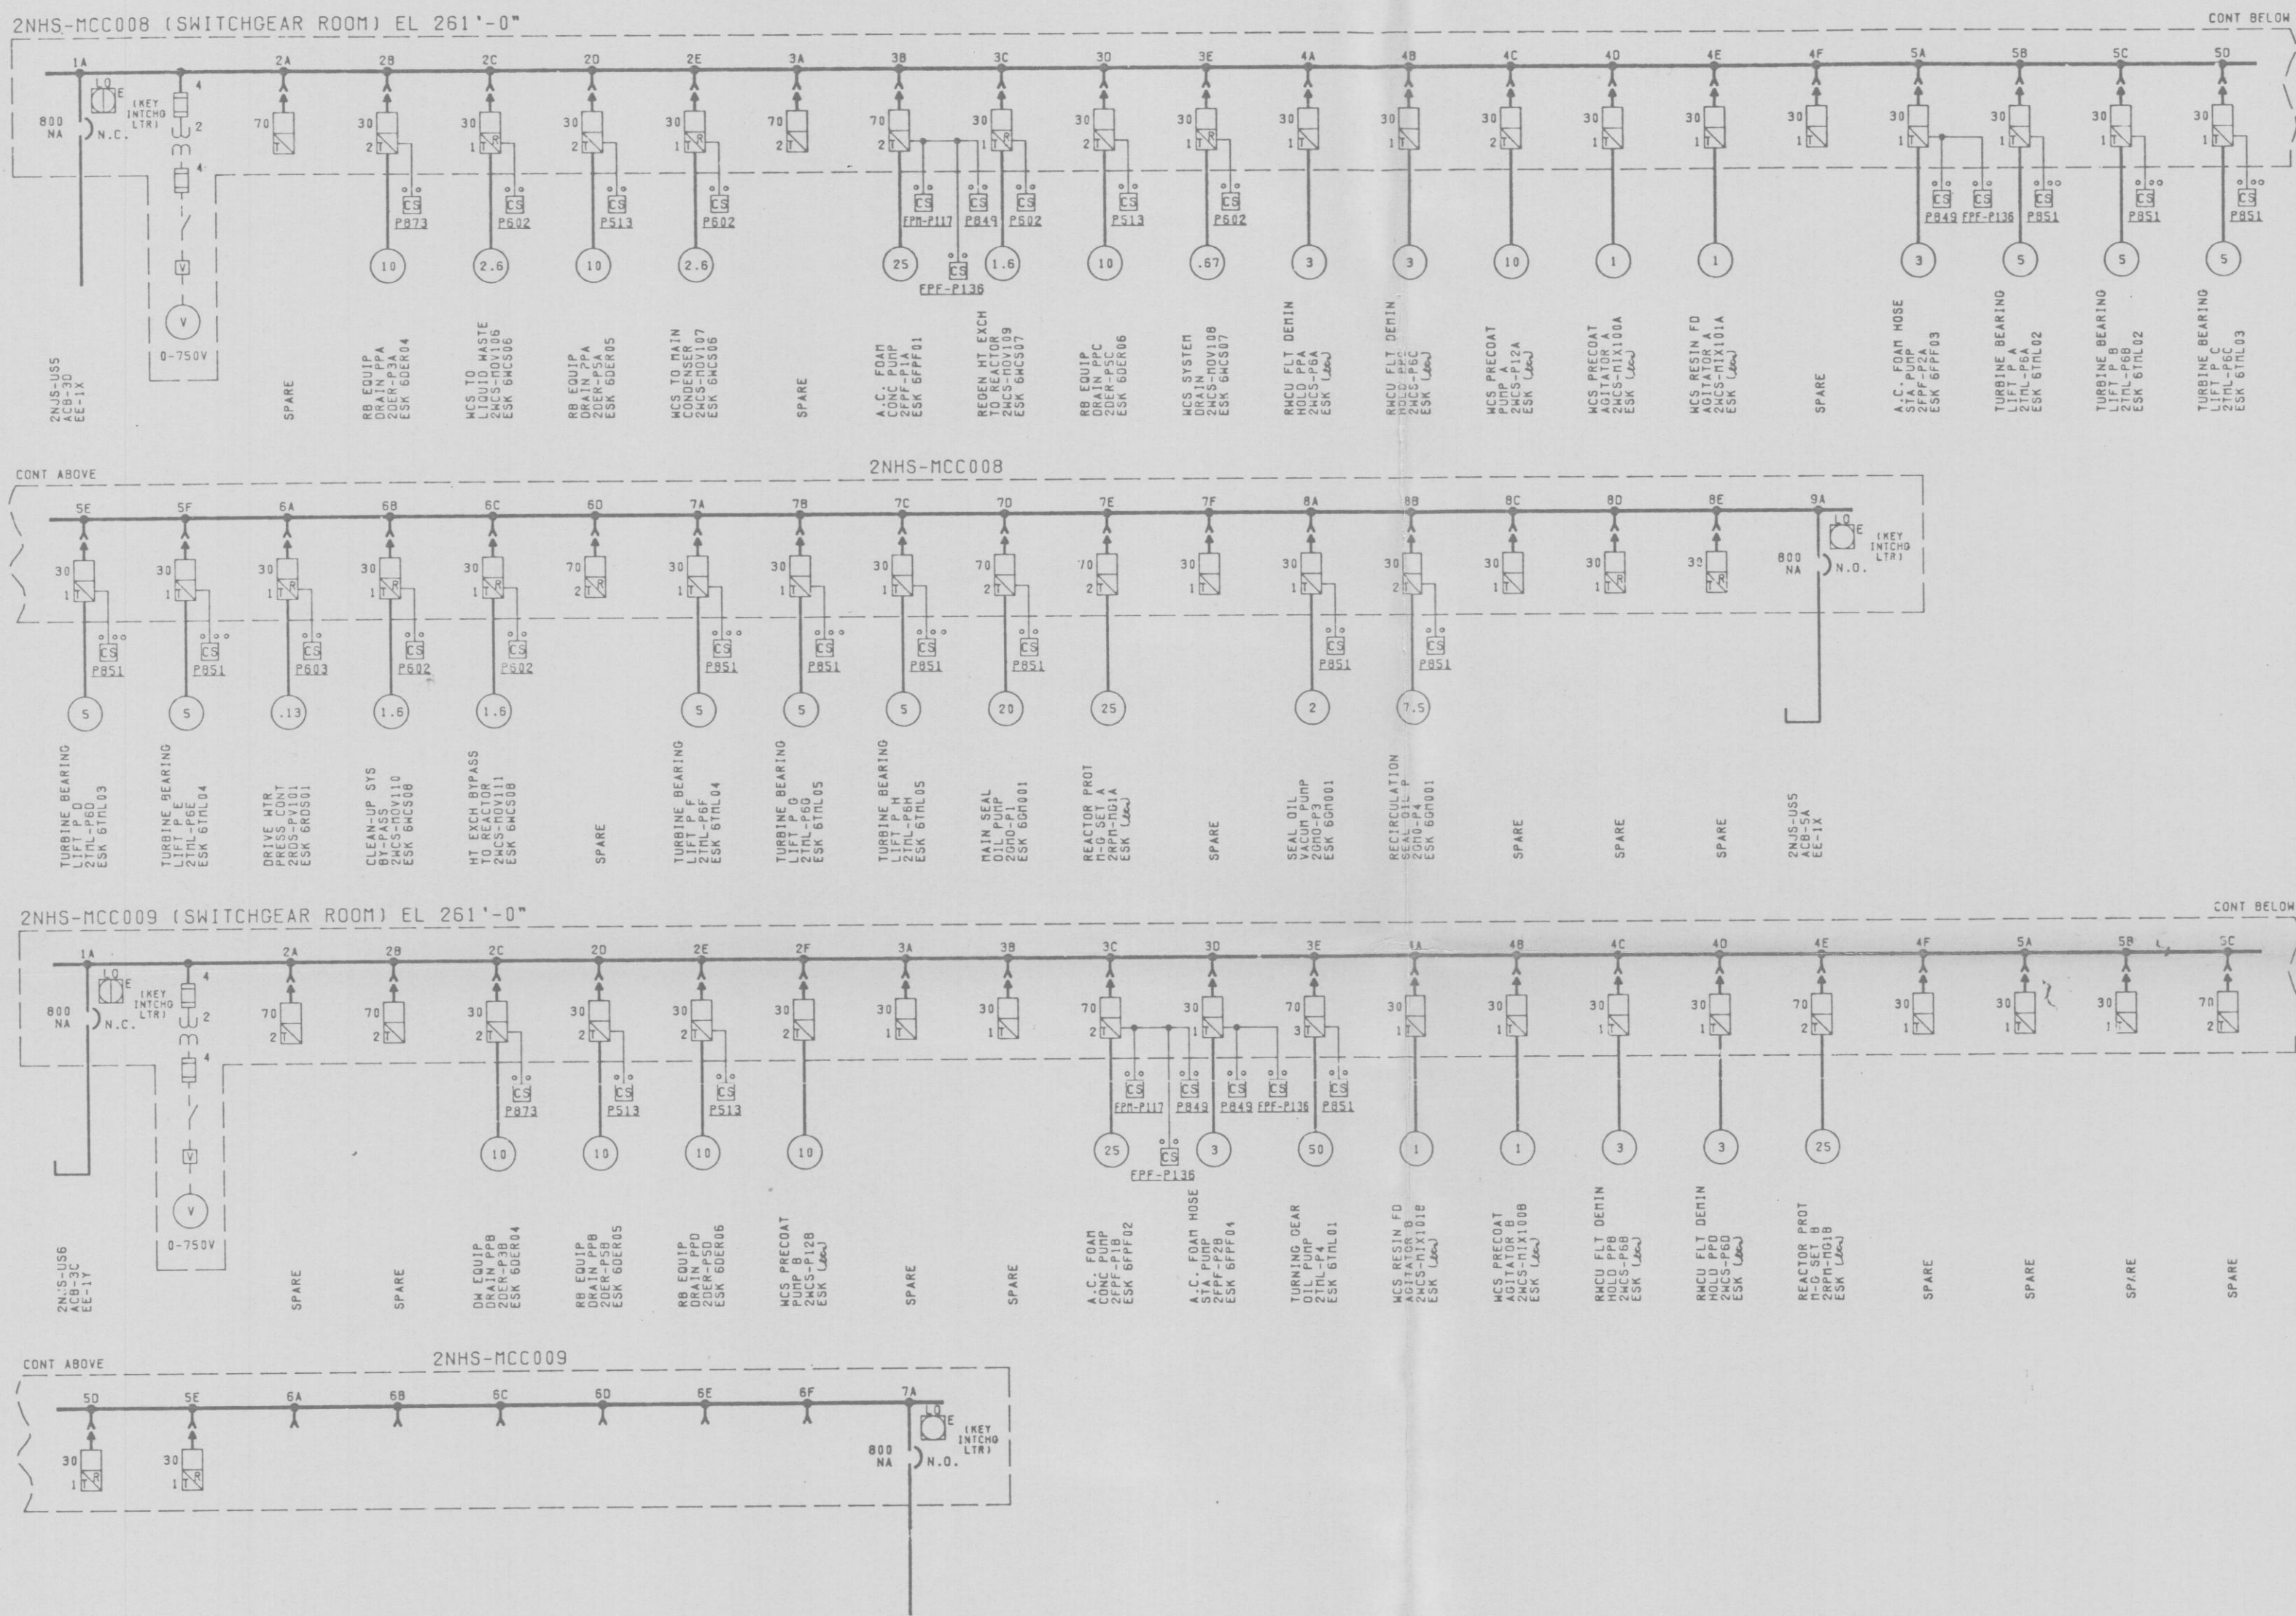

APPROVED *K. K. Kama*
LICENSED PROFESSIONAL ENGINEER, ME. 55784
ALTERATION EXCEPT BY A LICENSED PROFESSIONAL ENGINEER IS ILLEGAL

QA CAT II

600V ONE LINE DIAGRAM
2NHS-MCC008, 2NHS-MCC009
SWITCHGEAR ROOM
NINE MILE POINT NUCLEAR STATION-UNIT 2
NIAGARA MOHAWK POWER CORPORATION
STONE & WEBSTER ENGINEERING CORPORATION
CHERRY HILL, N.J.
DRAWING NUMBER 12177-EE-1AL-3

THE INFORMATION ON THIS DRAWING MAY NOT BE COPIED OR USED FOR OTHER THAN THE CONSTRUCTION, MAINTENANCE OR REPAIR OF THE PLANT FACILITY DESCRIBED IN THE TITLE BLOCK.

REVISIONS											
NO.	DESCRIPTION	DATE	BY	CHKD.	APP'D.	NO.	DESCRIPTION	DATE	BY	CHKD.	APP'D.
1	REVISED & REDRAWN	10/1/77	J. DAVIS			2	SUPERSEDED BY DWG. 12177-EE-1AL-3	10/1/77	J. DAVIS		
3	ORIGINAL ISSUE FOR ENGINEERING ONLY	10/1/77	J. DAVIS			4	ORIGINAL ISSUE FOR ENGINEERING ONLY	10/1/77	J. DAVIS		

DESIGNED BY J. DAVIS DRAWN BY K. PEAKE
CHECKED BY C. HENDERSON CHECKED BY J. DAVIS
4 33A