


A
B
C
D
E
F


REFERENCE DRAWINGS

- CELL SWITCH SHOWN WITH BREAK IN TEST POSITION DISCONNECTED
- TB427 - TERMINAL BOX 427
- TB428 - TERMINAL BOX 428
- RT1-1 REACTOR LOGIC TEST
- RT1-2 REACTOR LOGIC TEST
- RT1-3 REACTOR LOGIC TEST
- RT1-100 REACTOR LOGIC TEST


ONE LINE DIAGRAM

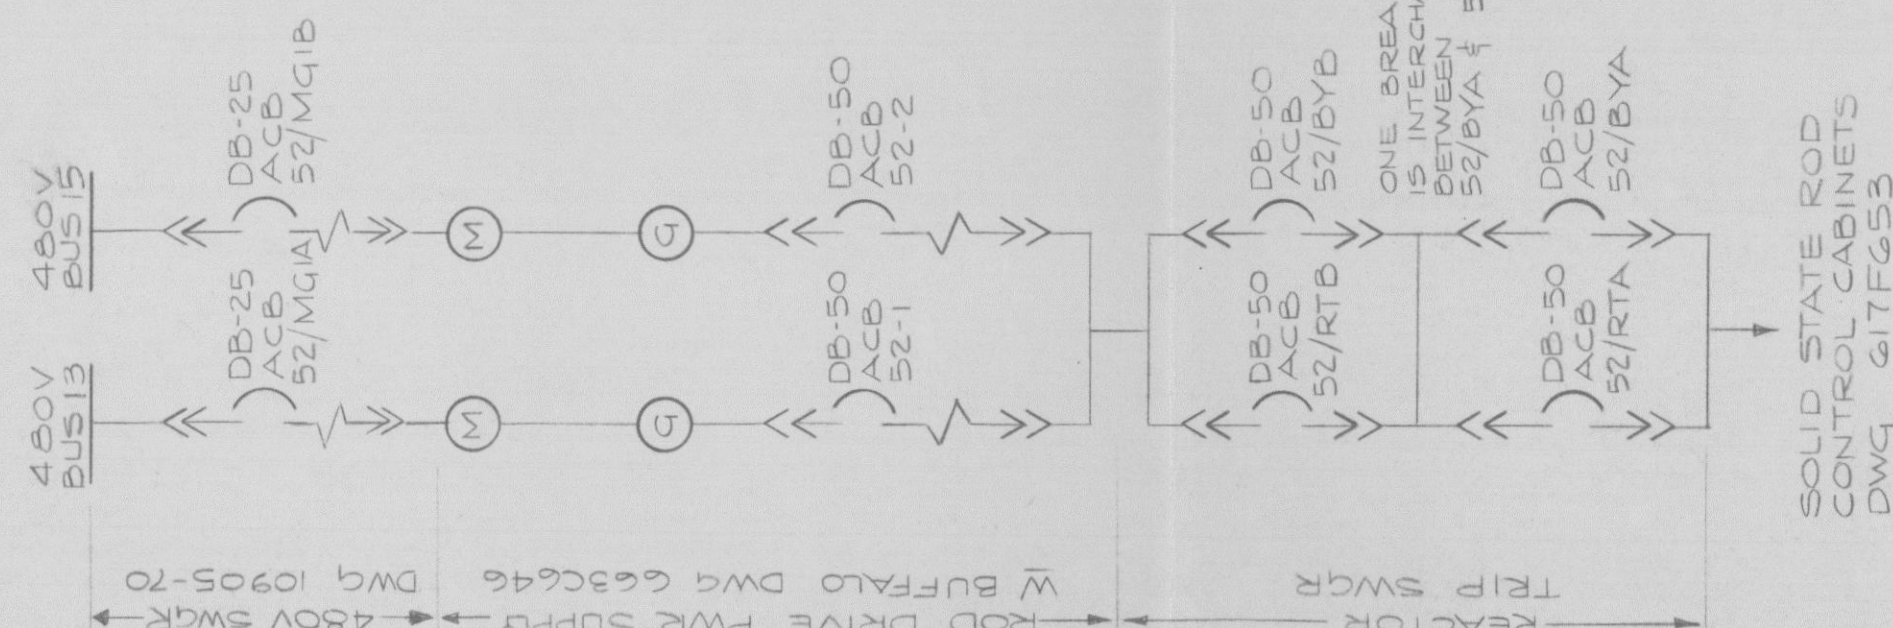


TRAIN A

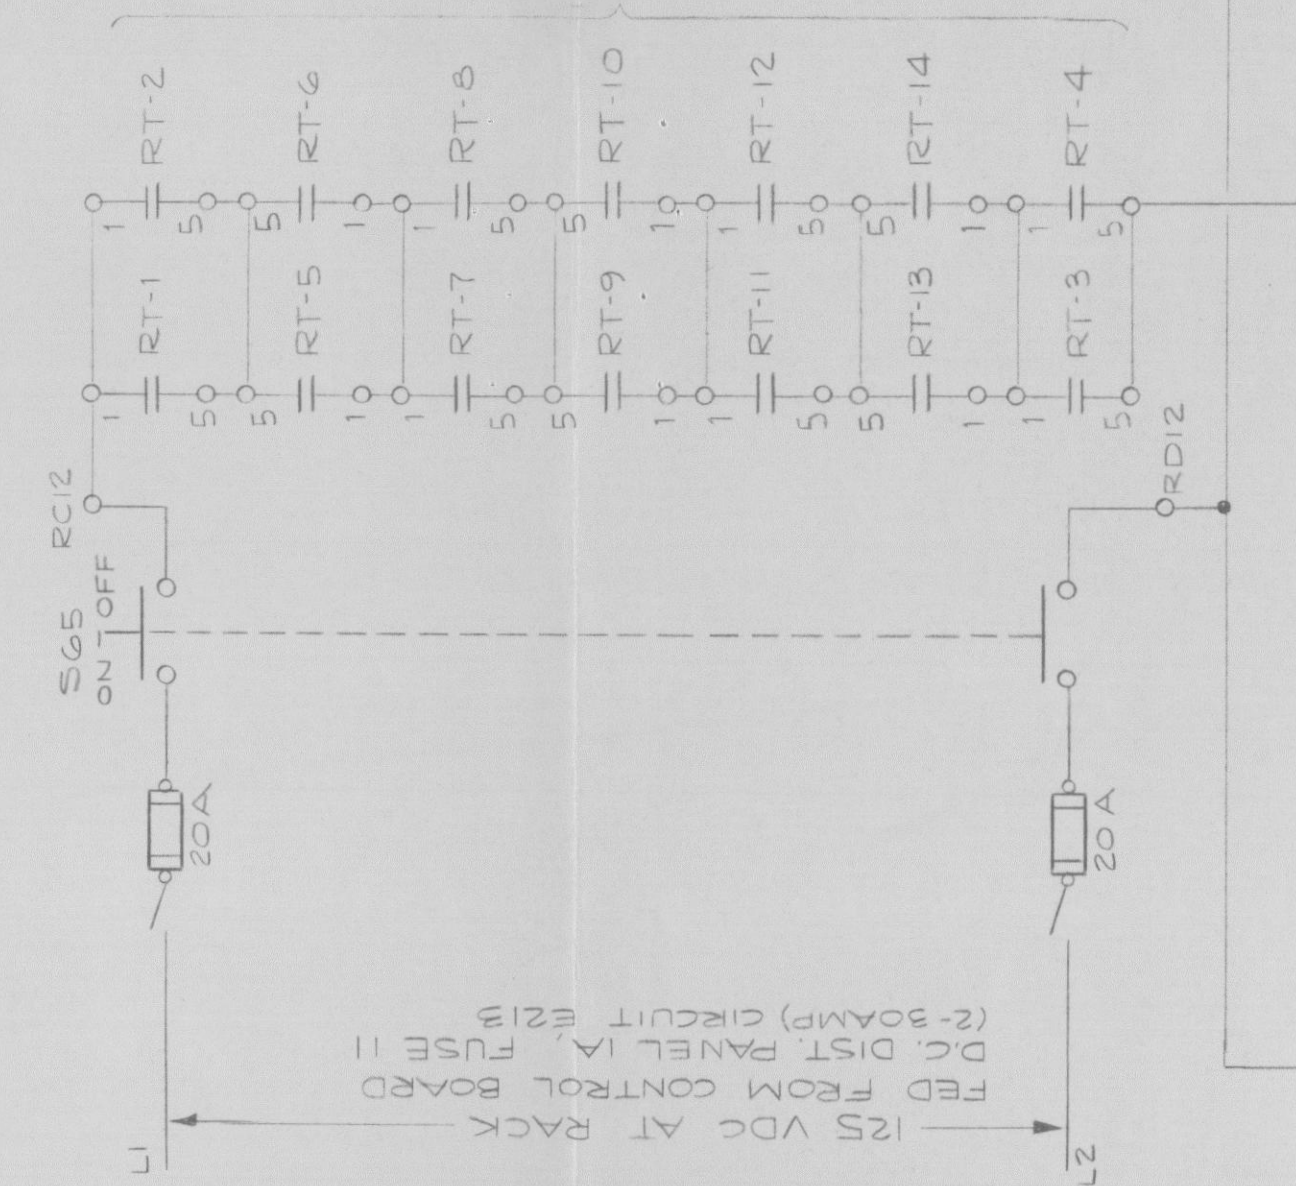

REF. DWG. 110E053 SH. 7

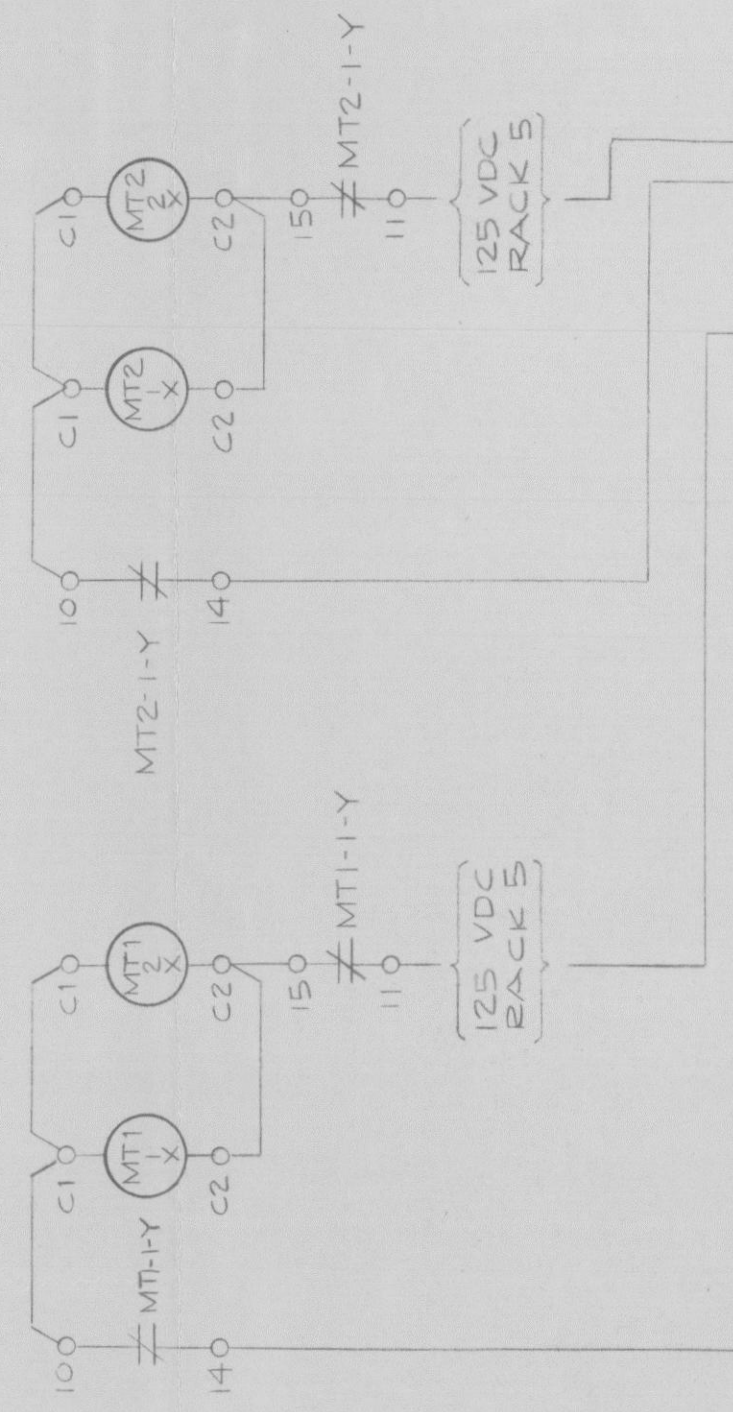

SOLID STATE ROD CONTROL CABINETS

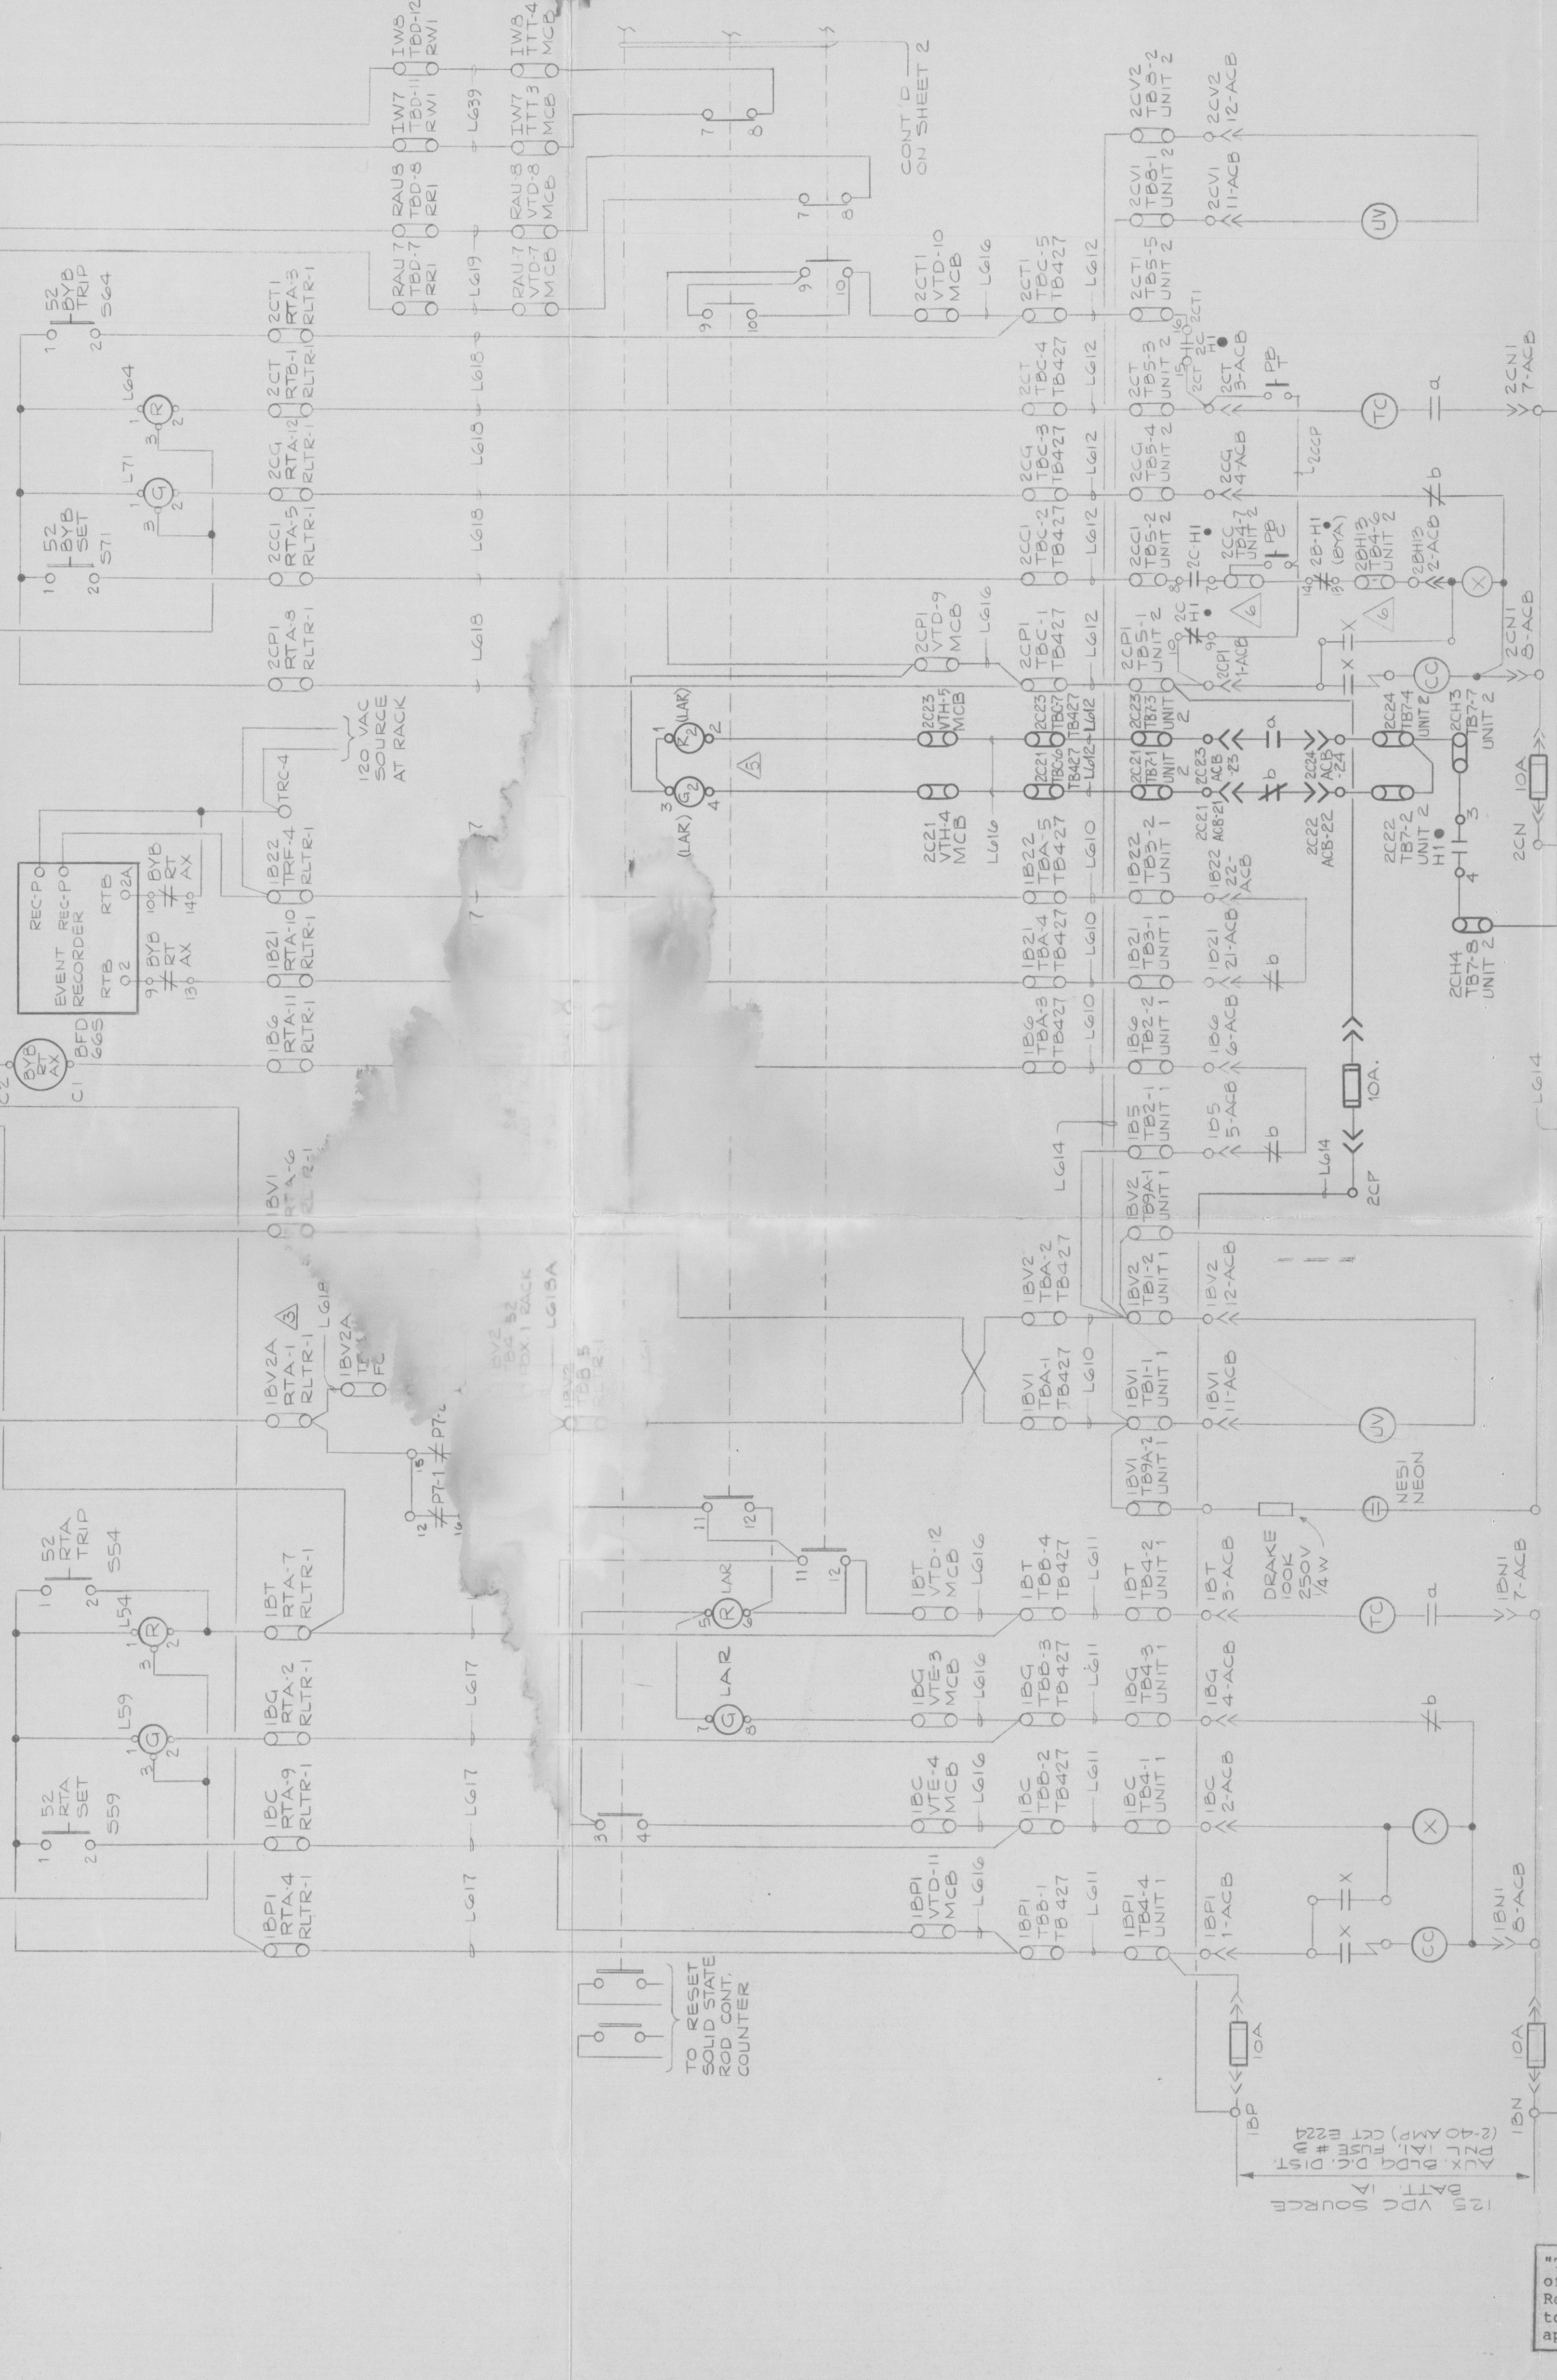

52/RTA

52/BYB

Docket # 58-244
Control # 8605210237
Date 7/15/86 of Document
REGULATORY DOCKET FILE

TI
APERTURE
CARD

"This drawing includes portions of Class 1E Electrical systems. Refer to notes and specifications to determine specific QA program applicability."

8605210237

POOR ORIGINAL

6	AS BUILT PER FCR 3698-B	EJD RLC	7-1-86	7-21-86
5	PER EWR 3698	DGS RLC	7-1-86	7-21-86
4	FCR 3698-2,3,5 & AS NOTED	D.G.S. EJD	7-1-86	7-21-86
3	EWR 3698	BR	7-1-86	7-21-86
2	EEDRAWN - 2 SHEETS AS BUILT	EJD	7-1-86	7-21-86
1	AS BUILT EWR 2709	RAA	7-1-86	7-21-86
0	ORIGINAL	DATE	3-7-77	3-7-77
NUMBER	REVISION	DRAWN BY	CHECKED	RESP. ENG. ENG. MGR.
CONSTRUCTION				
LIMITED CONSTRUCTION: AS NOTED				
PRELIMINARY NOT FOR CONSTRUCTION BIDDING PURPOSES				
7-1-86	AS BUILT	3698	7-1-86	7-1-86
DATE	RELEASED FOR	ENGR.		
FACILITY		ROCHESTER GAS & ELECTRIC CORP. ROCHESTER, NEW YORK		
REACTOR TRIP BREAKER CONTROL SCHEMATIC (SHEET 1 OF 3)				
JOB NO.	DRAWING NO.	REV.		
	33013-673 (SH. 1)			