


DRAWING NUMBER

10	REVISED
11-10-79	REPL
REDRA	WITH
REV P	EBASO

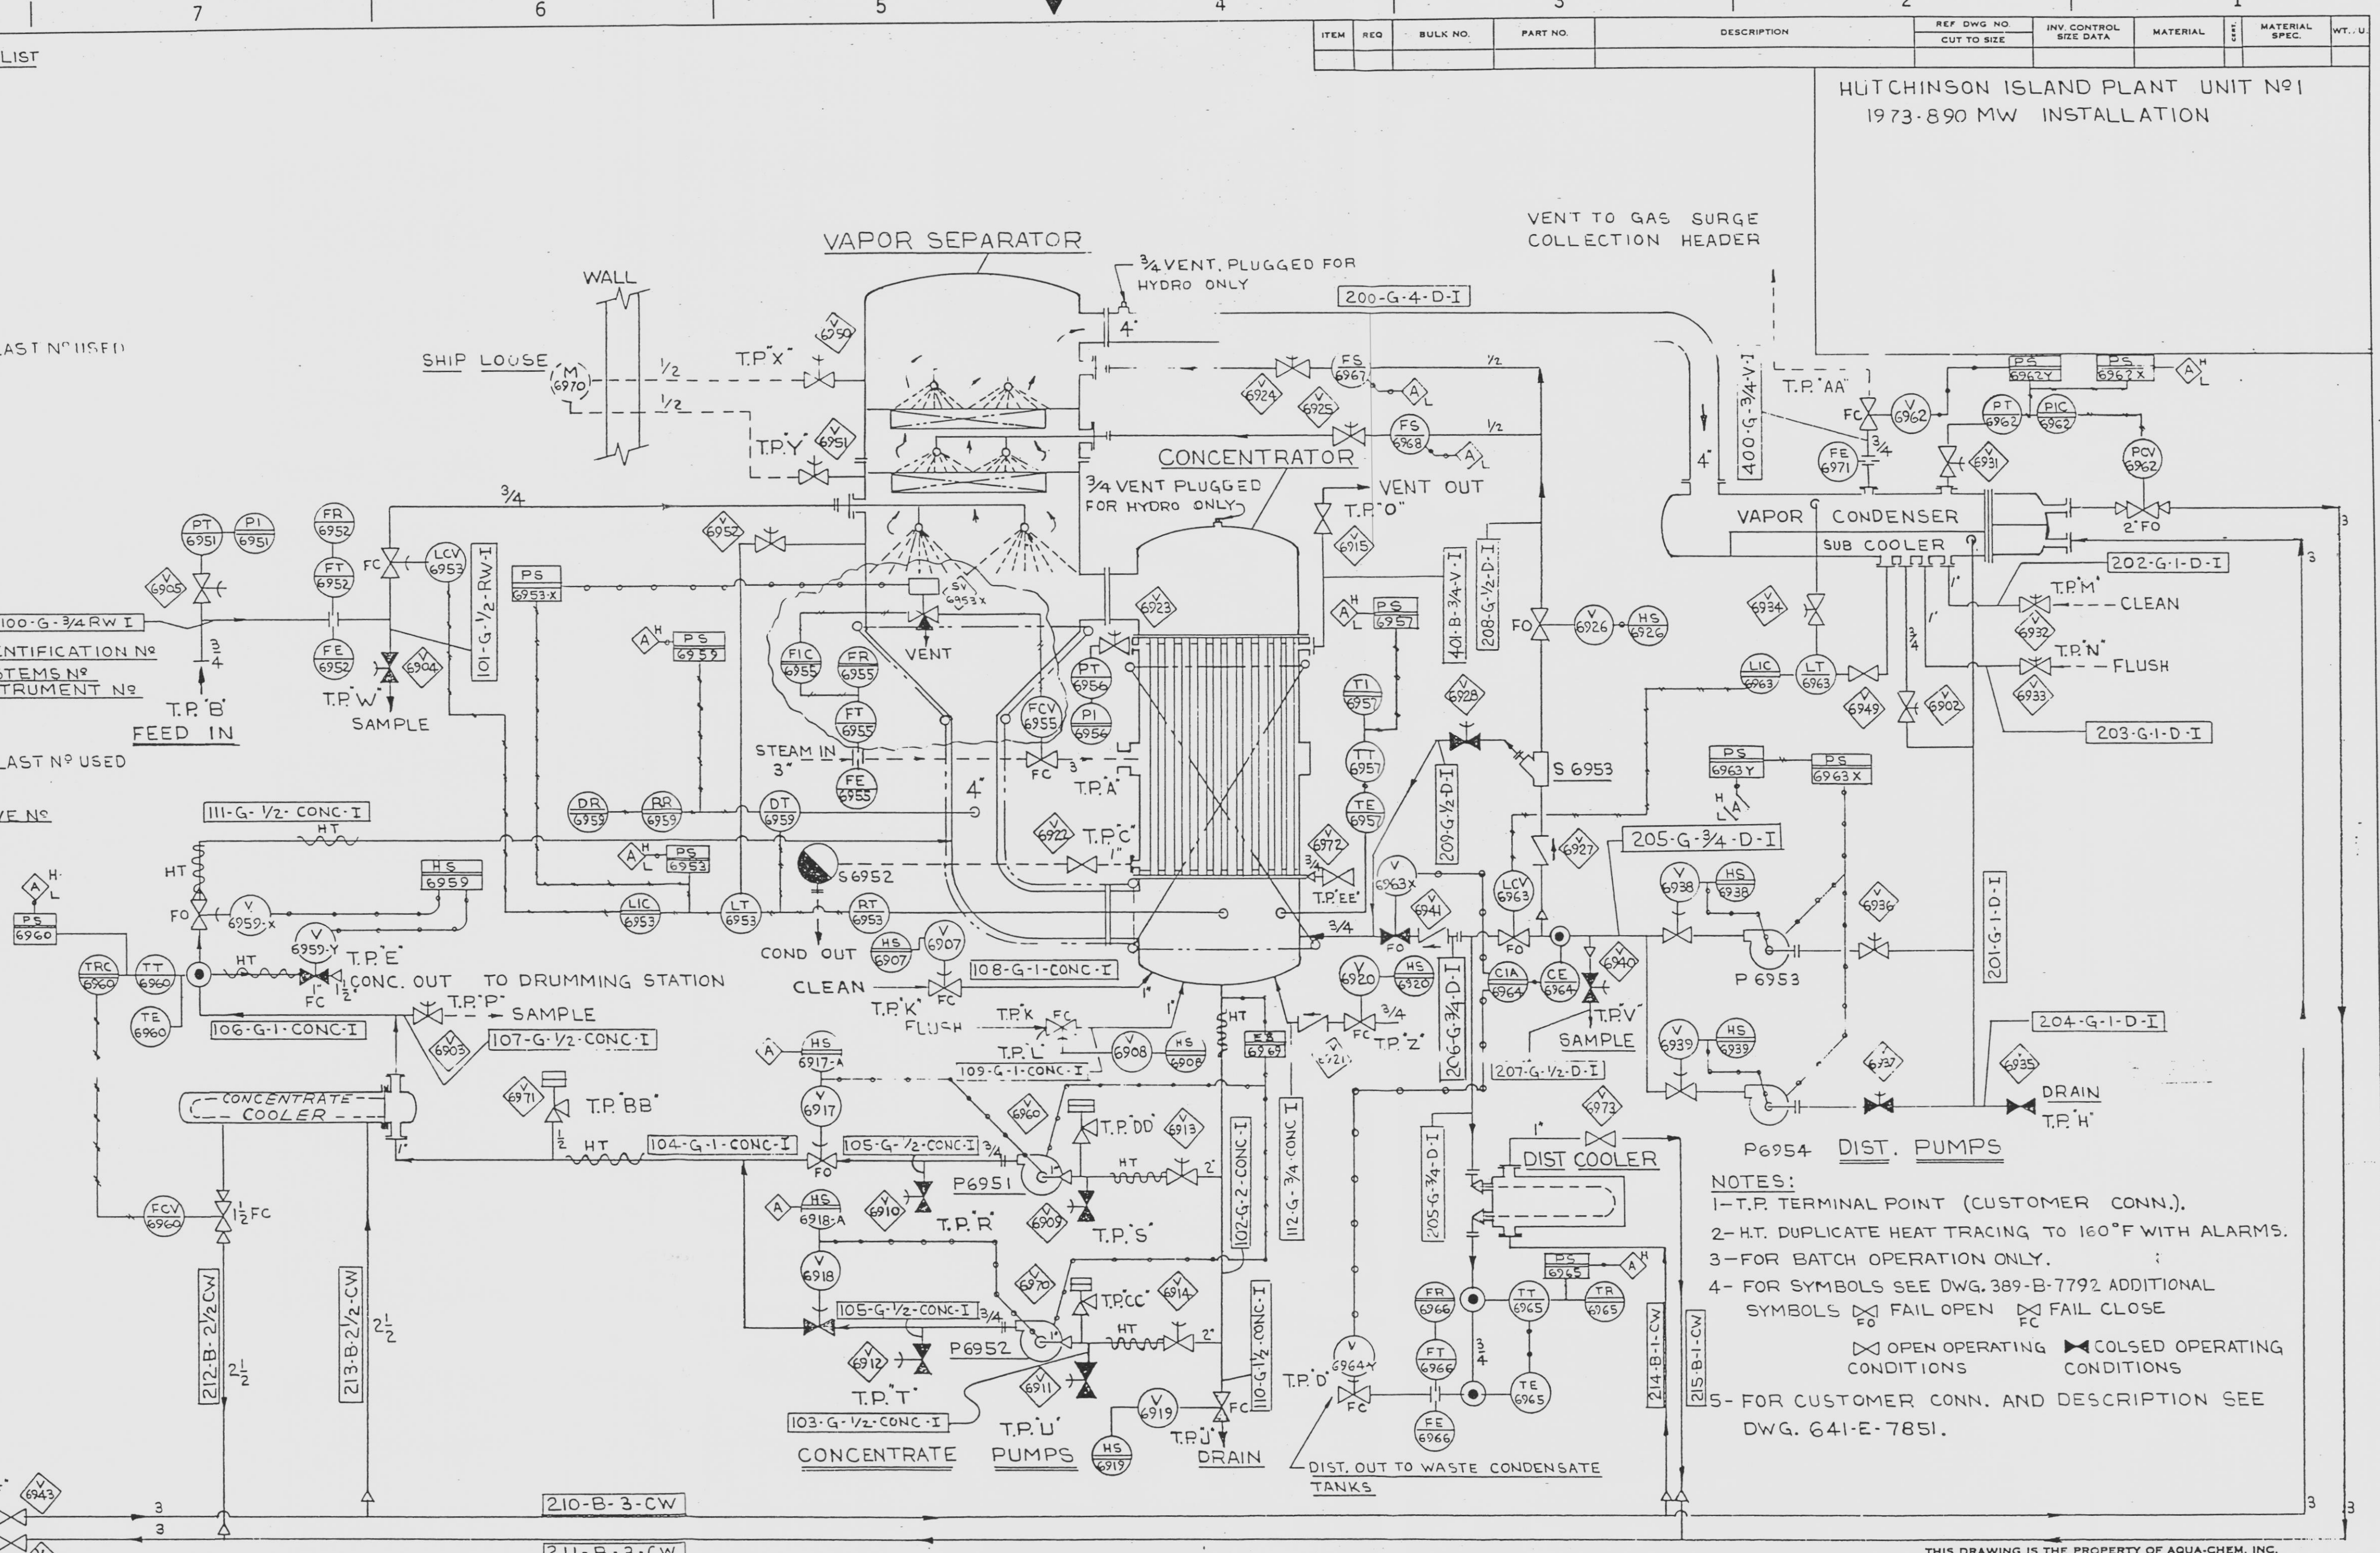

HUTCHINSON ISLAND PLANT UNIT No 1  
1973-890 MW INSTALLATION

[illegible]

EBASCO REV E 1

073	8770 - 351	R/I	11-15-97
FLORIDA POWER & LIGHT COMPANY HUTCHINSON ISLAND PLANT UNIT #1 1973 - 890 NW INSTALLATION			
P.O.	CE - 600	ITEM	
X SERIES	REVIEWED WITHOUT COMMENTS	*	1
	REVIEWED WITH COMMENTS AS NOTED *		2
	NOT APPLICABLE *		3
	NO COMMENTS, NO PRINT RETURNED		4
	FOR INFORMATION ONLY		5
X PROCESSED WITH	NO FURTHER REPRODUCTION REQUIRED		6
	RESUBMIT REPRODUCIBLE	SEE NOTE BELOW IF CHECKED <input type="checkbox"/>	7
	RESUBMIT CLOTH OR NYLON REPRODUCIBLE AS SHIPPED		8
	DO NOT PROCEED WITH FABRICATION		9

WASTE CONCENTRATOR -  
PIPING AND INSTRUMENTATION  
DIAGRAM

REVISED BY <b>TOLAN</b>	DATE <b>5/10/78</b>	ORIG. DIV. <b>M</b>	DATE TO COMPLET <b>12-9-78</b>
----------------------------	------------------------	------------------------	-----------------------------------

REVIEW OF THIS DOCUMENT WITH OR WITHOUT COMMENTS IS REQUIRED FOR GENERAL COORDINATION WITH CHARGES PREPARED FOR SPECIFICATIONS AND FOR CONFIRMATION OF PHYSICAL IN THE CASE OF ITEMS AND/OR WITH RELATED SYSTEMS. SUCH REVIEW SHALL BE SO FACILITATE CORRELATION WITH PHYSICAL RESPONSIBILITY FOR ENGINEERING, DESIGN, WORKMANSHIP, MATERIALS, PERFORMANCE OF EQUIPMENT AND MATERIALS, AND ALL OTHER LIABILITY UNDER THE CONTRACT.

**EBASCO SERVICES INCORPORATED**  
AGENT

96/2-86 228